



NOTES:
1. THIS DRAWING TO BE READ IN CONJUNCTION WITH DRAINAGE LAYOUT DRAWINGS, P2153/01/24.

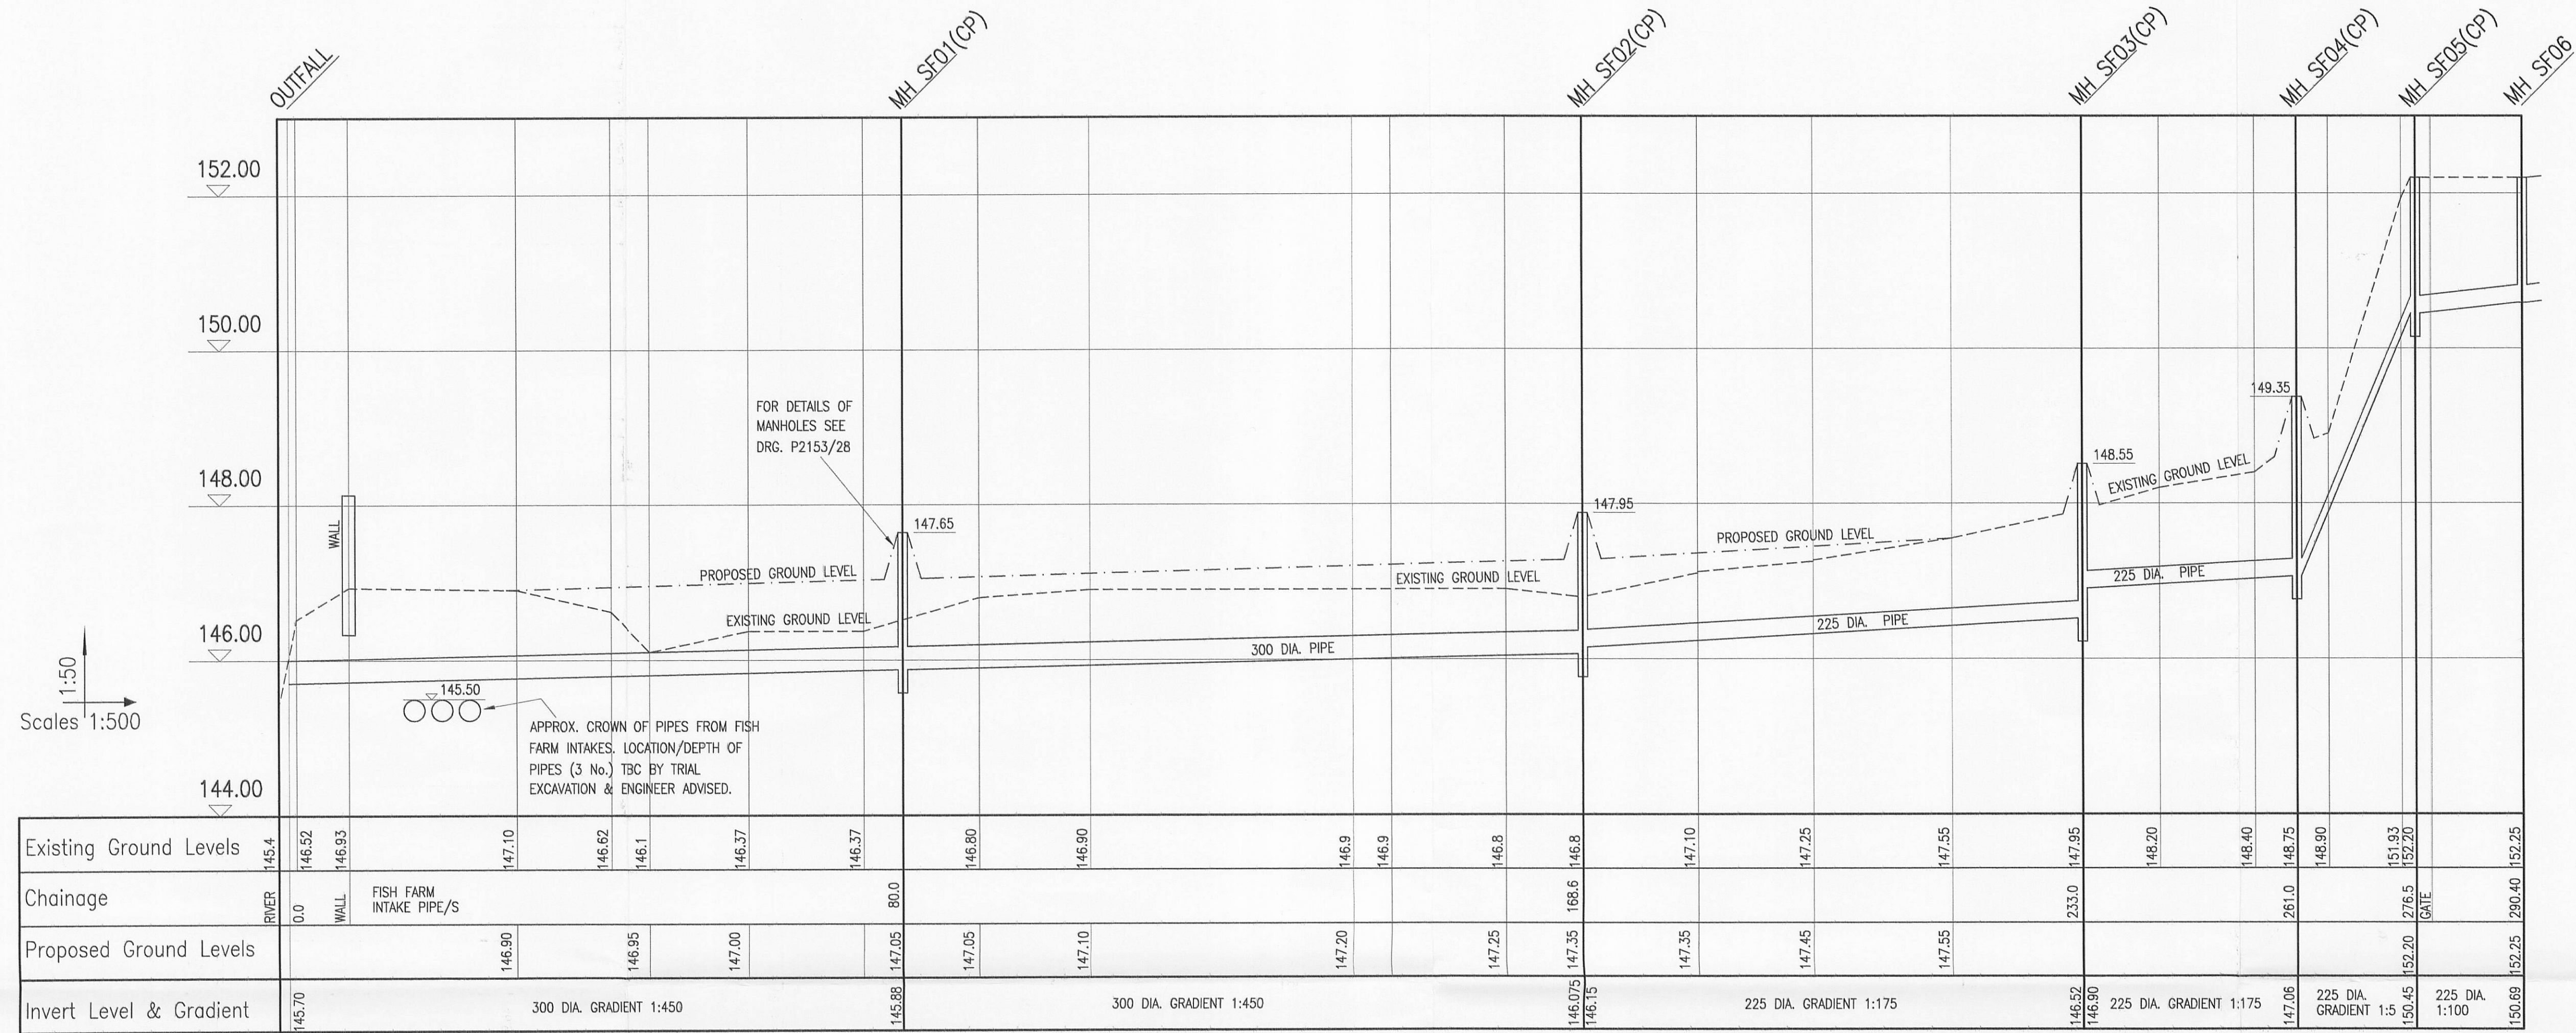

LONGITUDINAL SECTION OUTFALL TO MH SF06

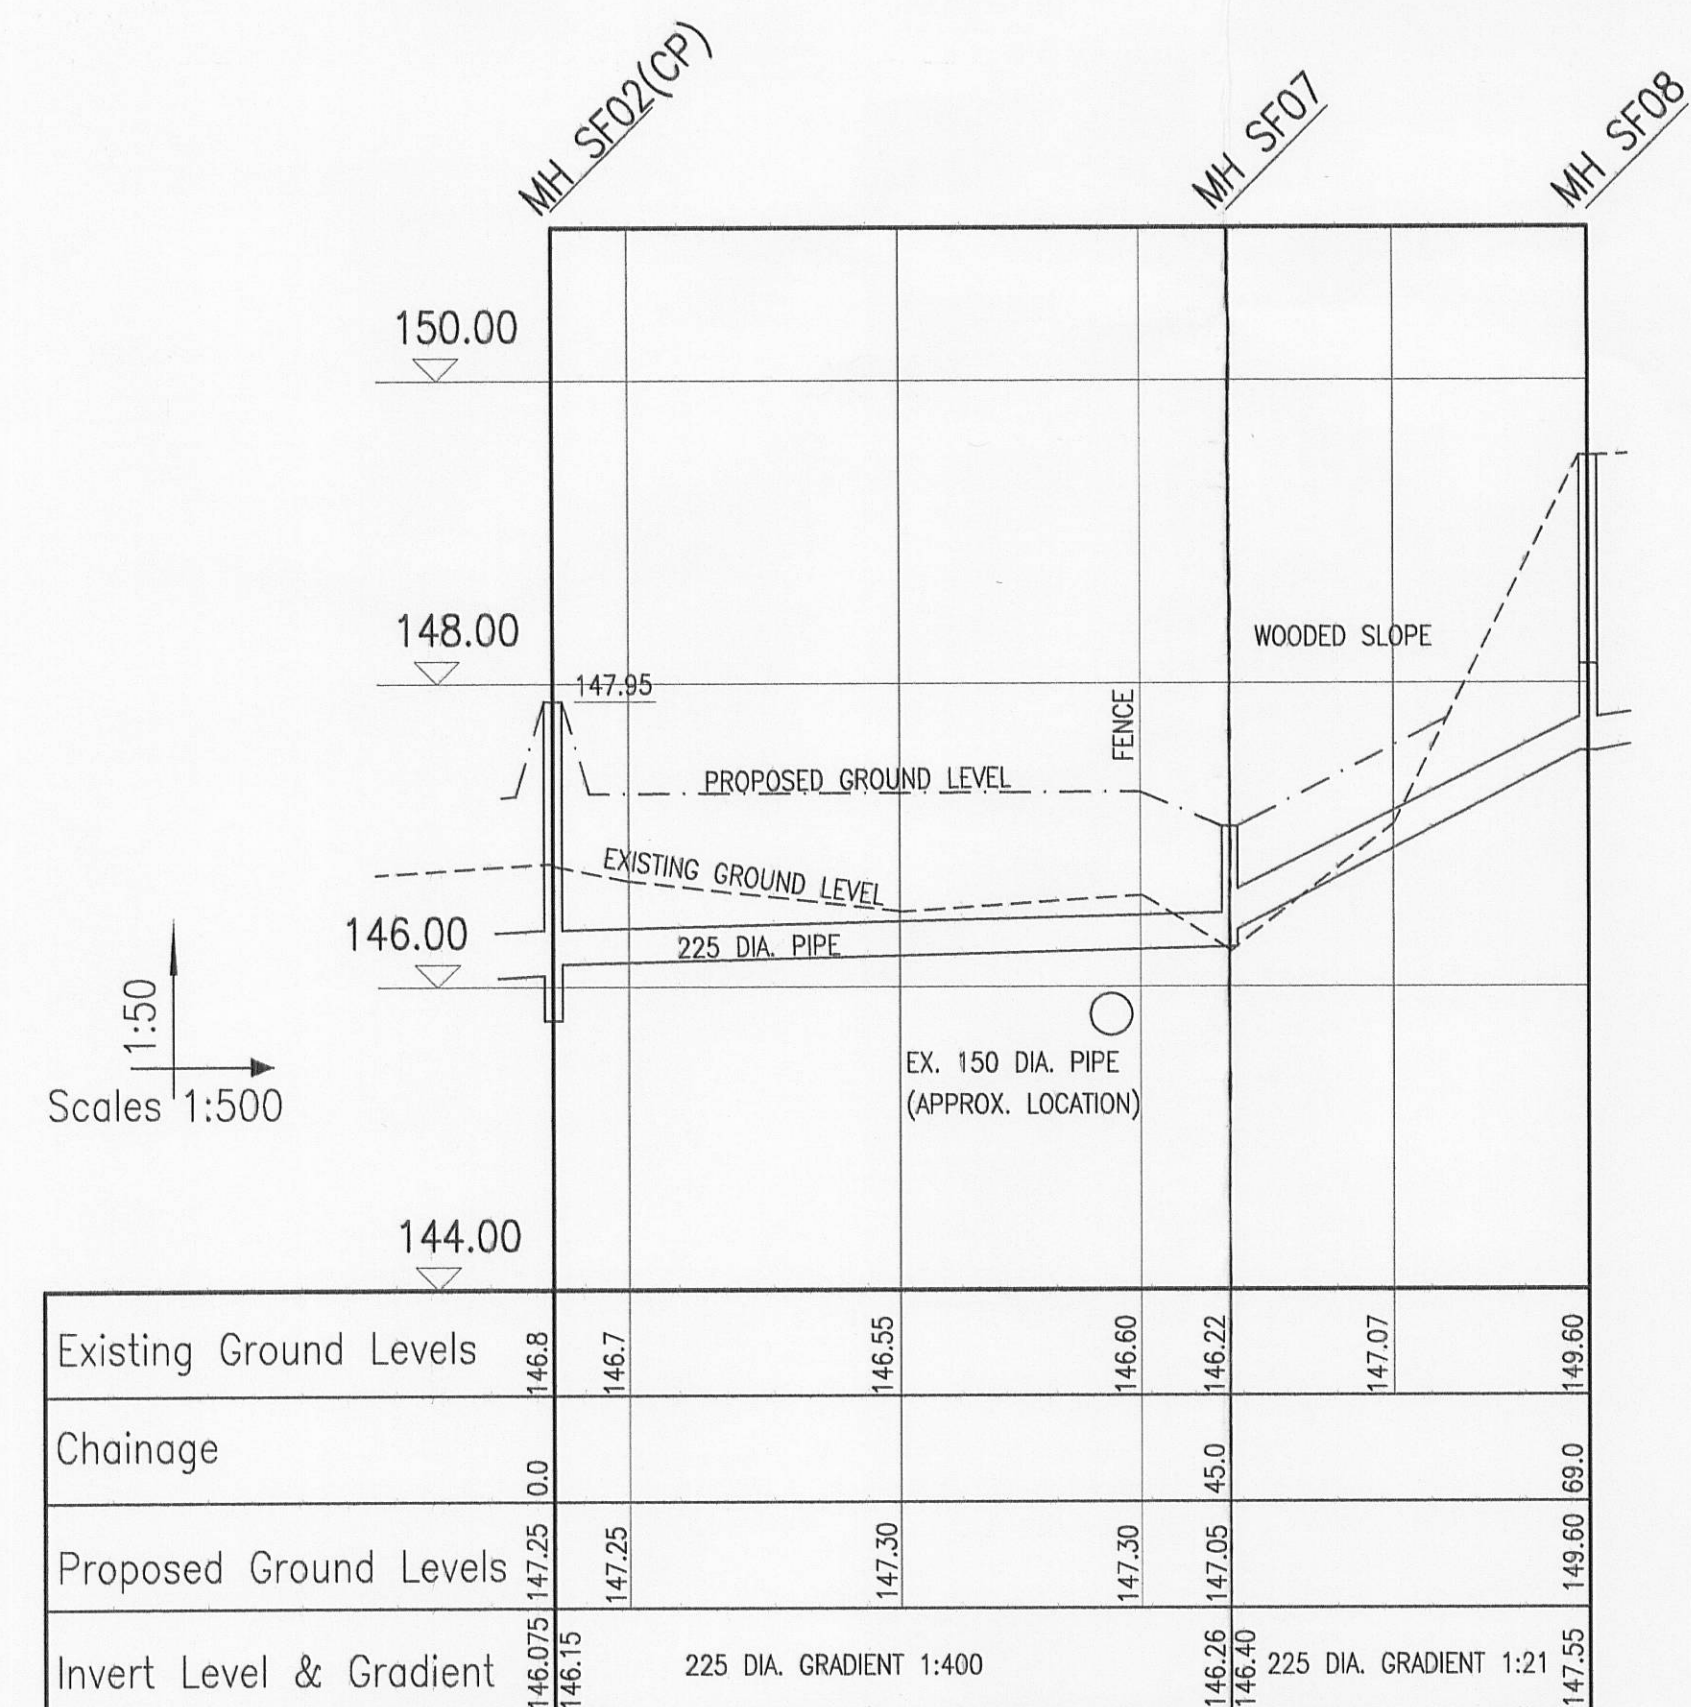

LONGITUDINAL SECTION MH SF02 TO MH SF08

320110947P

AA	ISSUED FOR CONSTRUCTION. I/s, MH LOCATIONS/NRS AMENDED.	RD OCT 11	DW OCT 11
A	ISSUED FOR COSTING	RD AUG 11	DW AUG 11
REV.	DETAILS	DRAWN DATE	CHECKED DATE

DRAWING RECORD

H.I.M. ASSOCIATES
CIVIL & STRUCTURAL ENGINEERS
136-138 Victoria Road
Walton-le-Dale
PRESTON PR5 4AU

Tel 01772 498007 Fax 01772 498008
E-mail engineer@himconsult.co.uk
Website himconsult.co.uk

JOB TITLE
**DUKE OF LANCASTER
DUNSOP BRIDGE**

DRAWING TITLE
LONGITUDINAL SECTIONS

SCALE AS SHOWN	DRAWN BY RD	DATE MAR 11
JOB / DRAWING NUMBER P2153/25	REVISION AA	