





Street Scene Section A - A

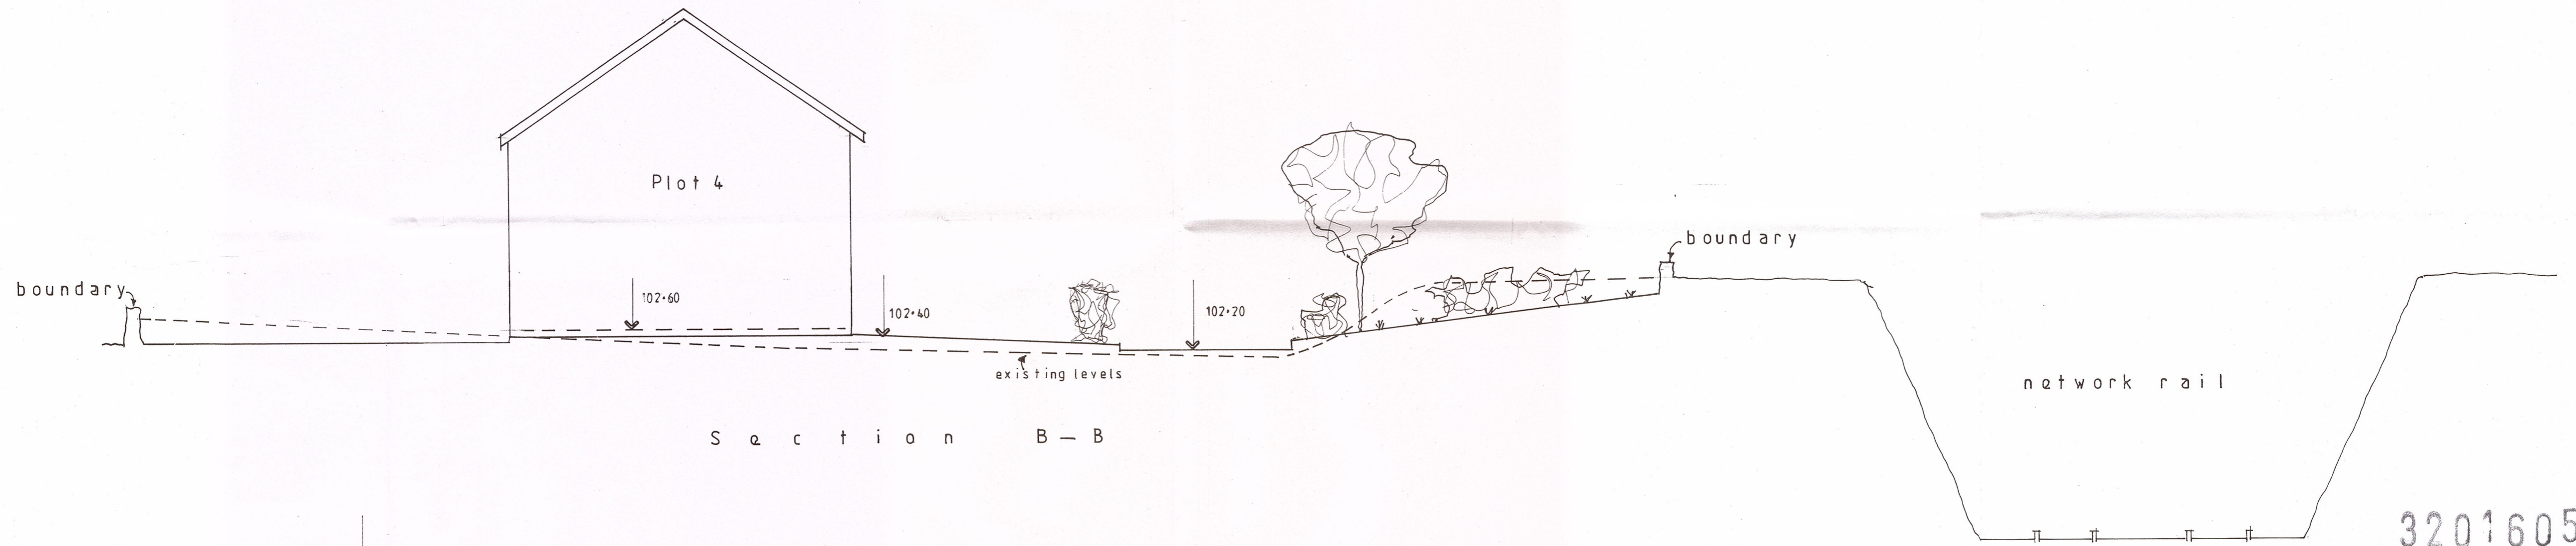

Section B - B

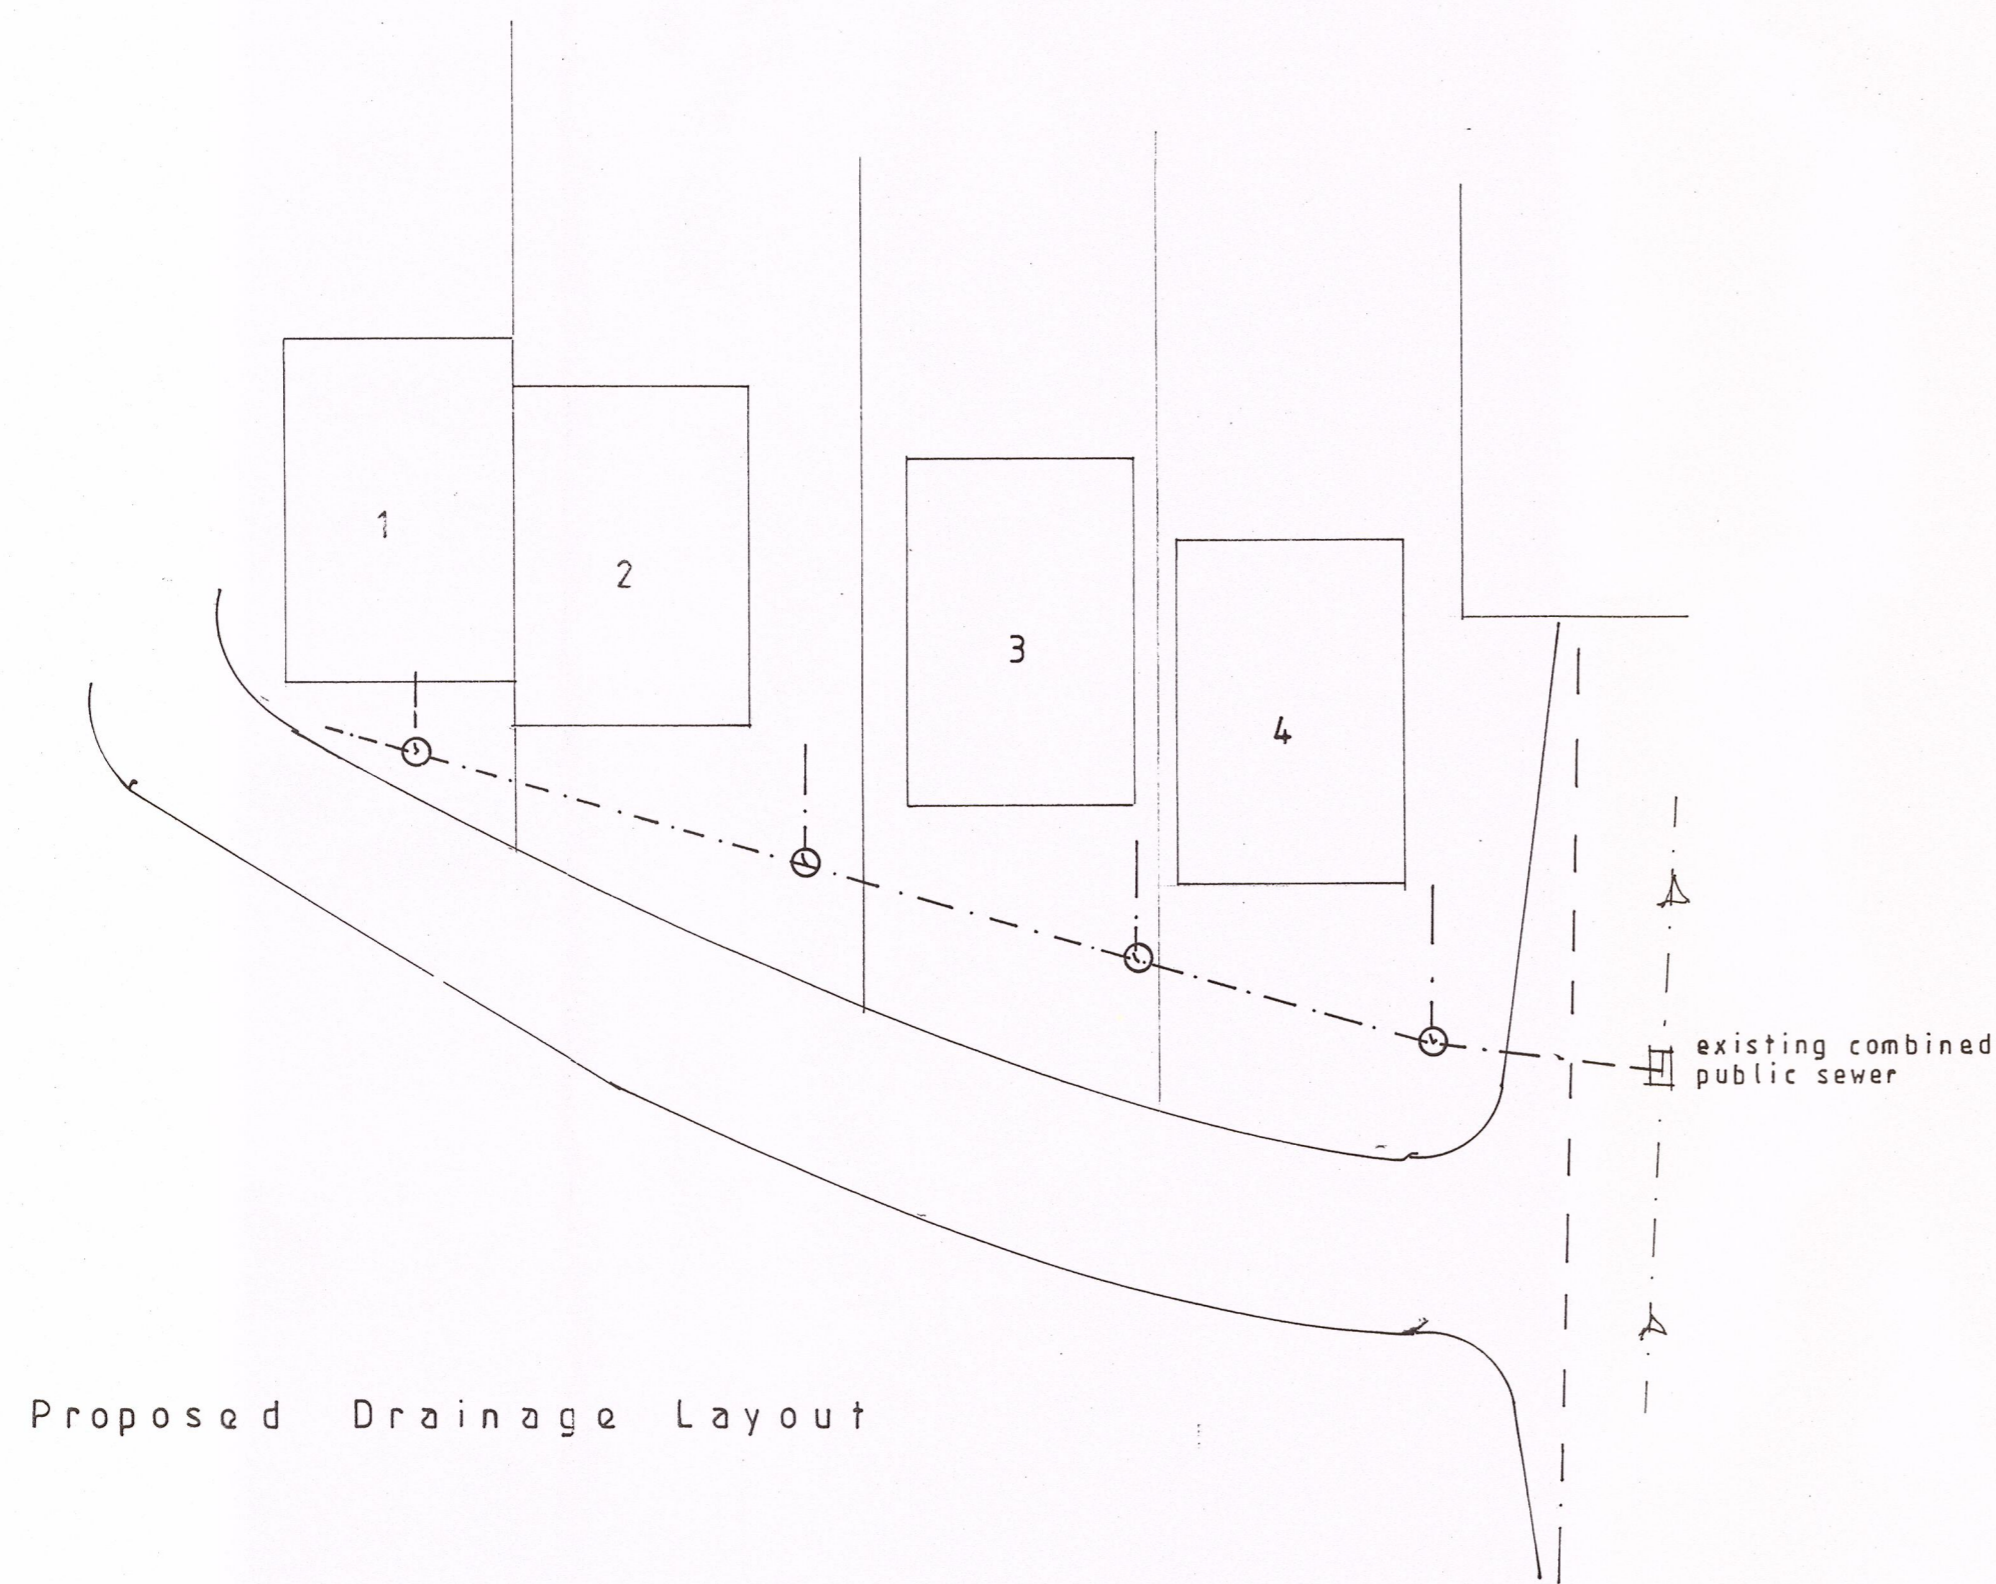

Proposed Drainage Layout

320160577P

S.J Bialecki Limited Building Surveyors
Drawing no 5010.
Scale 1:100 + 1:200
Proposed Street Scenes Drain Detail
Proposed Residential Development On Land Off Ribblesdale View Chatburn