





Street Scene Section A - A

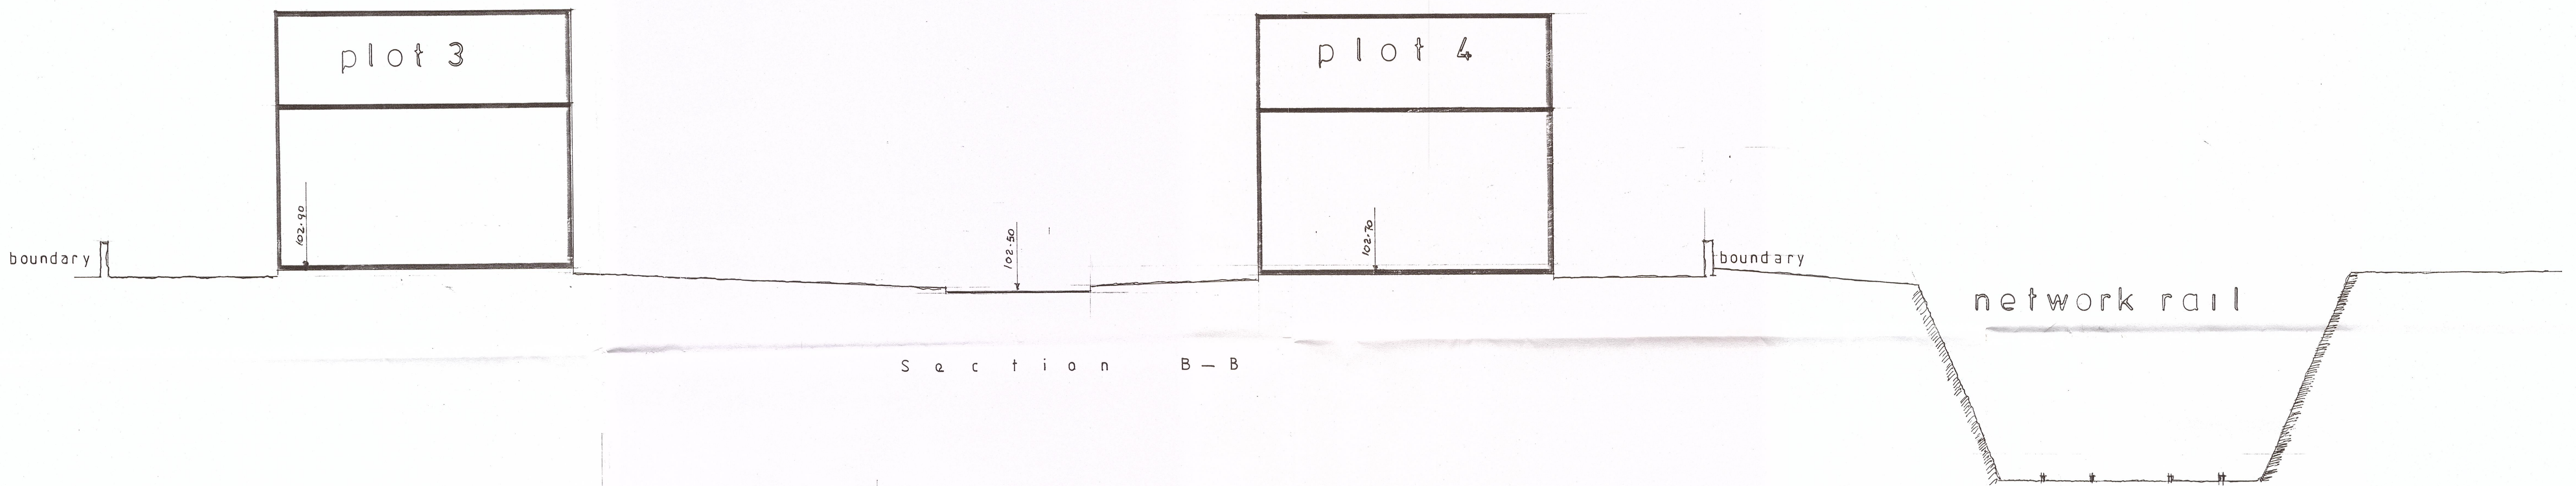

Section B - B

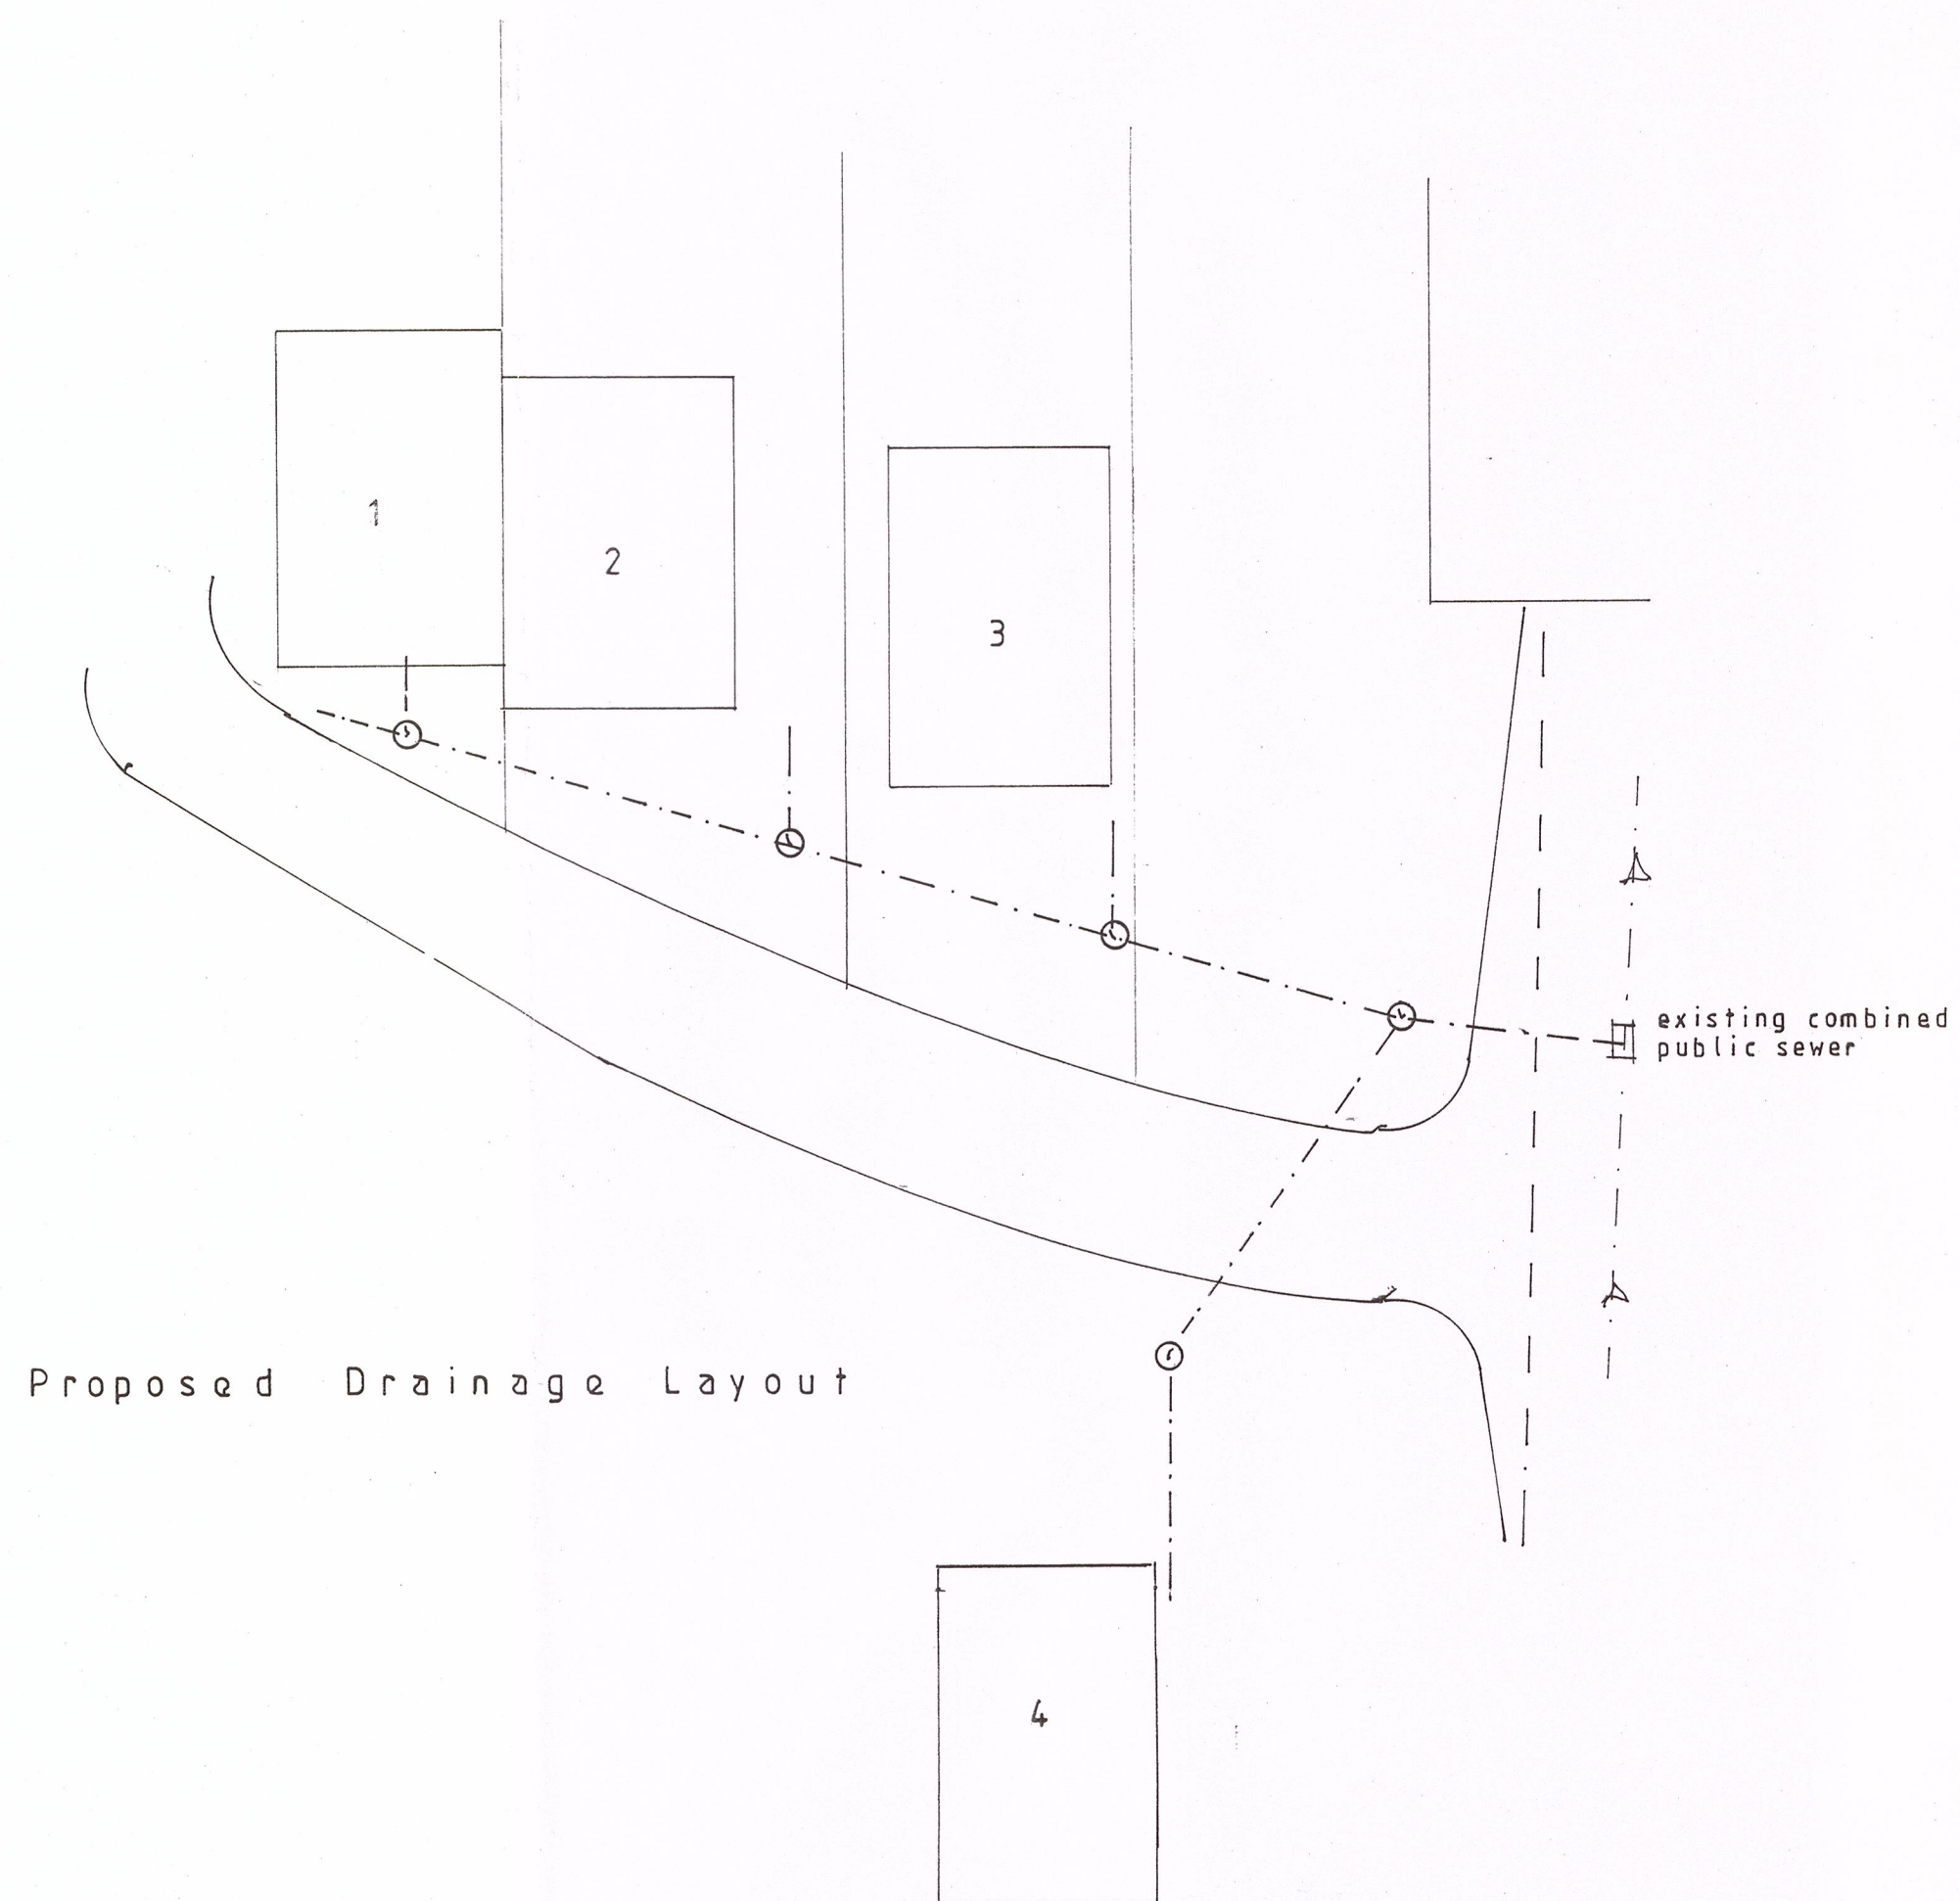

Proposed Drainage Layout

S.J Bialecki Limited Building Surveyors
Drawing no <u>5010.a</u>
Scale 1:100 + 1:200
Proposed Street Scenes Drain Detail
Proposed Residential Development On Land Off Ribblesdale View Chatburn

320160577P

amendment 15.11.16
relocation of plot 4

AMENDED PLANS RECEIVED
DATE 15.11.16