


Key

- BT Below Ground
- Electricity LV supply
- - - Water Main
- Gas LP Main
- - - Gas MP Main
- FW Sewer
- SW Sewer
- Combined Sewer

For Illustration Purposes
only
DO NOT SCALE

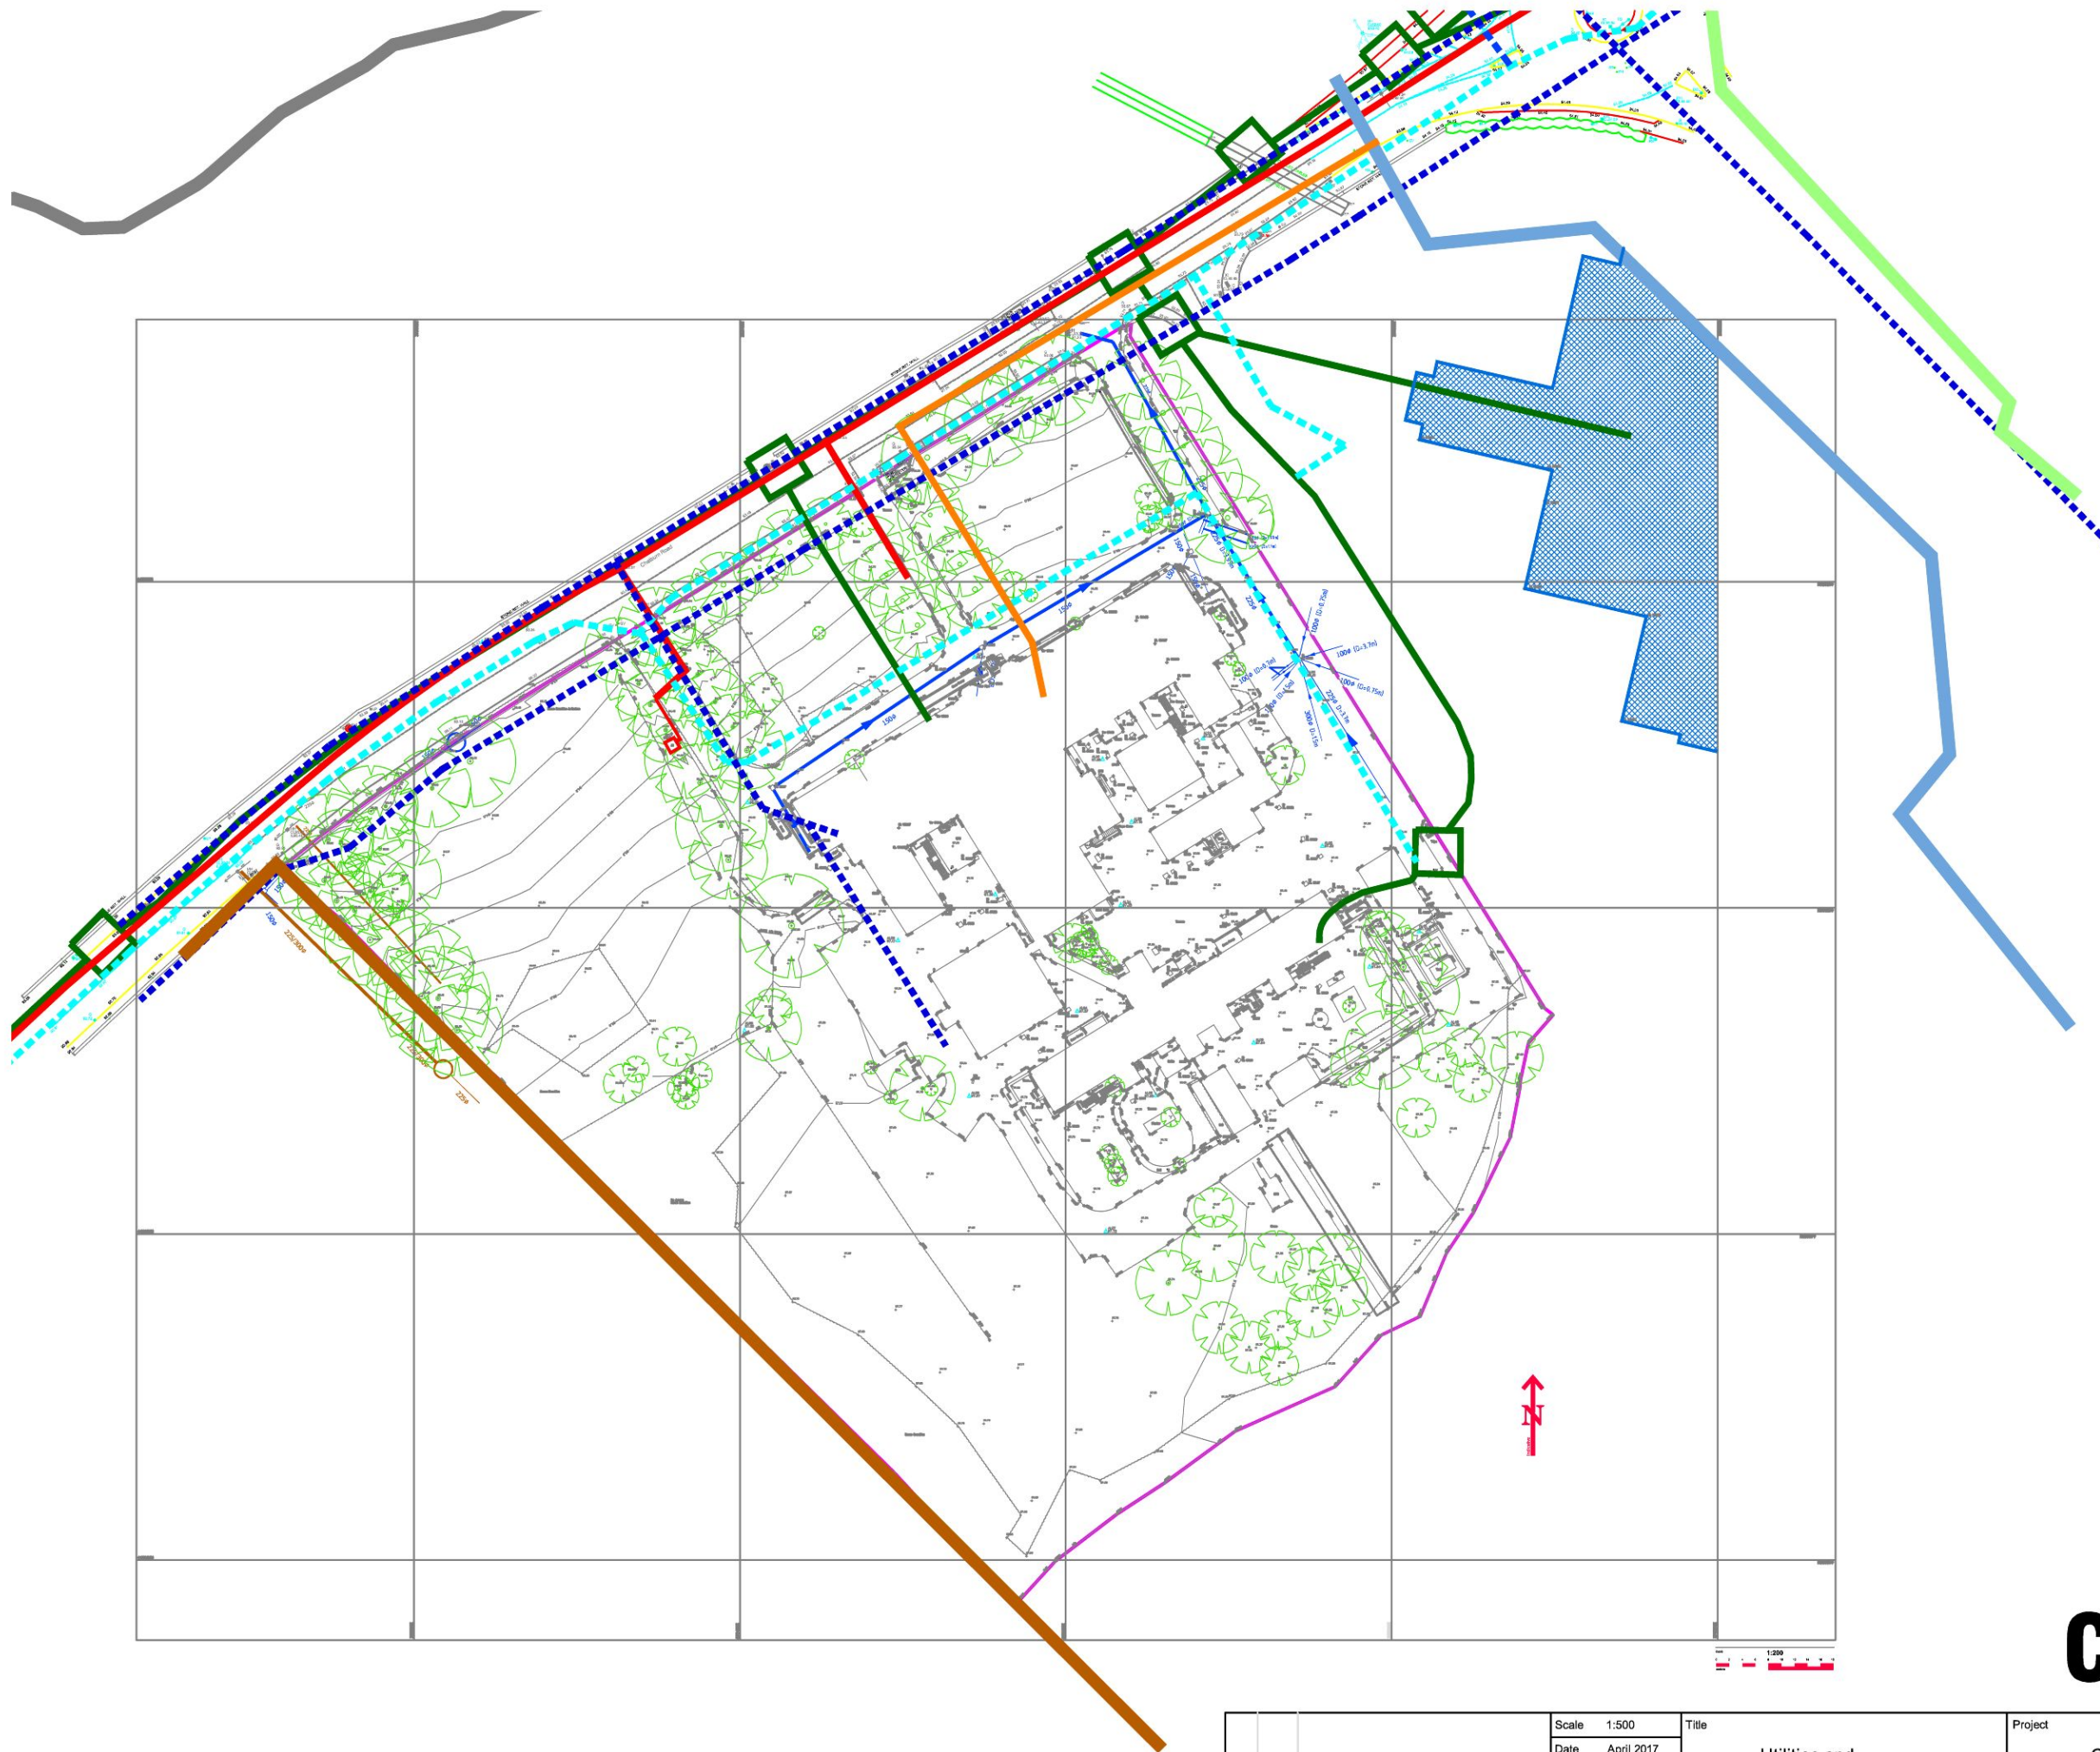

Chatburn Road

	Scale 1:500	Title Utilities and Drainage Plan	Project Chatburn Road, Clitheroe	
	Date April 2017			
	Dwg No UDP-01			
Rev	Date	Revision		