
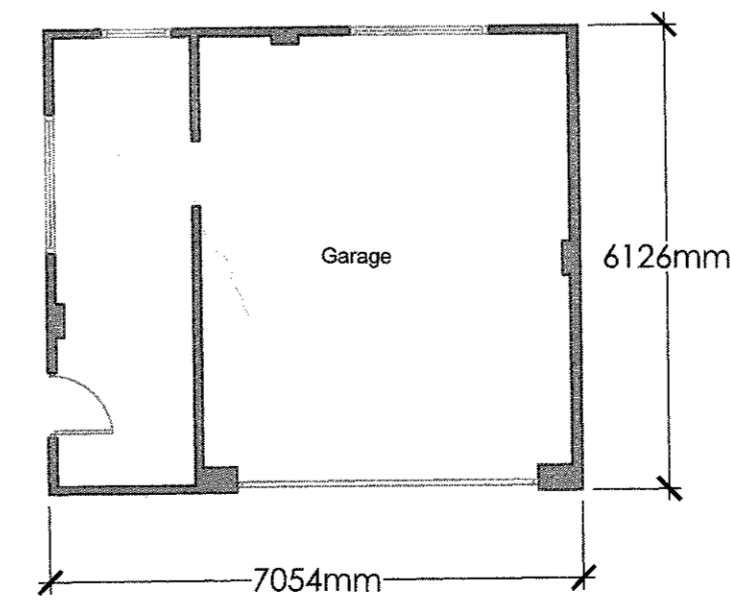
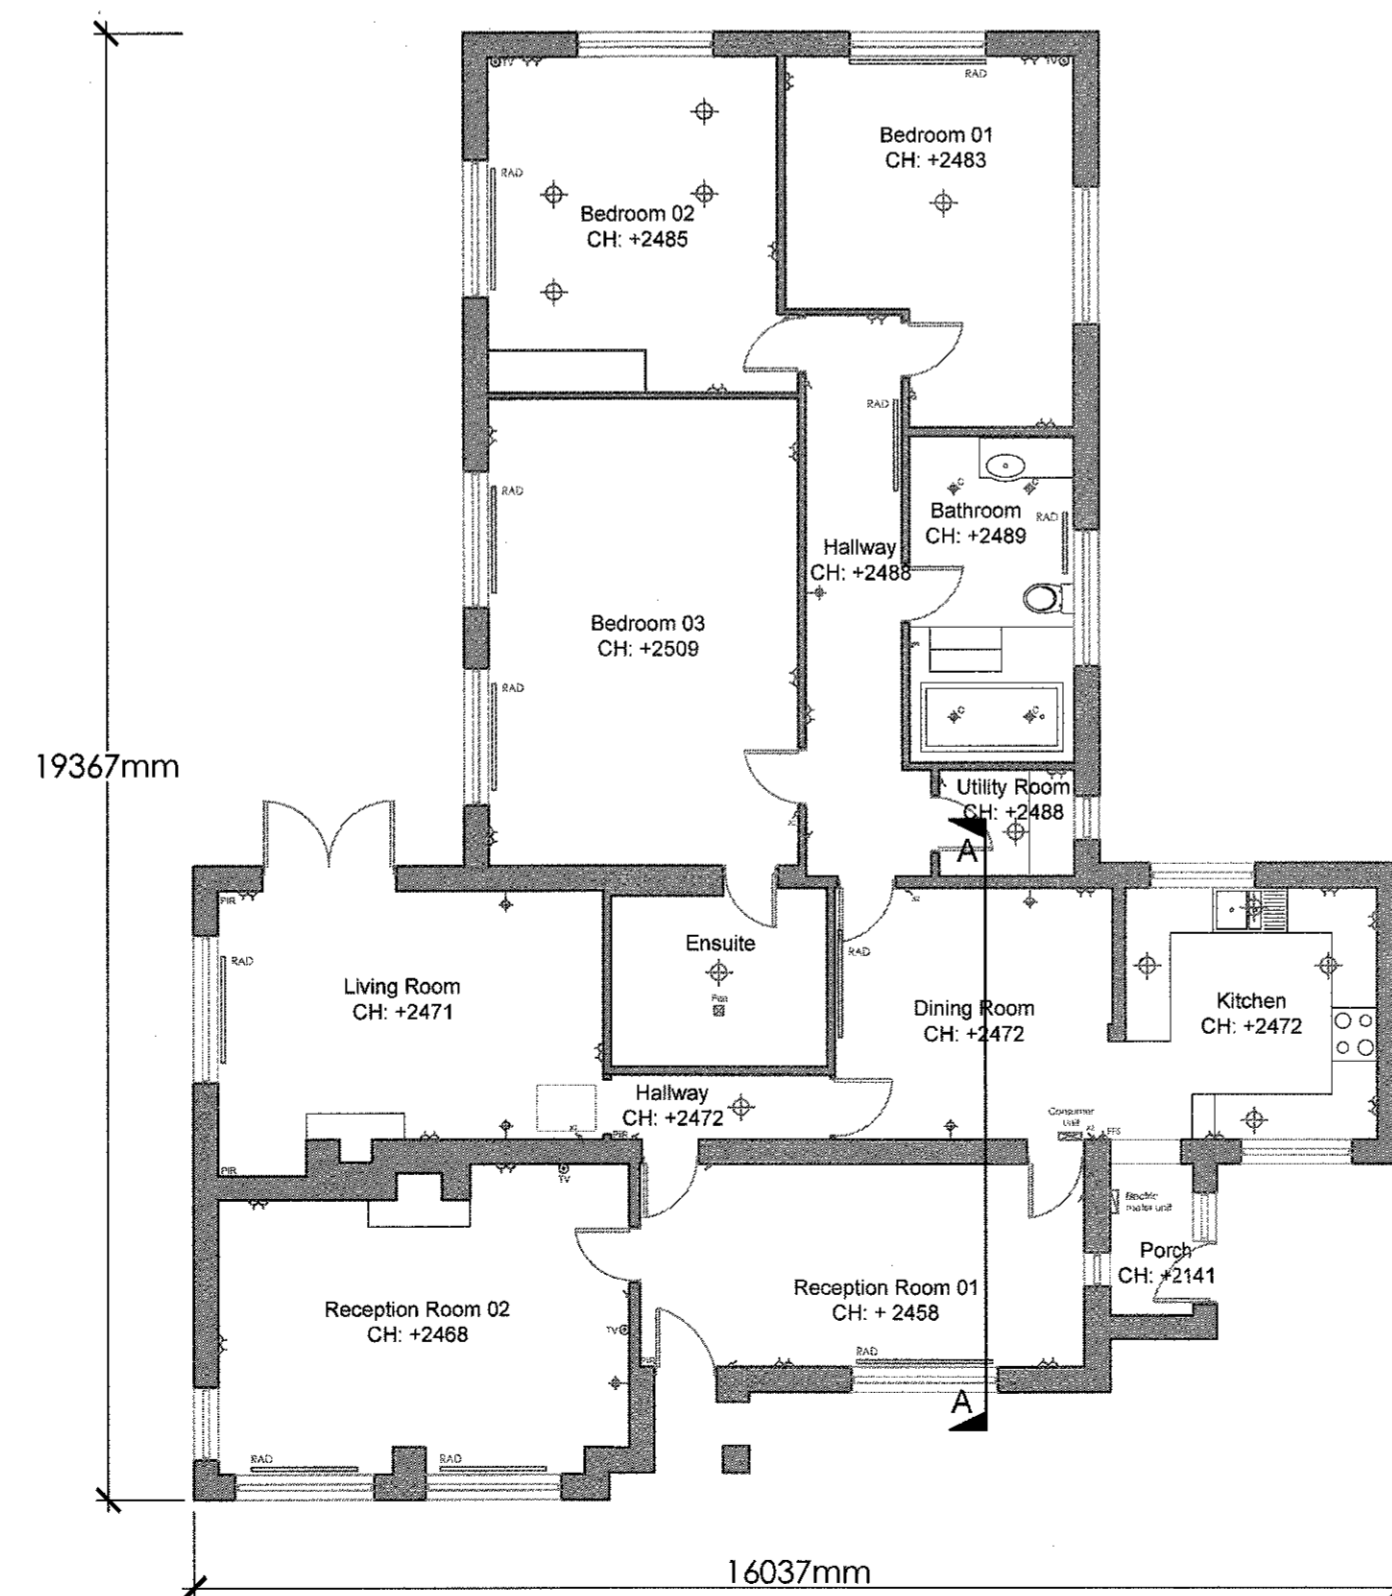


Key

- Radiator
- PIR Sensor
- External wall light
- TV point to provide Sky
- Light switch
- Pull cord light switch
- Double switched socket
- Thermostat
- Pendant Light
- Recessed LED ceiling light
- Electric radiator unit
- Consumer unit complete with MCB's and RCD's
- Fixed fused spur (switched)
- Fan ceiling mounted extract fan
- Heated towel rail

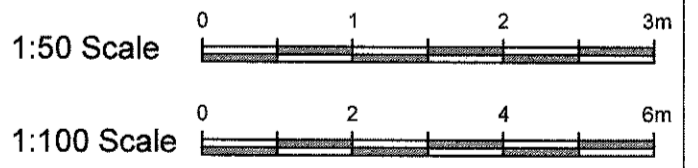

Client: Mr and Mrs Taylor

Job title: Proposed Alterations and Extension to Wallace House Lower Chapel Lane Grindleton BB7 4RN

320170710P

Existing Floor Plans & Elevations

Scale: As Shown@A1 Date: June 2017 Drawn: MF

spa ARCHITECTS

SUNDERLAND PEACOCK & ASSOCIATES LTD.
WALSINGHAM PARKWOOD ROAD, CUMMERIDGE
LANCASHIRE, BB7 2AG
T 01204 423119 F 01204 423128
E info@sunderlandpeacock.com
www.sunderlandpeacock.com

5362 - 01