




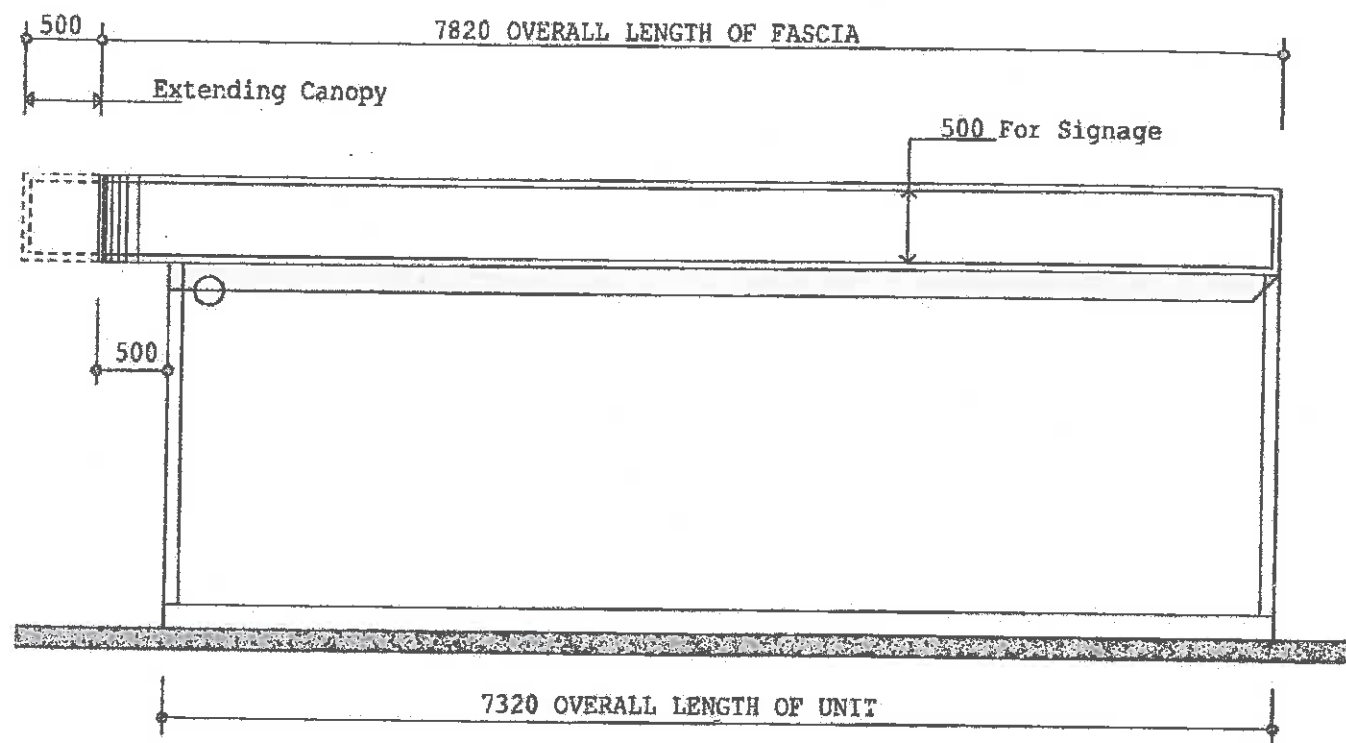

SIDE ELEVATION

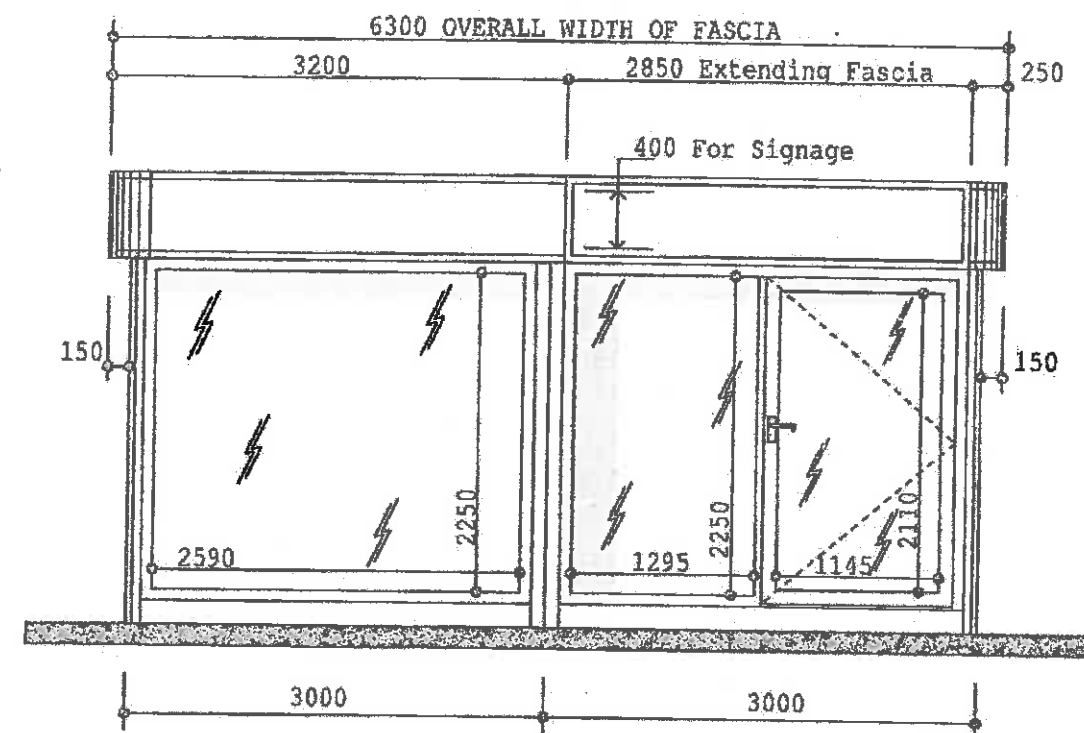

FRONT ELEVATION

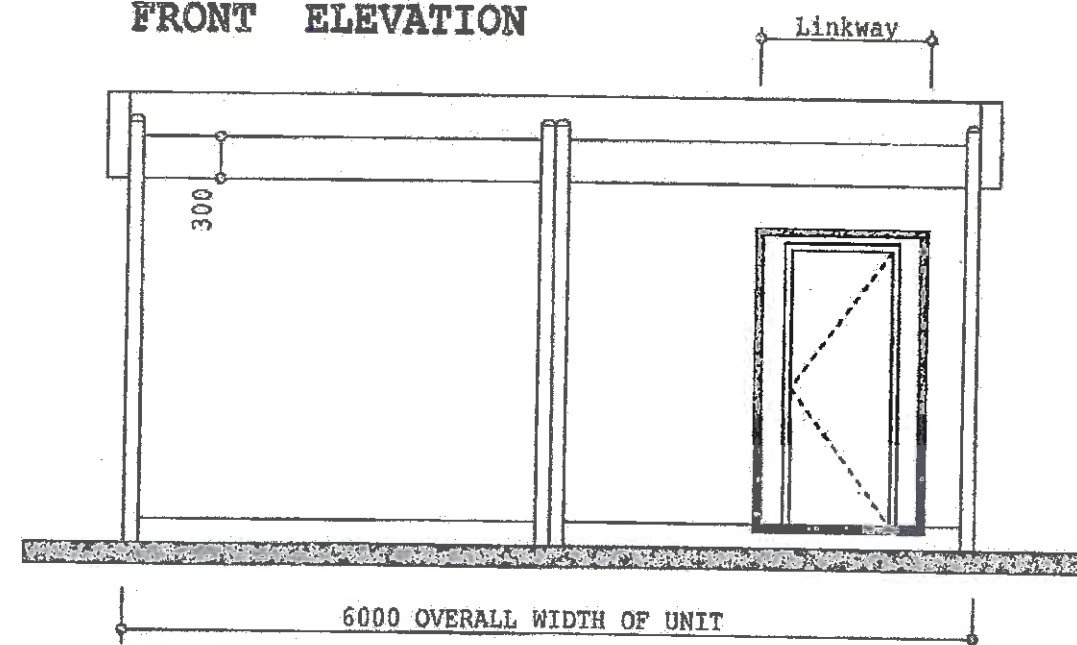

REAR ELEVATION

SIDE ELEVATION

1		2		3		4		5		6		7		8		9	
TITLE																	
TEL/FAX																	
CONTACT																	
DRAWING No 02																	
DATE																	
DRAWN BY																	
REVISION No																	
NOTES																	
Scale 1:50																	

KEY

- | | | |
|---------------------------|-------------------|----------------------------|
| Single contact point | Light switch | Fluor Panel |
| Two contact points | Light switch cord | Operation Control Box |
| Surround panel sign | Extractor fan | Power Alarm System |
| 30W cooler panel | Emergency exit | Extinguisher mounted light |
| Cooling light | Roof | |
| Fluorescent light fixture | | |



320171086