


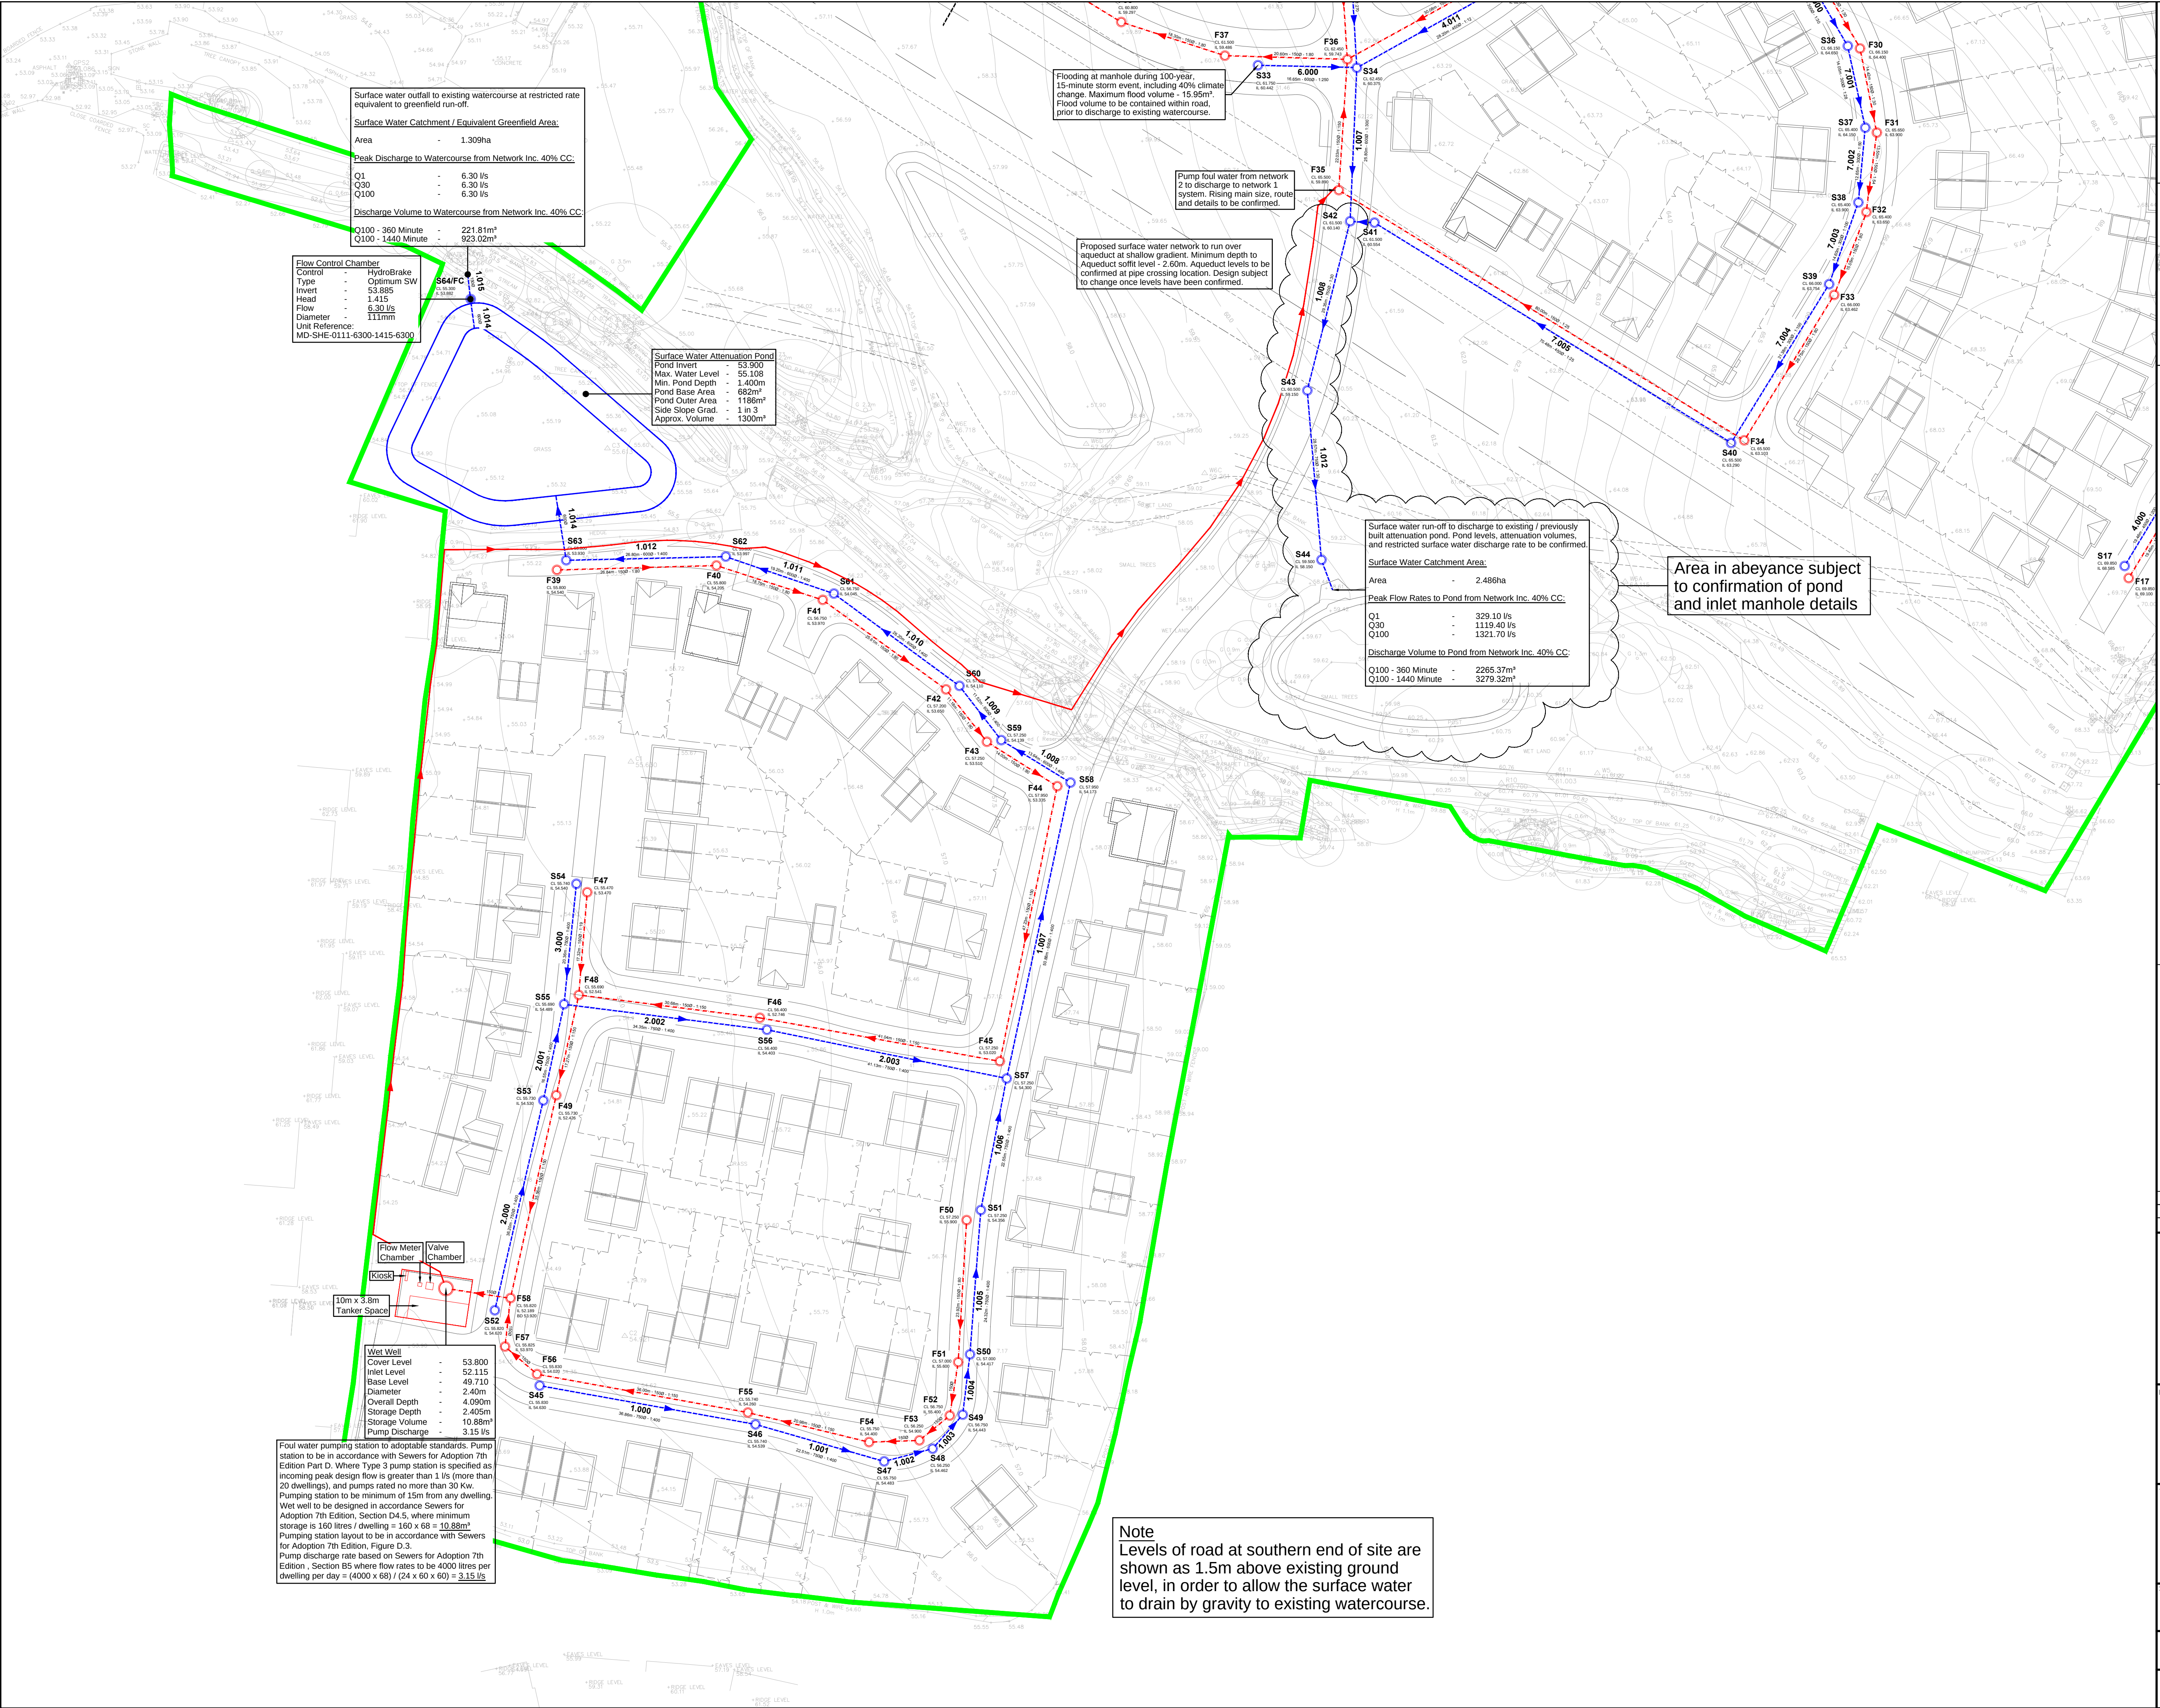

Standard Notes

- This drawing is to be read in conjunction with all relevant Architect's and Engineer's drawings and the specification.
- This drawing should not be scaled.
- All dimensions are to be verified by the contractor on site.
- All discrepancies should be reported to the C.A. prior to the commencement of the works.

© CIVIC ENGINEERS

Location Plan

Notes and Keys

GENERAL NOTES

- ALL MATERIALS AND WORKMANSHIP IS TO COMPLY WITH CIVIC ENGINEERS STANDARD SPECIFICATION & ALL RELEVANT BRITISH & EUROPEAN STANDARDS.
- THIS DRAWING IS TO BE READ IN CONJUNCTION WITH ALL RELEVANT ARCHITECTS, M & E CONSULTANTS AND CIVIC ENGINEERS DRAWINGS.
- ANY DISCREPANCIES SHOULD BE REPORTED TO THE ENGINEER IMMEDIATELY SO THAT CLARIFICATION CAN BE SOUGHT PRIOR TO COMMENCEMENT OF WORKS.

DRAINAGE NOTES

- MAIN DRAINAGE NETWORK SHOWN ONLY. PLOT DRAINAGE DETAILS TO BE CONFIRMED AT DETAILED DESIGN STAGE.
- SURFACE WATER NETWORK DESIGNED WITH 40% CLIMATE CHANGE, AND DESIGNED FOR NO FLOODING DURING 1 IN 30-YEAR EVENTS, AND MINOR CONTROLLED / CONTAINED FLOODING DURING 1 IN 100-YEAR EVENT.
- DISCHARGE TO EXISTING POND AND WATERCOURSE TO BE AGREED WITH LOCAL AUTHORITY

Proposed SW Drainage

Proposed FW Drainage

Existing SW Drainage

Existing FW Drainage

FW Rising Main

25.09.18	P2	Amended to Suit Revised Site Layout	MDS	PM
30.08.18	P1	Draft Stage 3 Issue	MDS	PM
Date	Rev	Description	Drawn	Chkd

Civic Engineers

MANCHESTER
LONDON
LEEDS

Carver's Warehouse, 77 Dale Street, Manchester, M1 2HG. Tel: 0161 228 6757
Lloyds Wharf, 3 Mill Street, London SE1 2BD. Tel: 020 7253 2977
Tower Works, Unit 02-01, Globe Road, Leeds, LS11 5QG. Tel: 0113 2025 130

www.civicengineers.com

Project

Residential Housing
Whalley, Lancashire

Title

Below Ground Drainage Layout
Sheet 2

Status

STAGE 3 ISSUE

Scale @ A1	Date Created	Drawn	Checked
1:500	Aug-18	MDS	PM
Project Number	Originator	Discipline	Drawing Number
1040-01	CE	D	D0102

Revision	
P2	