



150mm PVC Fascia Board.
300mm PVC Soffit.
PVC rainwater goods.

RWP positions may differ from shown. For actual locations, refer to site specific drainage layout (Avoid RWP's positioned to front elevation where possible).

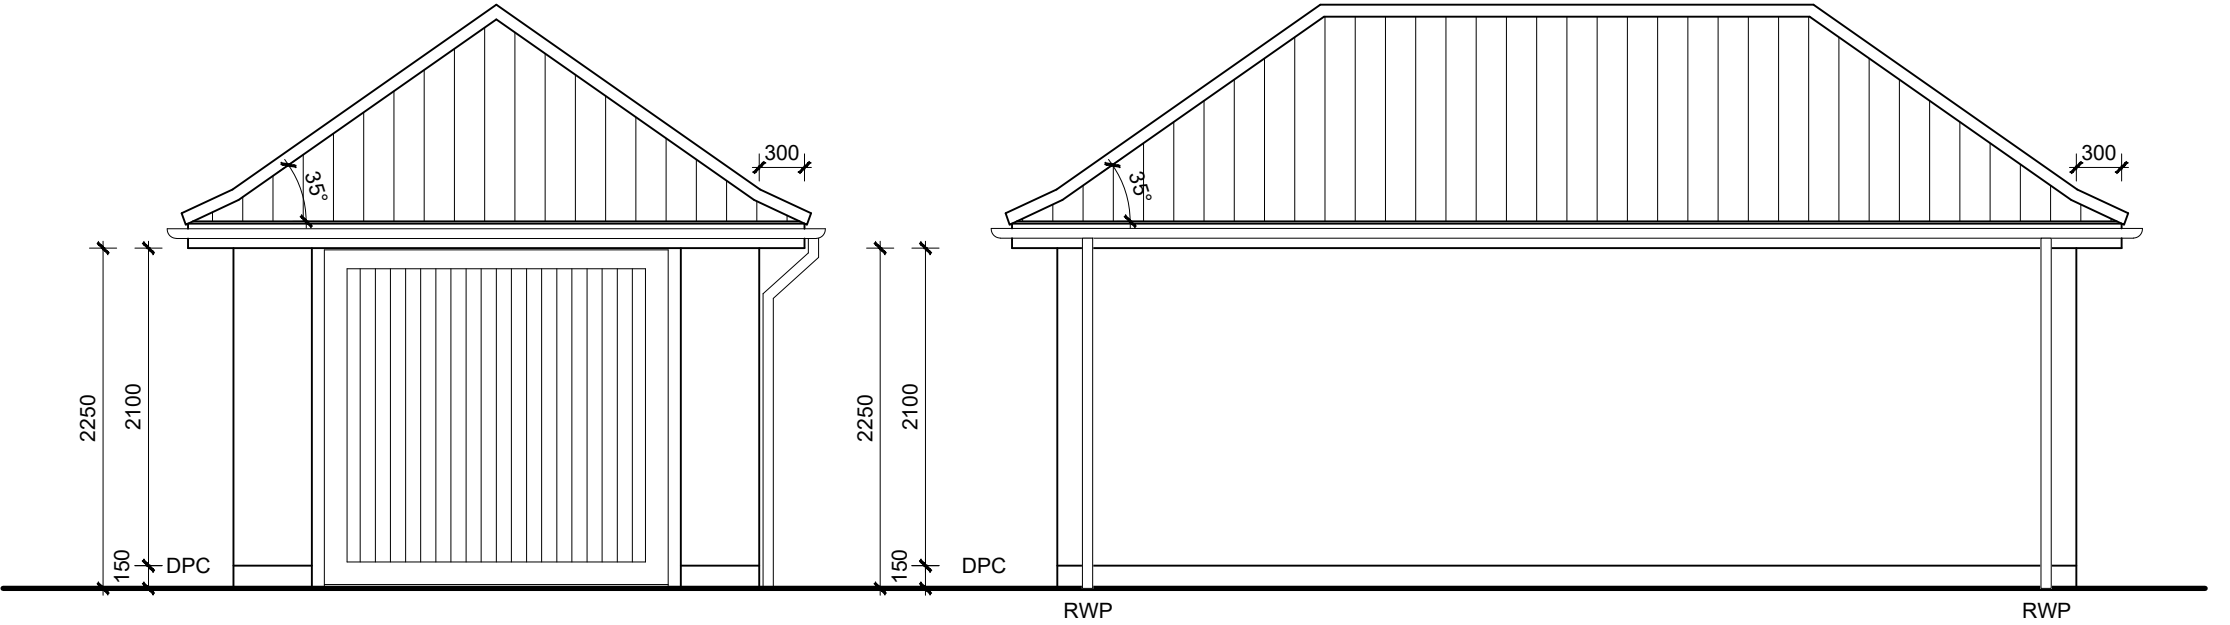

FRONT ELEVATION SIDE ELEVATION

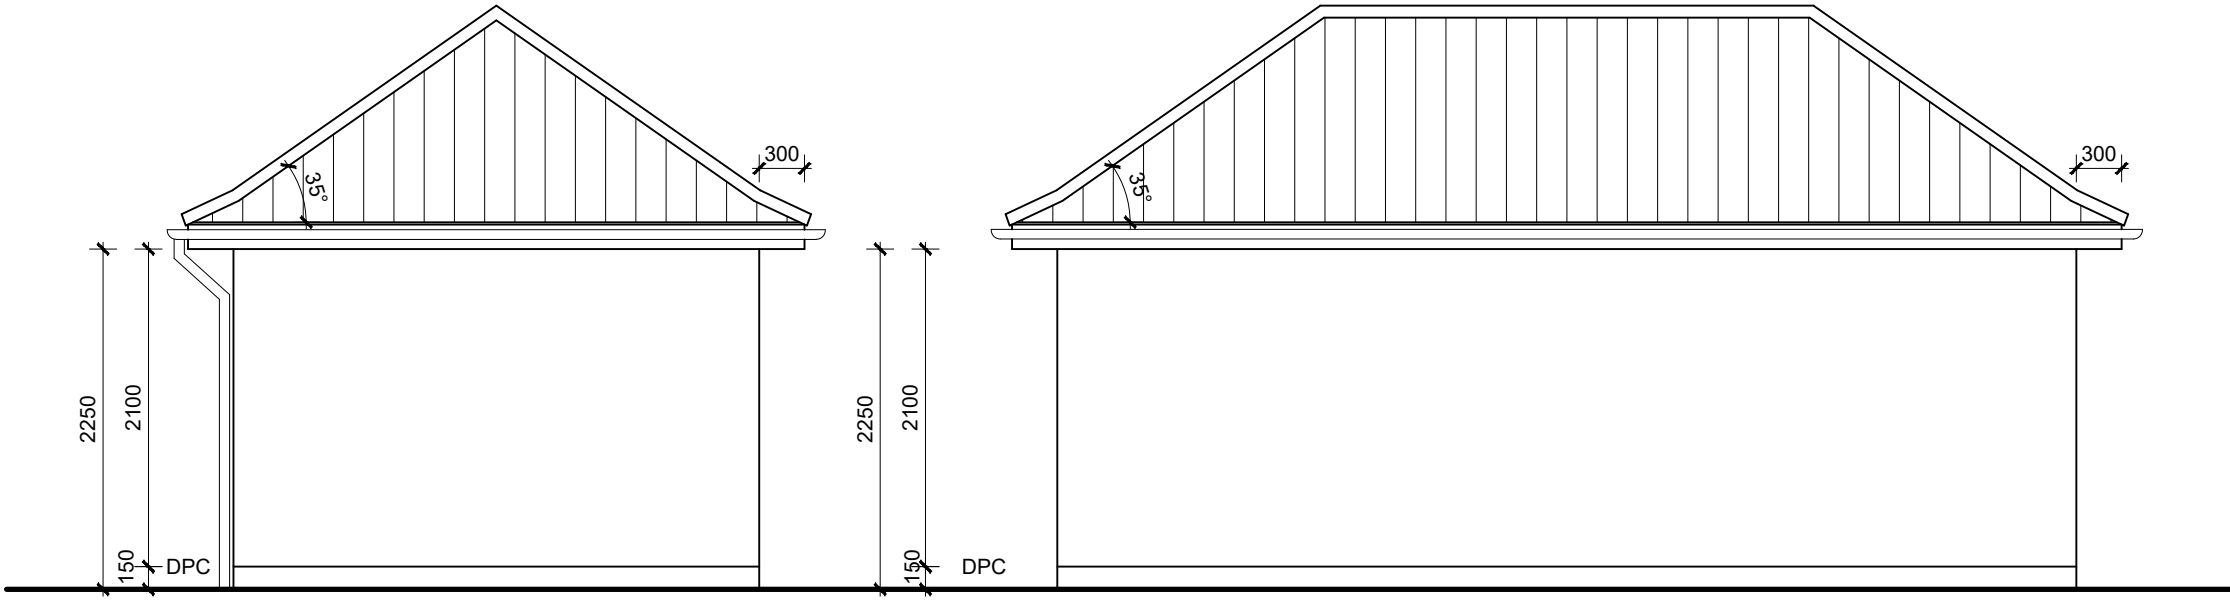

REAR ELEVATION SIDE ELEVATION

LSG1H8 GTO CODE: GLD8 SDHR




DAVID
WILSON
HOMES



BARRATT
DEVELOPMENTS PLC

Date:	
Description:	
Rev:	

Brand: BARRATT / DAVID WILSON HOMES	Date: AUG 18
Range: DUAL BRANDED GARAGES - 6x3	Scale: 1:50
Title: SINGLE - ELEVATIONS	Checked: GDT
Detail No: LSG1H8	Drawn: GDT

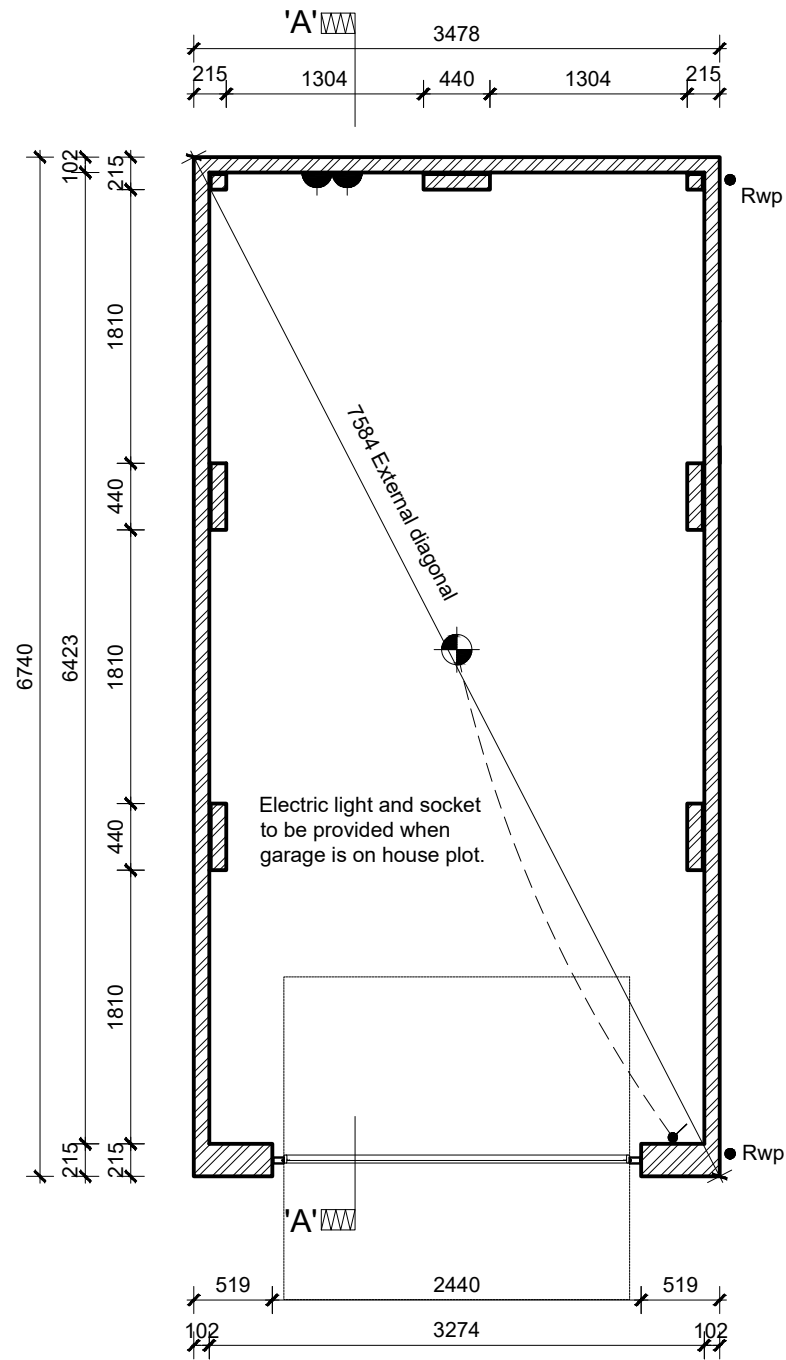

FLOOR PLAN

Solid brick internal piers to continue up the full height of the wall from foundation level. Ancon SPS CJ wall ties (or similar approved) staggered @ 375mm c/s vertically to tie piers to external brickwork (Refer to Section A-A / B-B for setting out). Lateral restraint straps to be provided at ceiling level to tie in with the pier locations.

RWP positions may differ from shown. For actual locations, refer to site specific drainage layout.

GARAGE DOOR FRAME SIZE:

7'6" x 7'2" (2286x2200). Frame to be fitted behind piers.

O/A frame width = 2286 + 140 = 2426

O/A frame height = 2200+45 = 2245

KEY:

Facing Brickwork (Ext Walls - Ext Leaf).

Double sockets, pendant light and light switch only to be provided when garage is positioned on the same plot as accompanying house.

- Double Socket.
- Pendant Light.
- Light Switch.

LSG1H8 GTO CODE: GLD8 SDHR

Date:

Description:

Rev: