


 
GENERAL NOTES

1. DRAWING SHALL BE READ IN CONJUNCTION WITH ALL ARCHITECTURAL SERVICE DRAWINGS.

2. DRAWING SHALL NOT BE SCALED FROM.

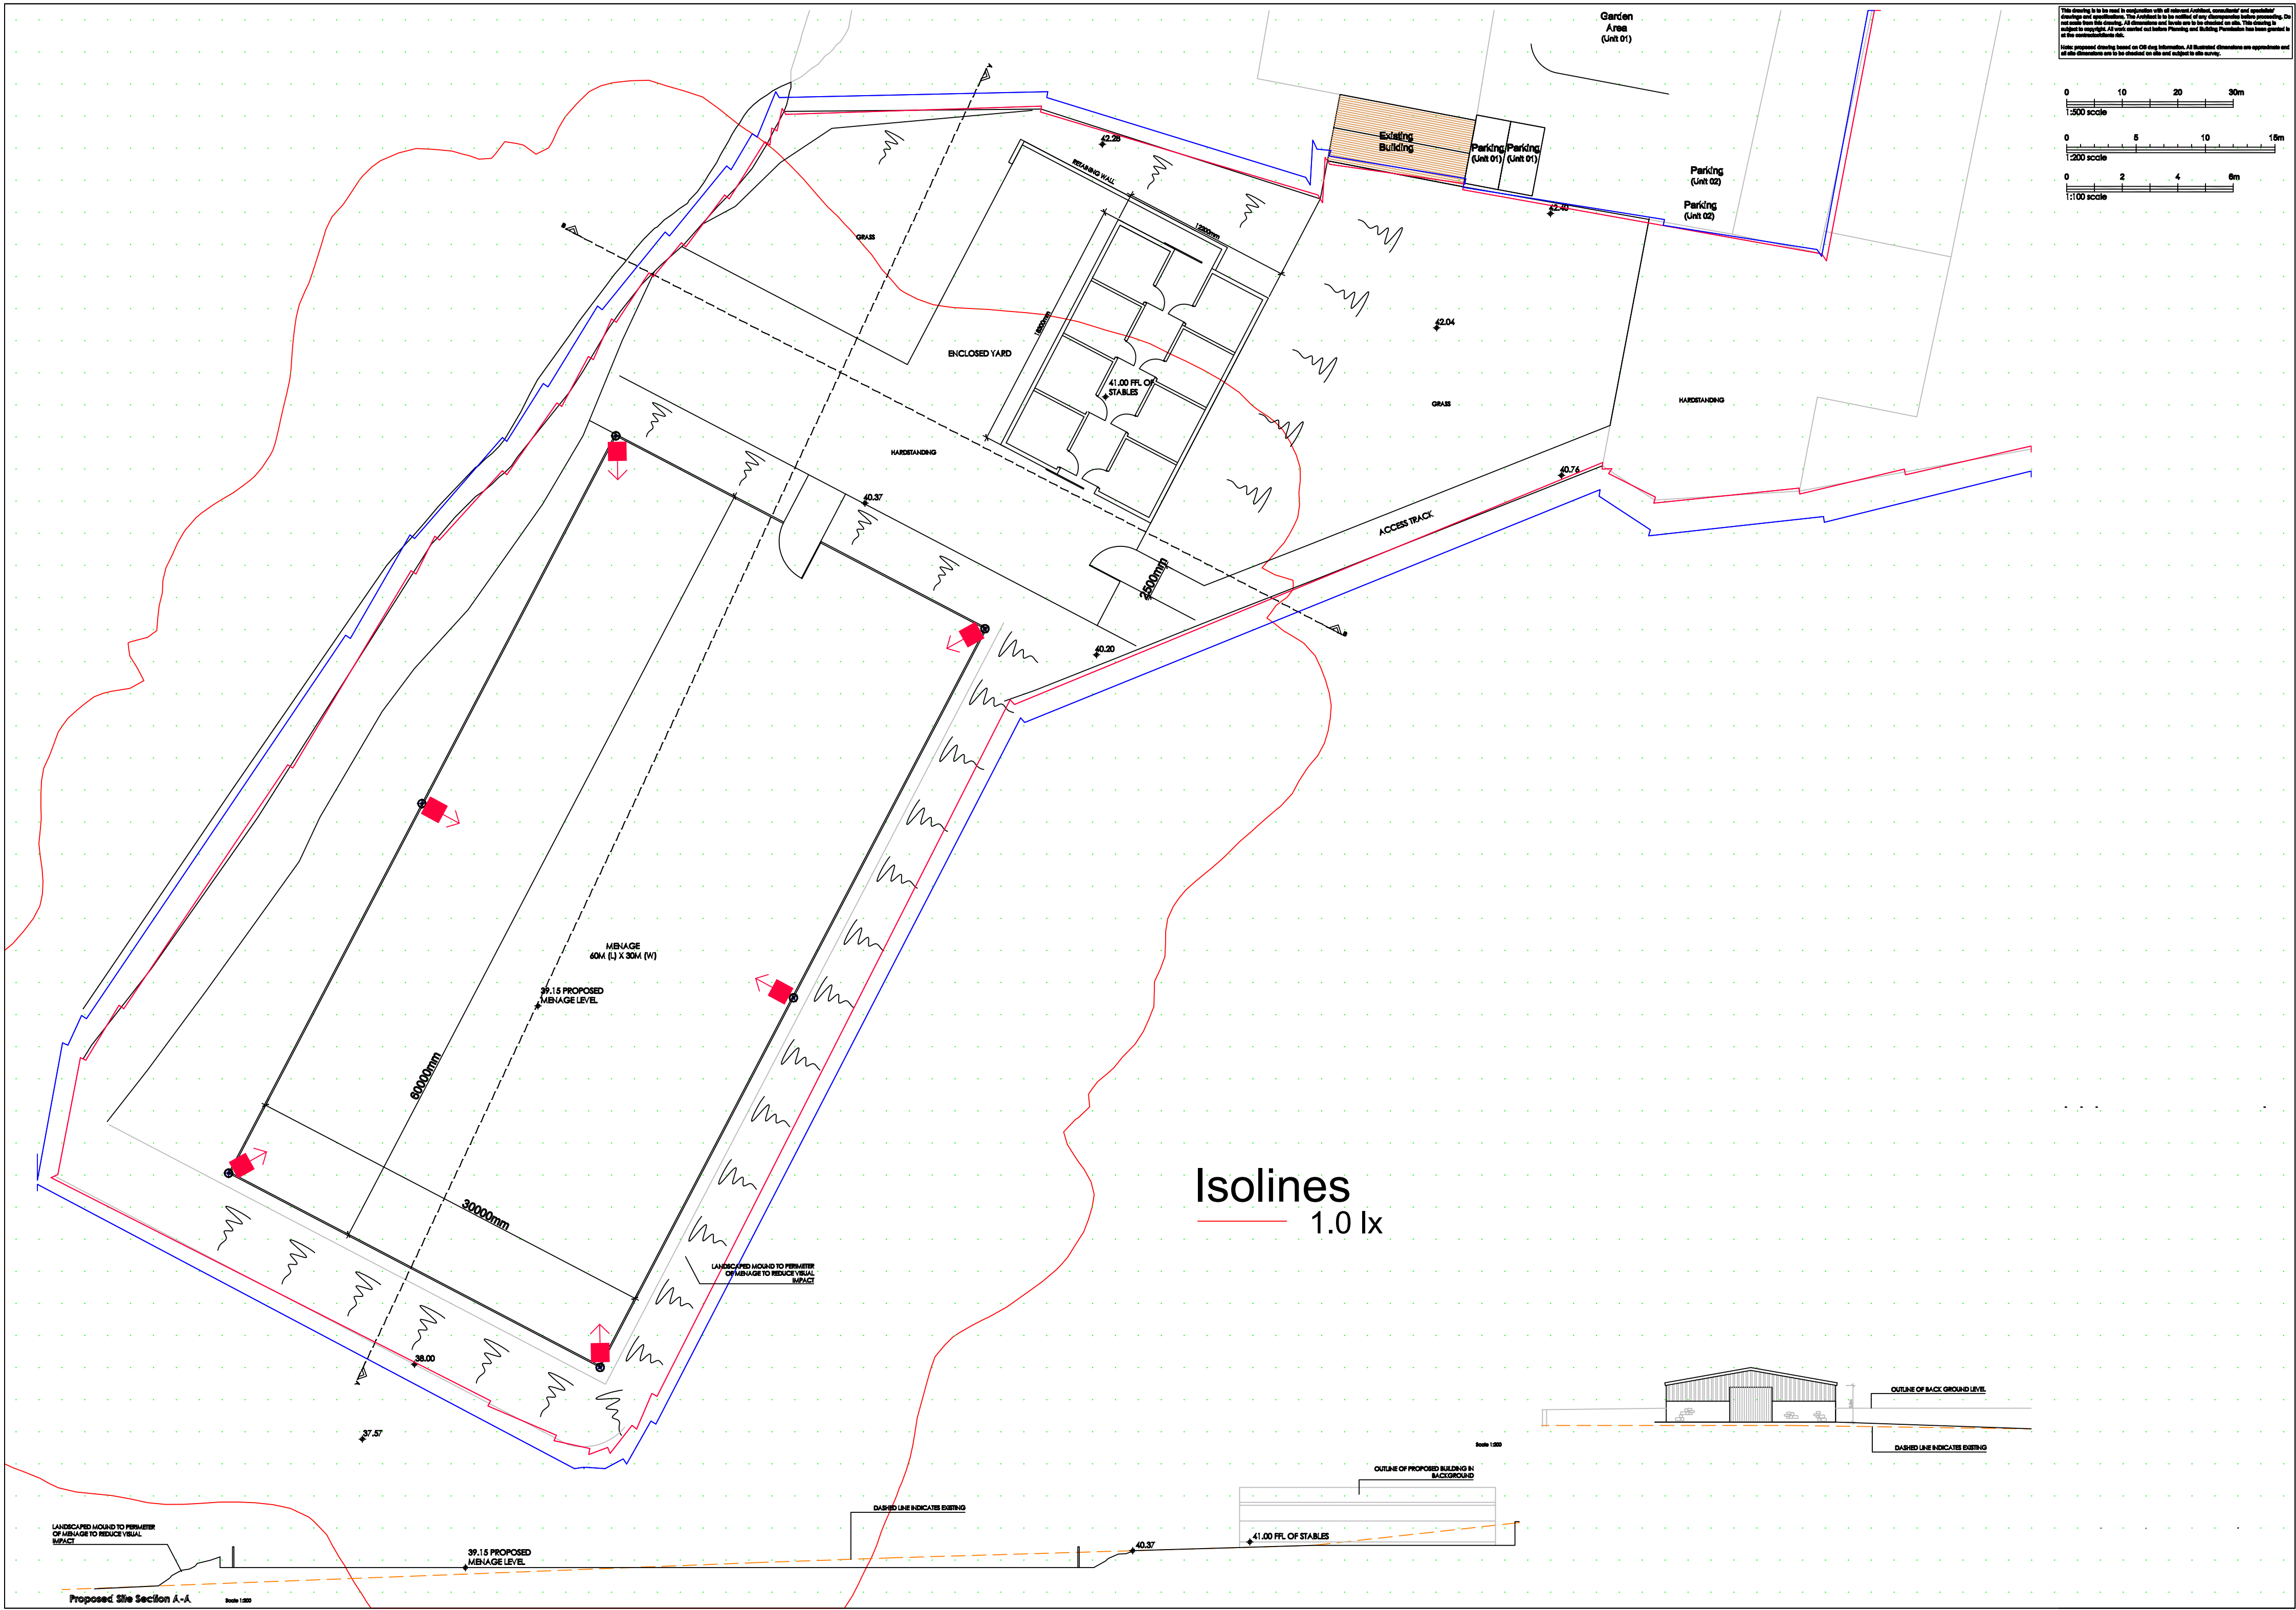

LUMINAIRE SCHEDULE

| Symbol                                                                              | Qty | Code                  | Description                                                                                                                                                                                                                                                        |
|-------------------------------------------------------------------------------------|-----|-----------------------|--------------------------------------------------------------------------------------------------------------------------------------------------------------------------------------------------------------------------------------------------------------------|
|  | 6   | AR4B-310-740-4S-D1-GR | Arrol 4B Series: Premium LED Streetlight -310W - Nichia 3535 LED Chip - CRI>70 4000K - L85>60,000 Hrs - IESNA Type IV Optic with Short Lateral Throw - Philips Non-Dimming Driver - Grey (RAL:7004) Polyester Powder-Coated Surface Finish - 10kV Surge Protection |



AR4B-310-740-4S-D1-GR

PRELIMINARY  
FOR COMMENTS

|           |                                     |
|-----------|-------------------------------------|
| Drawn By: | Checked By:                         |
| MTKB      | INITIALS                            |
| 000       | REASON                              |
| INITIALS  | DATE                                |
| REV       | DESCRIPTION                         |
| CHK       | DATE                                |
| Project:  | Sunderland Peacock & Associates Ltd |
|           | Higher Boyce Farm                   |
|           | EXTERNAL Lighting                   |
|           | Horse Menage Arena                  |

Services:

Lighting Plan



A division of the Kellwood Engineering Group - Est. 1985  
Unit 7 Catherinefield Ind Est, Dumfries, Scotland DG1 3PQ  
T: 01387 255816 W: [www.kellwood.co.uk](http://www.kellwood.co.uk)

|                                  |                |
|----------------------------------|----------------|
| Scale: DO NOT SCALE              | Date: 18/07/19 |
| Drawing No. PL0003838-SUND01-001 | Revision. 0    |