




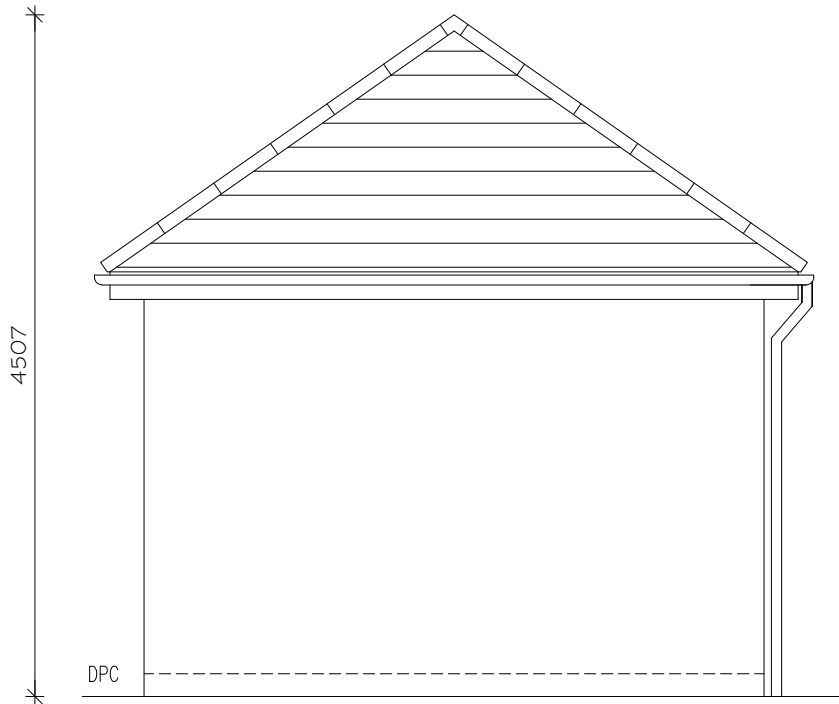


REAR

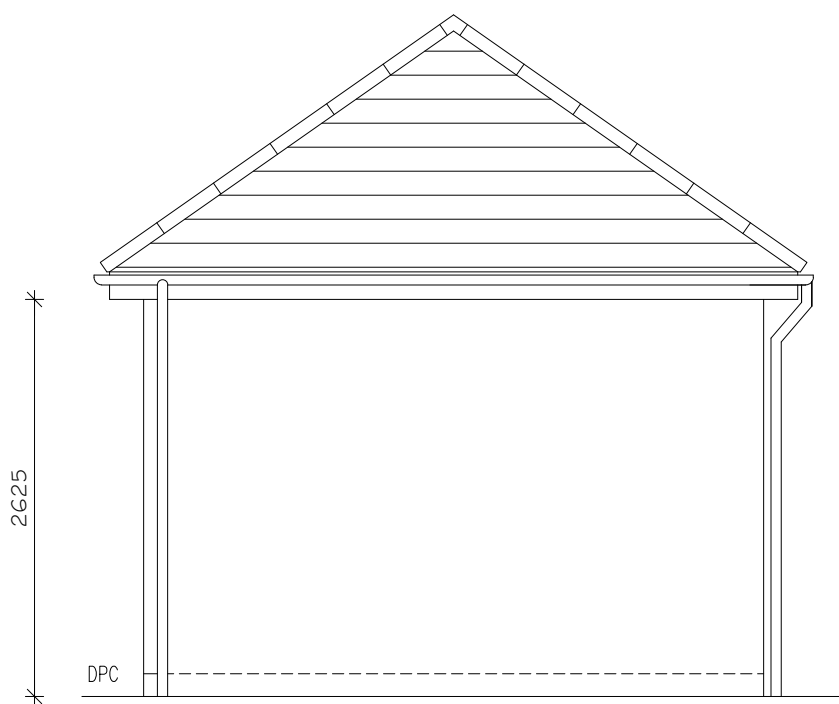

SIDE

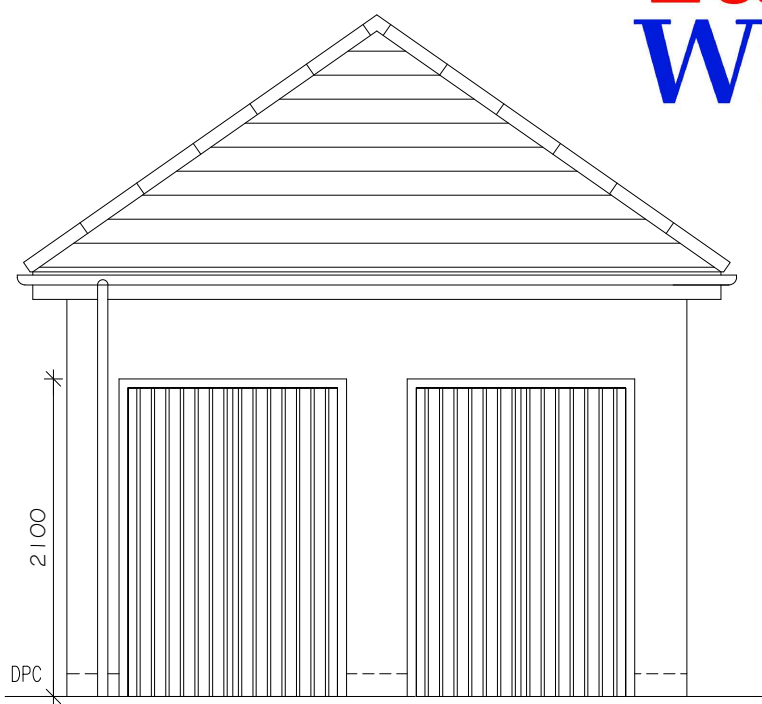

FRONT

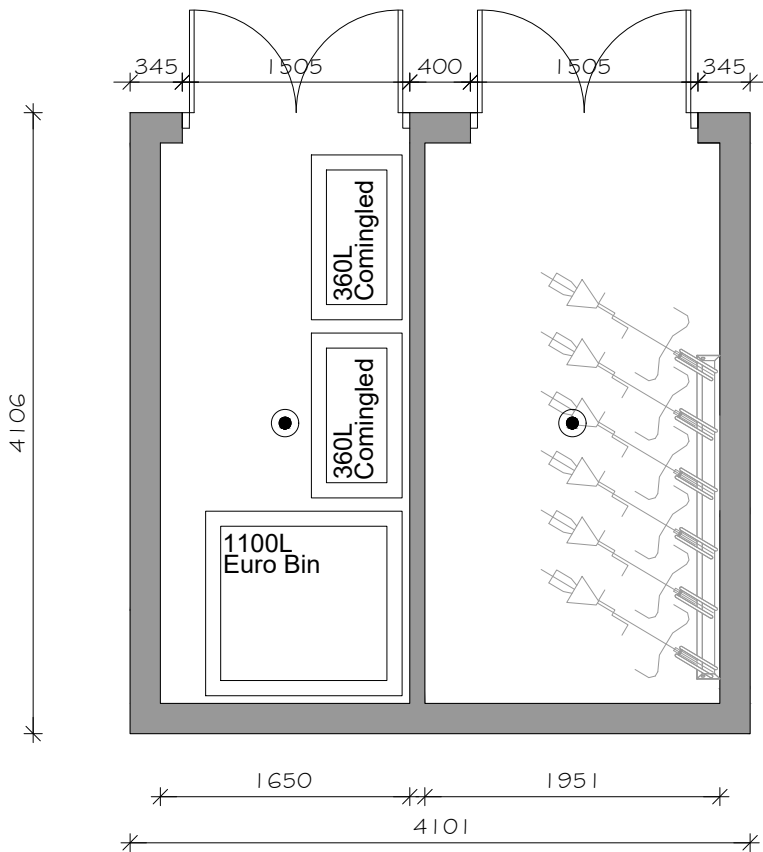

ELECTRICAL LEGEND

● CEILING MOUNTED PIR MOTION SENSOR LIGHT FITTING

4 Marina Walk, Pennington Wharf, Plank Lane, Leigh, WN7 4EZ Tel: 01925 747615 e-mail: g.baldwin@baldwindesign.net www.baldwindesign.net	Revision:
	Project Title: Residential Redevelopment
	Address: Higher Standen Farm Clitheroe.
	Drawing: Proposed Bin & Cycle Store
	Drawing No: TW/HSF/HT/65
Drawn: WB	Date: Date: 19/09/19
Scale: 1:50	Paper Size: A3