


LOCATION KEY

LEGEND DETAILS




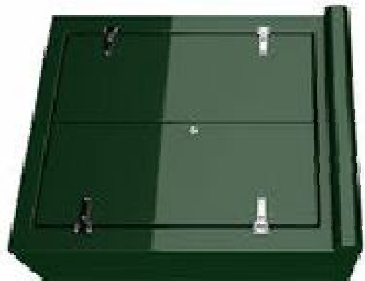


IMAGE

FRONT ELEVATION  
(N.T.S)

SIDE ELEVATION  
(N.T.S)

PLANNING DESCRIPTION  
FOUL DRAINAGE - BELOW GROUND PACKAGE SYSTEM WITH CONTROL PANEL ENCLOSURE  
FINISH: GRP BRITISH RACING GREEN.

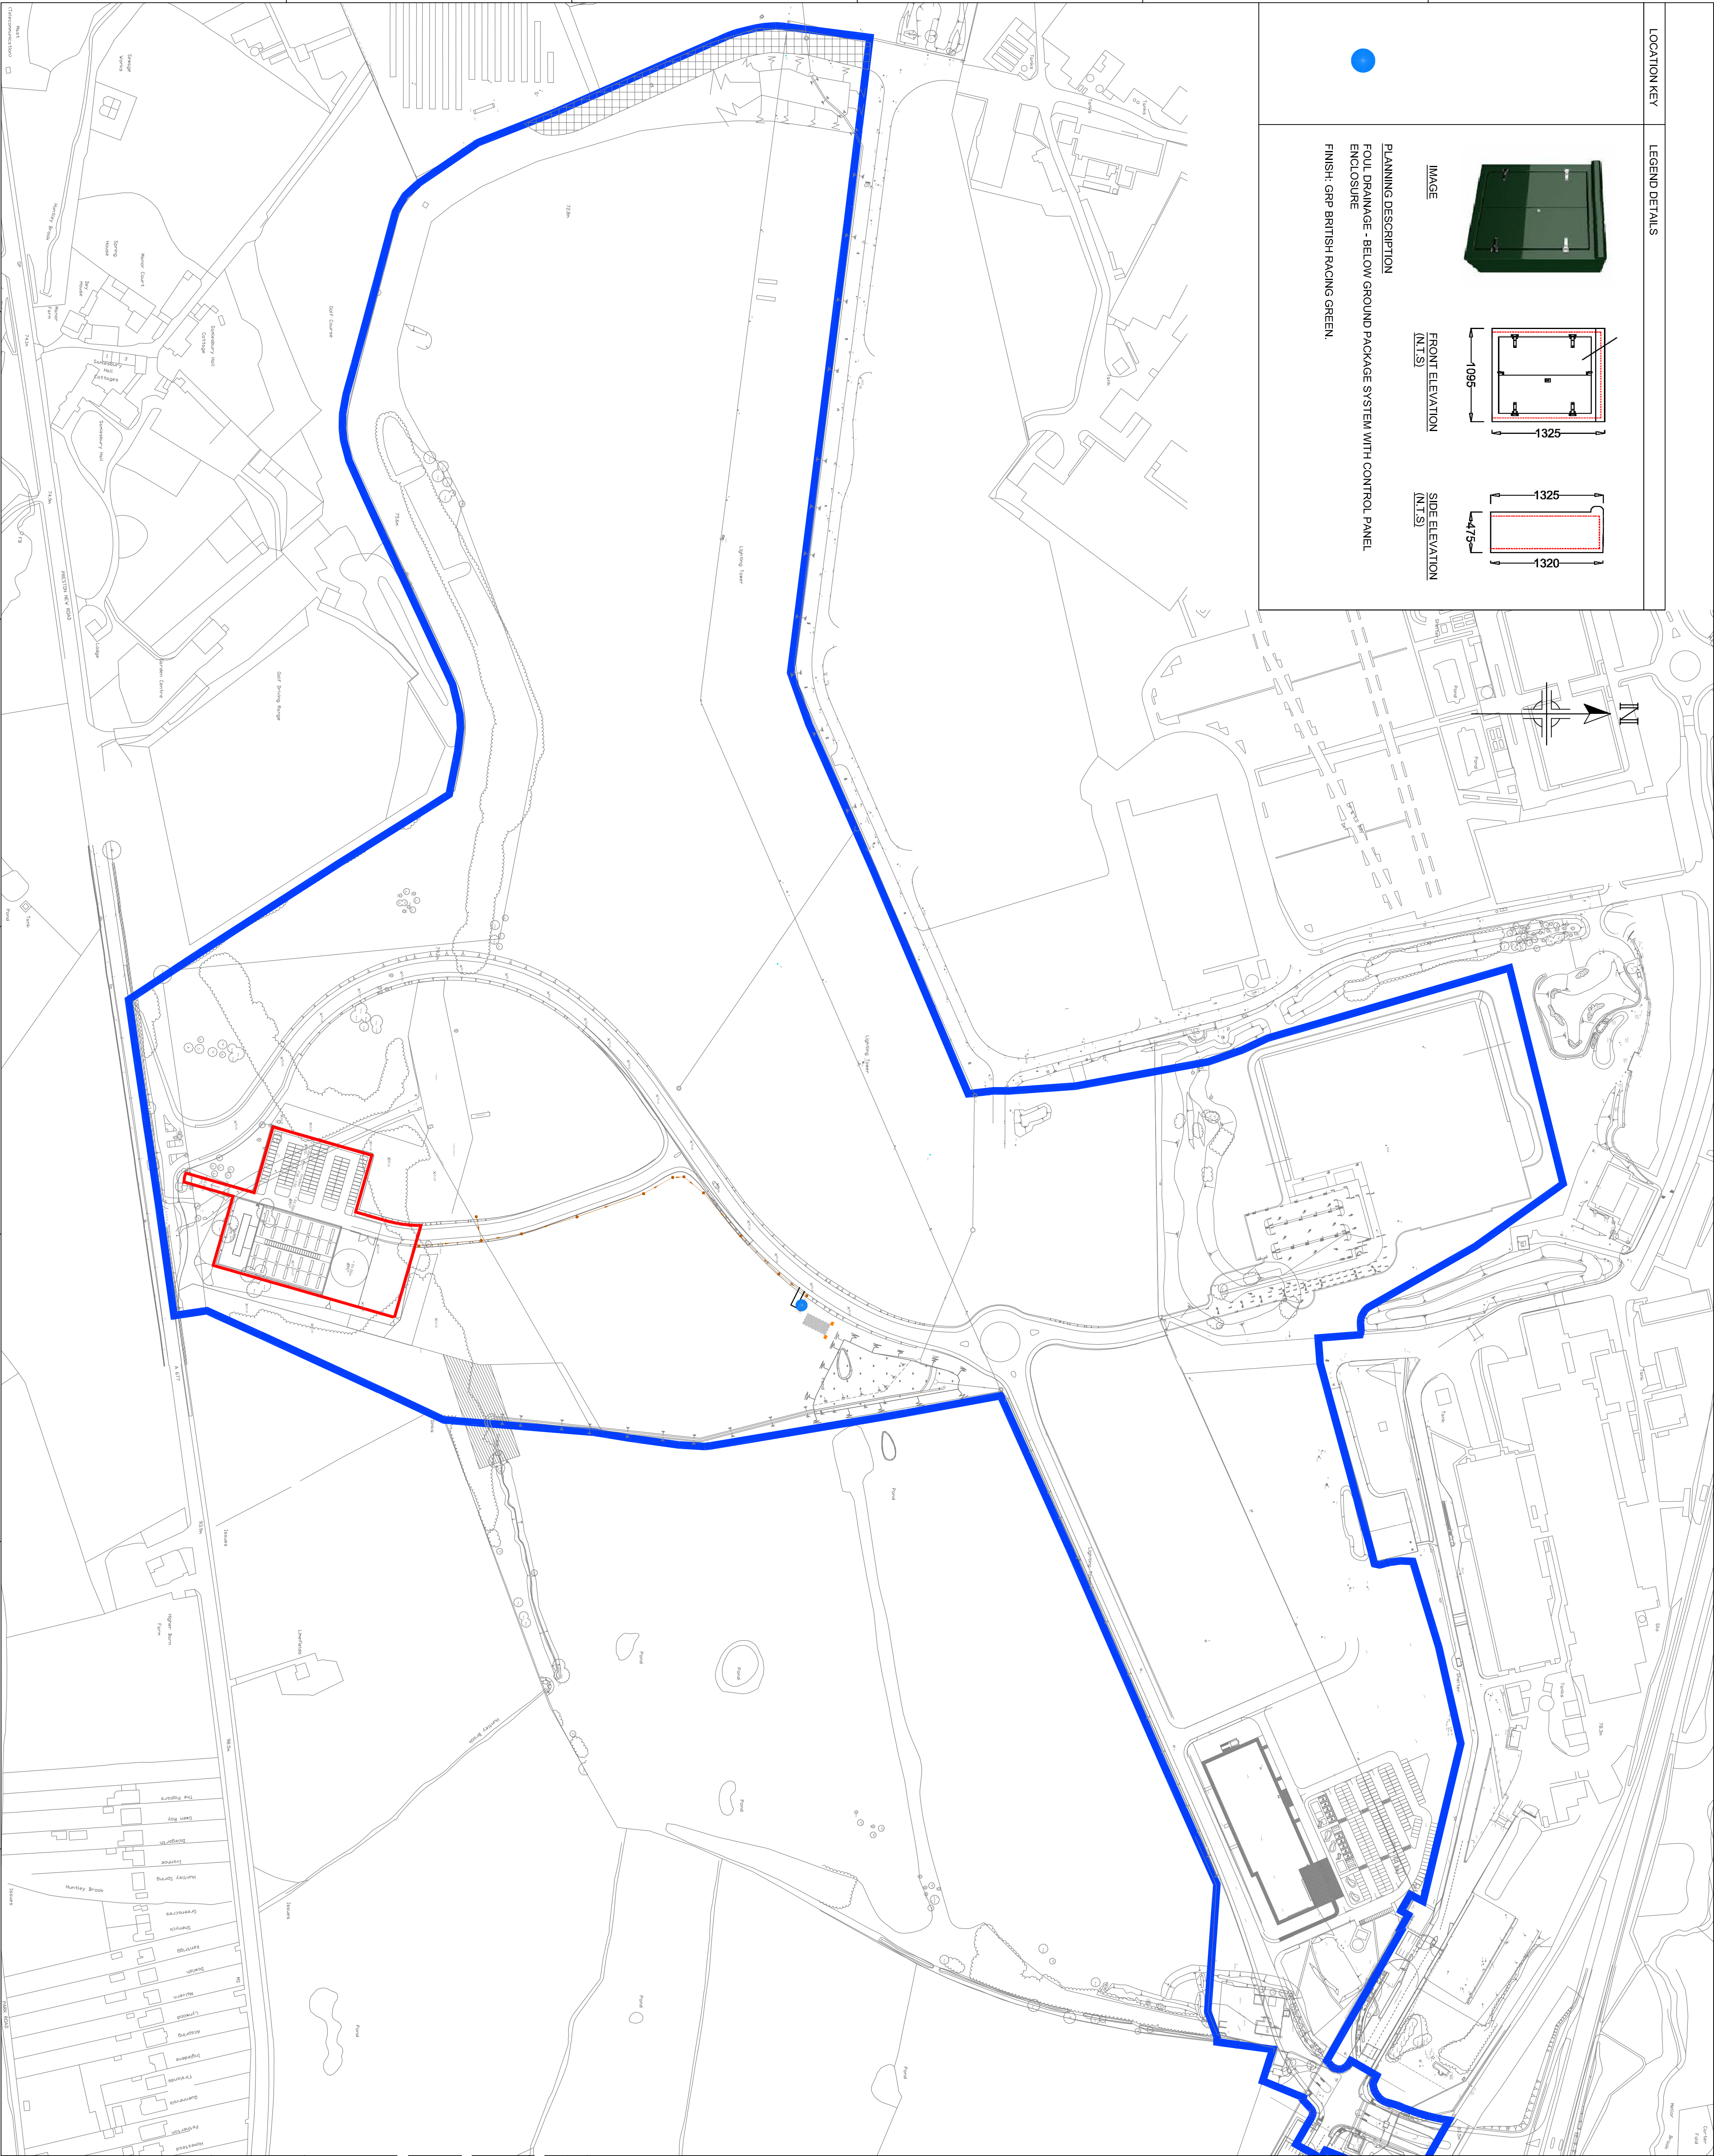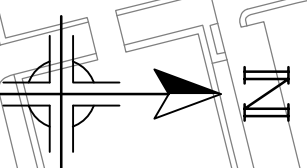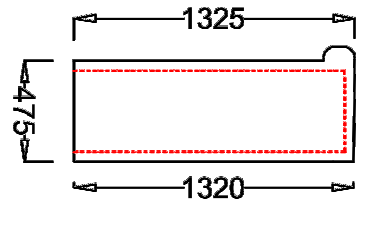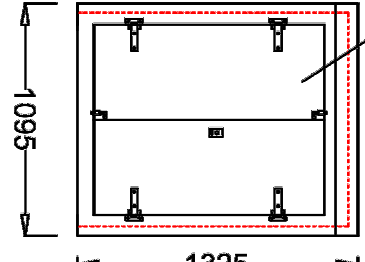

1023121

A1

|              |     |
|--------------|-----|
| Based On:    | Rev |
| Drawn By:    | Rev |
| Checked By:  | Rev |
| Surveyed By: | Rev |
| Other By:    | Rev |

THIS DRAWING MAY INDICATE ELEMENTS RELATED TO FIRE SYSTEMS. THESE ARE INDICATIVE ONLY AND FINAL NUMBER, POSITIONING AND PERFORMANCE MUST BE ESTABLISHED AS PART OF THE CDP WORKS TO MAINTAIN THE INTENT OF THE DESIGN FIRE STRATEGY

NOTES:

LEGEND

- PROPOSED FOUL WATER PIPE AND MANHOLE
- APPROXIMATE ENTERPRISE ZONE BOUNDARY
- AMRC SITE AREA

|       |          |             |    |      |       |
|-------|----------|-------------|----|------|-------|
| P1    | 05.11.19 | FIRST ISSUE | AW | JH   | MH    |
| Issue | Date     | Description | By | Chkd | Verfd |

Project  
SAMLESBURY ENTERPRISE ZONE

Client  
LANCASHIRE COUNTY COUNCIL

Title  
AMRC FOUL DRAINAGE  
BELOW GROUND DRAINAGE  
PACKAGE SYSTEM LOCATIONS

Drawing Status  
ISSUED FOR PLANNING

Project No. 1023121 Scale 1:2000

**CUNDALL**

2nd Floor, 11 George Enescu Street,  
Bedsford, Bedfordshire  
MK43 0JN  
Tel: +40 21 230 6068  
Website: www.cundall.com

SEZ-CDL-XX-00-DR-M-9002