
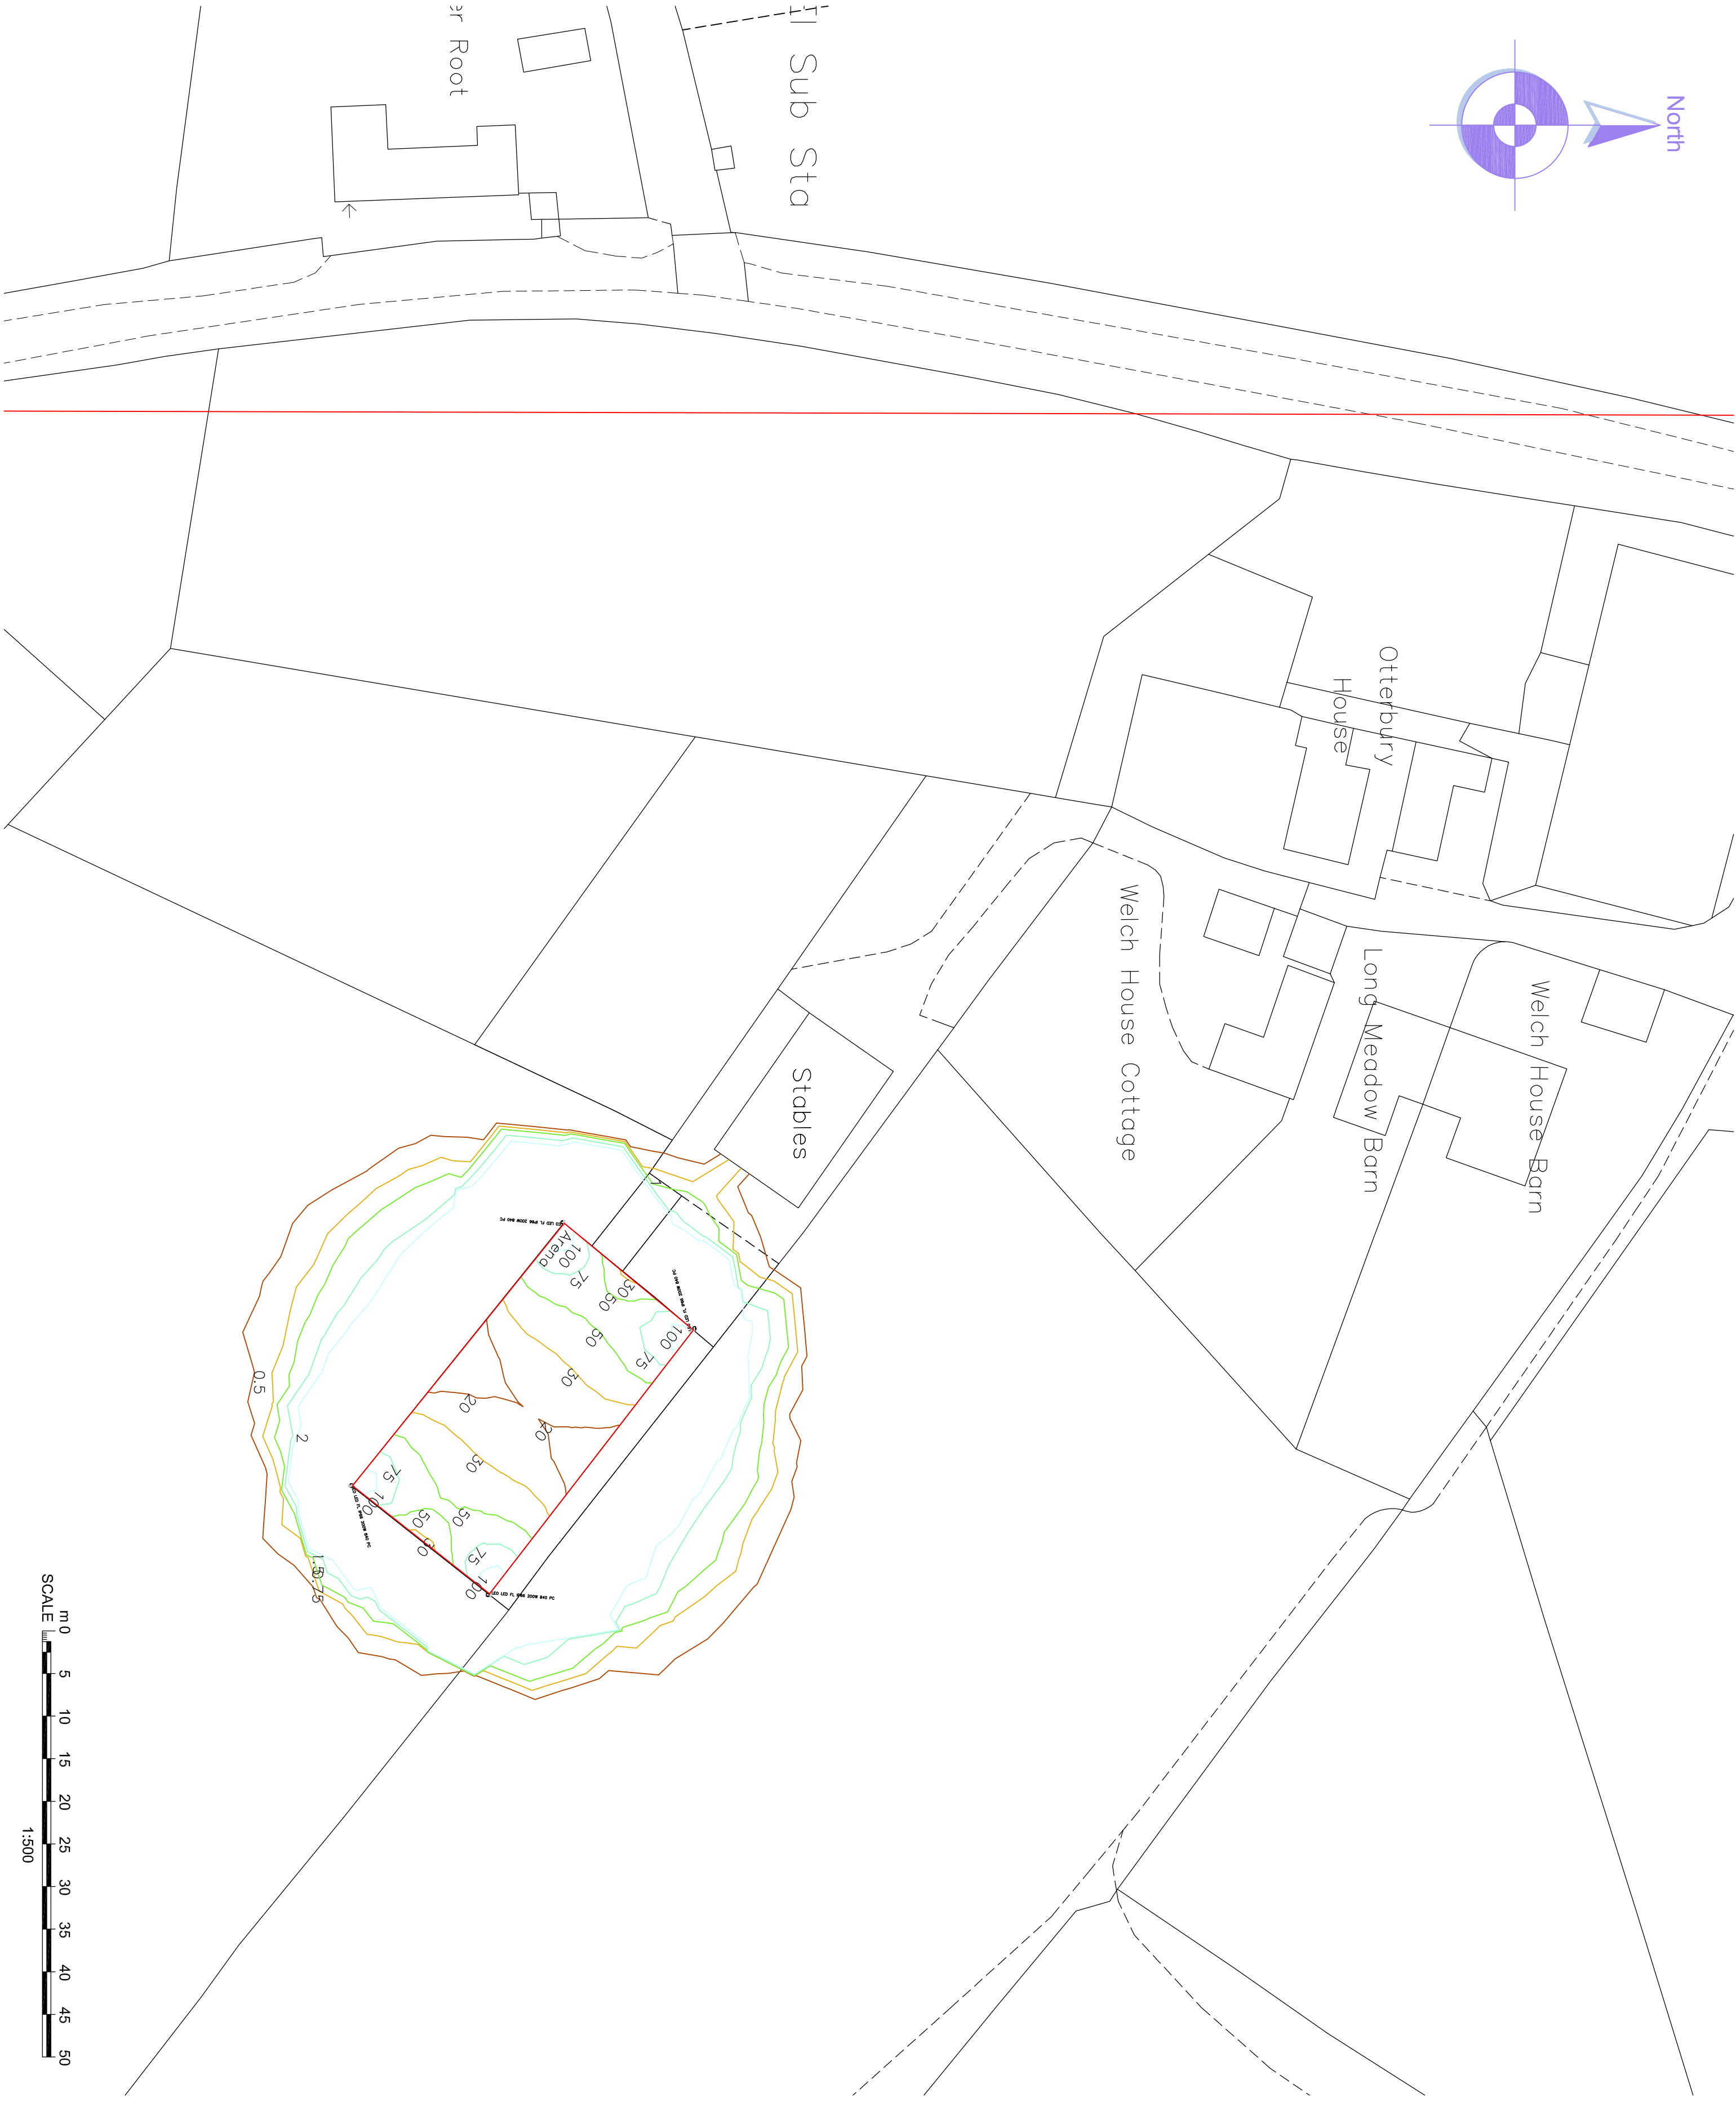


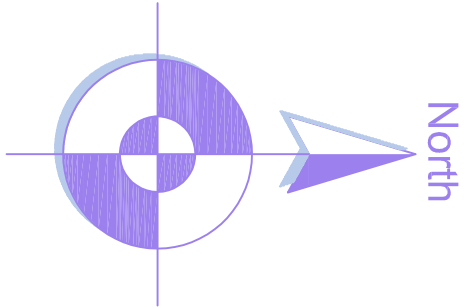

IMPORTANT

- © This drawing is copyright and remains the property of this practice
- Do not scale this drawing
- All dimensions to be checked on site
- Positions of existing services to be confirmed prior to proceeding

REVISION STATUS

- S Information issued for feasibility or scheme design.
- T Information issued for tender purposes only.
- C Information issued for Construction.

NB: Only those drawings containing a C revision to be used for construction.

NOTES

REVISION	DATE	DESCRIPTION

CLIENT
Lynne Kenyon
Welch House Cottage

PROJECT

Retrospective Application for Menage & Lighting

DRAWING TITLE
Proposed Lighting Plan

SCALE	DATE	DRAWN	CHECKED
1:500@A2	Dec '19	PRH	PRH

DRG NO.
EAD_076_03

Evolve Architectural Design Ltd
2 St Matthews School House
Stanhill Lane
Oswaldtwistle
Accrington
Lancashire BB5 4PZ
T 01254 469702
M 07967 592102
E paul@evolvead.co.uk
www.evolvead.co.uk

