


1 EXISTING SOUTH EAST
1 : 100

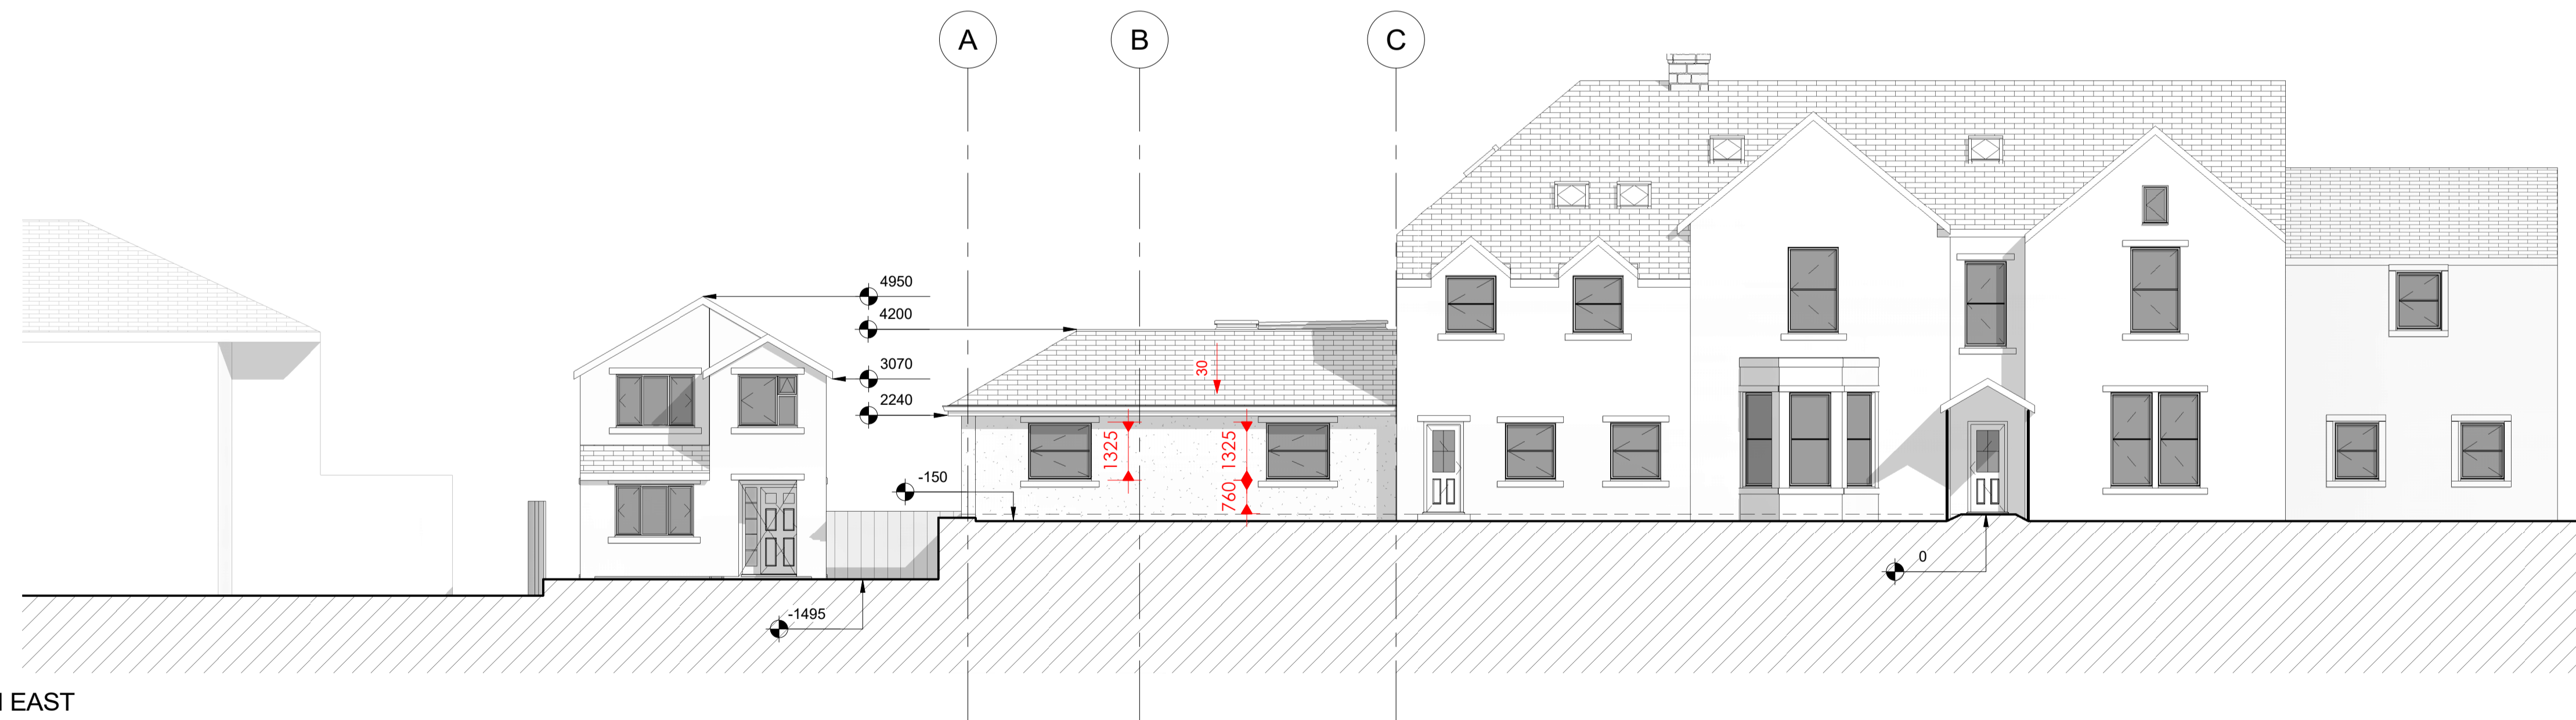

2 PROPOSED SOUTH EAST
1 : 100

NOTES:

- Summary of notes:
Proposed extension to High Brake House & replacement dwelling to 127 Chatburn Rd, Clitheroe.
1. An initial drainage survey has been carried out by a drainage engineer. All matters relating to the suitability of the existing and the final drainage layout will be subject to a thorough investigation on the works programme. Work is to be carried out to improve the drainage as far as is possible.
 2. The contractor shall take the approval of the local authority for the proposed drainage layout.
 3. The contractor shall ensure that the drainage system is installed in accordance with the manufacturer's instructions and specifications.
 4. The contractor shall ensure that the drainage system is installed in accordance with the manufacturer's instructions and specifications.
 5. The contractor shall ensure that the drainage system is installed in accordance with the manufacturer's instructions and specifications.
 6. The contractor shall ensure that the drainage system is installed in accordance with the manufacturer's instructions and specifications.
 7. The contractor shall ensure that the drainage system is installed in accordance with the manufacturer's instructions and specifications.
 8. The contractor shall ensure that the drainage system is installed in accordance with the manufacturer's instructions and specifications.
 9. The contractor shall ensure that the drainage system is installed in accordance with the manufacturer's instructions and specifications.
 10. The contractor shall ensure that the drainage system is installed in accordance with the manufacturer's instructions and specifications.

No.	Description	Date
A	Drainage change	17/08/2020
B	FOUNDATION & REAR ELEVATION CHANGES	02/02/2021
C	FLOOR PLAN, WINDOW & DRAINAGE CHANGES	03/02/2021

CLIENT:
HIGH BRAKE HOUSE, CLITHEROE

PROJECT:
EXTENSION TO HIGH BRAKE HOUSE, CLITHEROE

SHEET:
FRONT ELEVATIONS

Project number	PHA/339
Date	08/02/2021
Drawn by	RH
Checked by	PH

A2.1

Scale	1 : 100
Sheet size	A1