



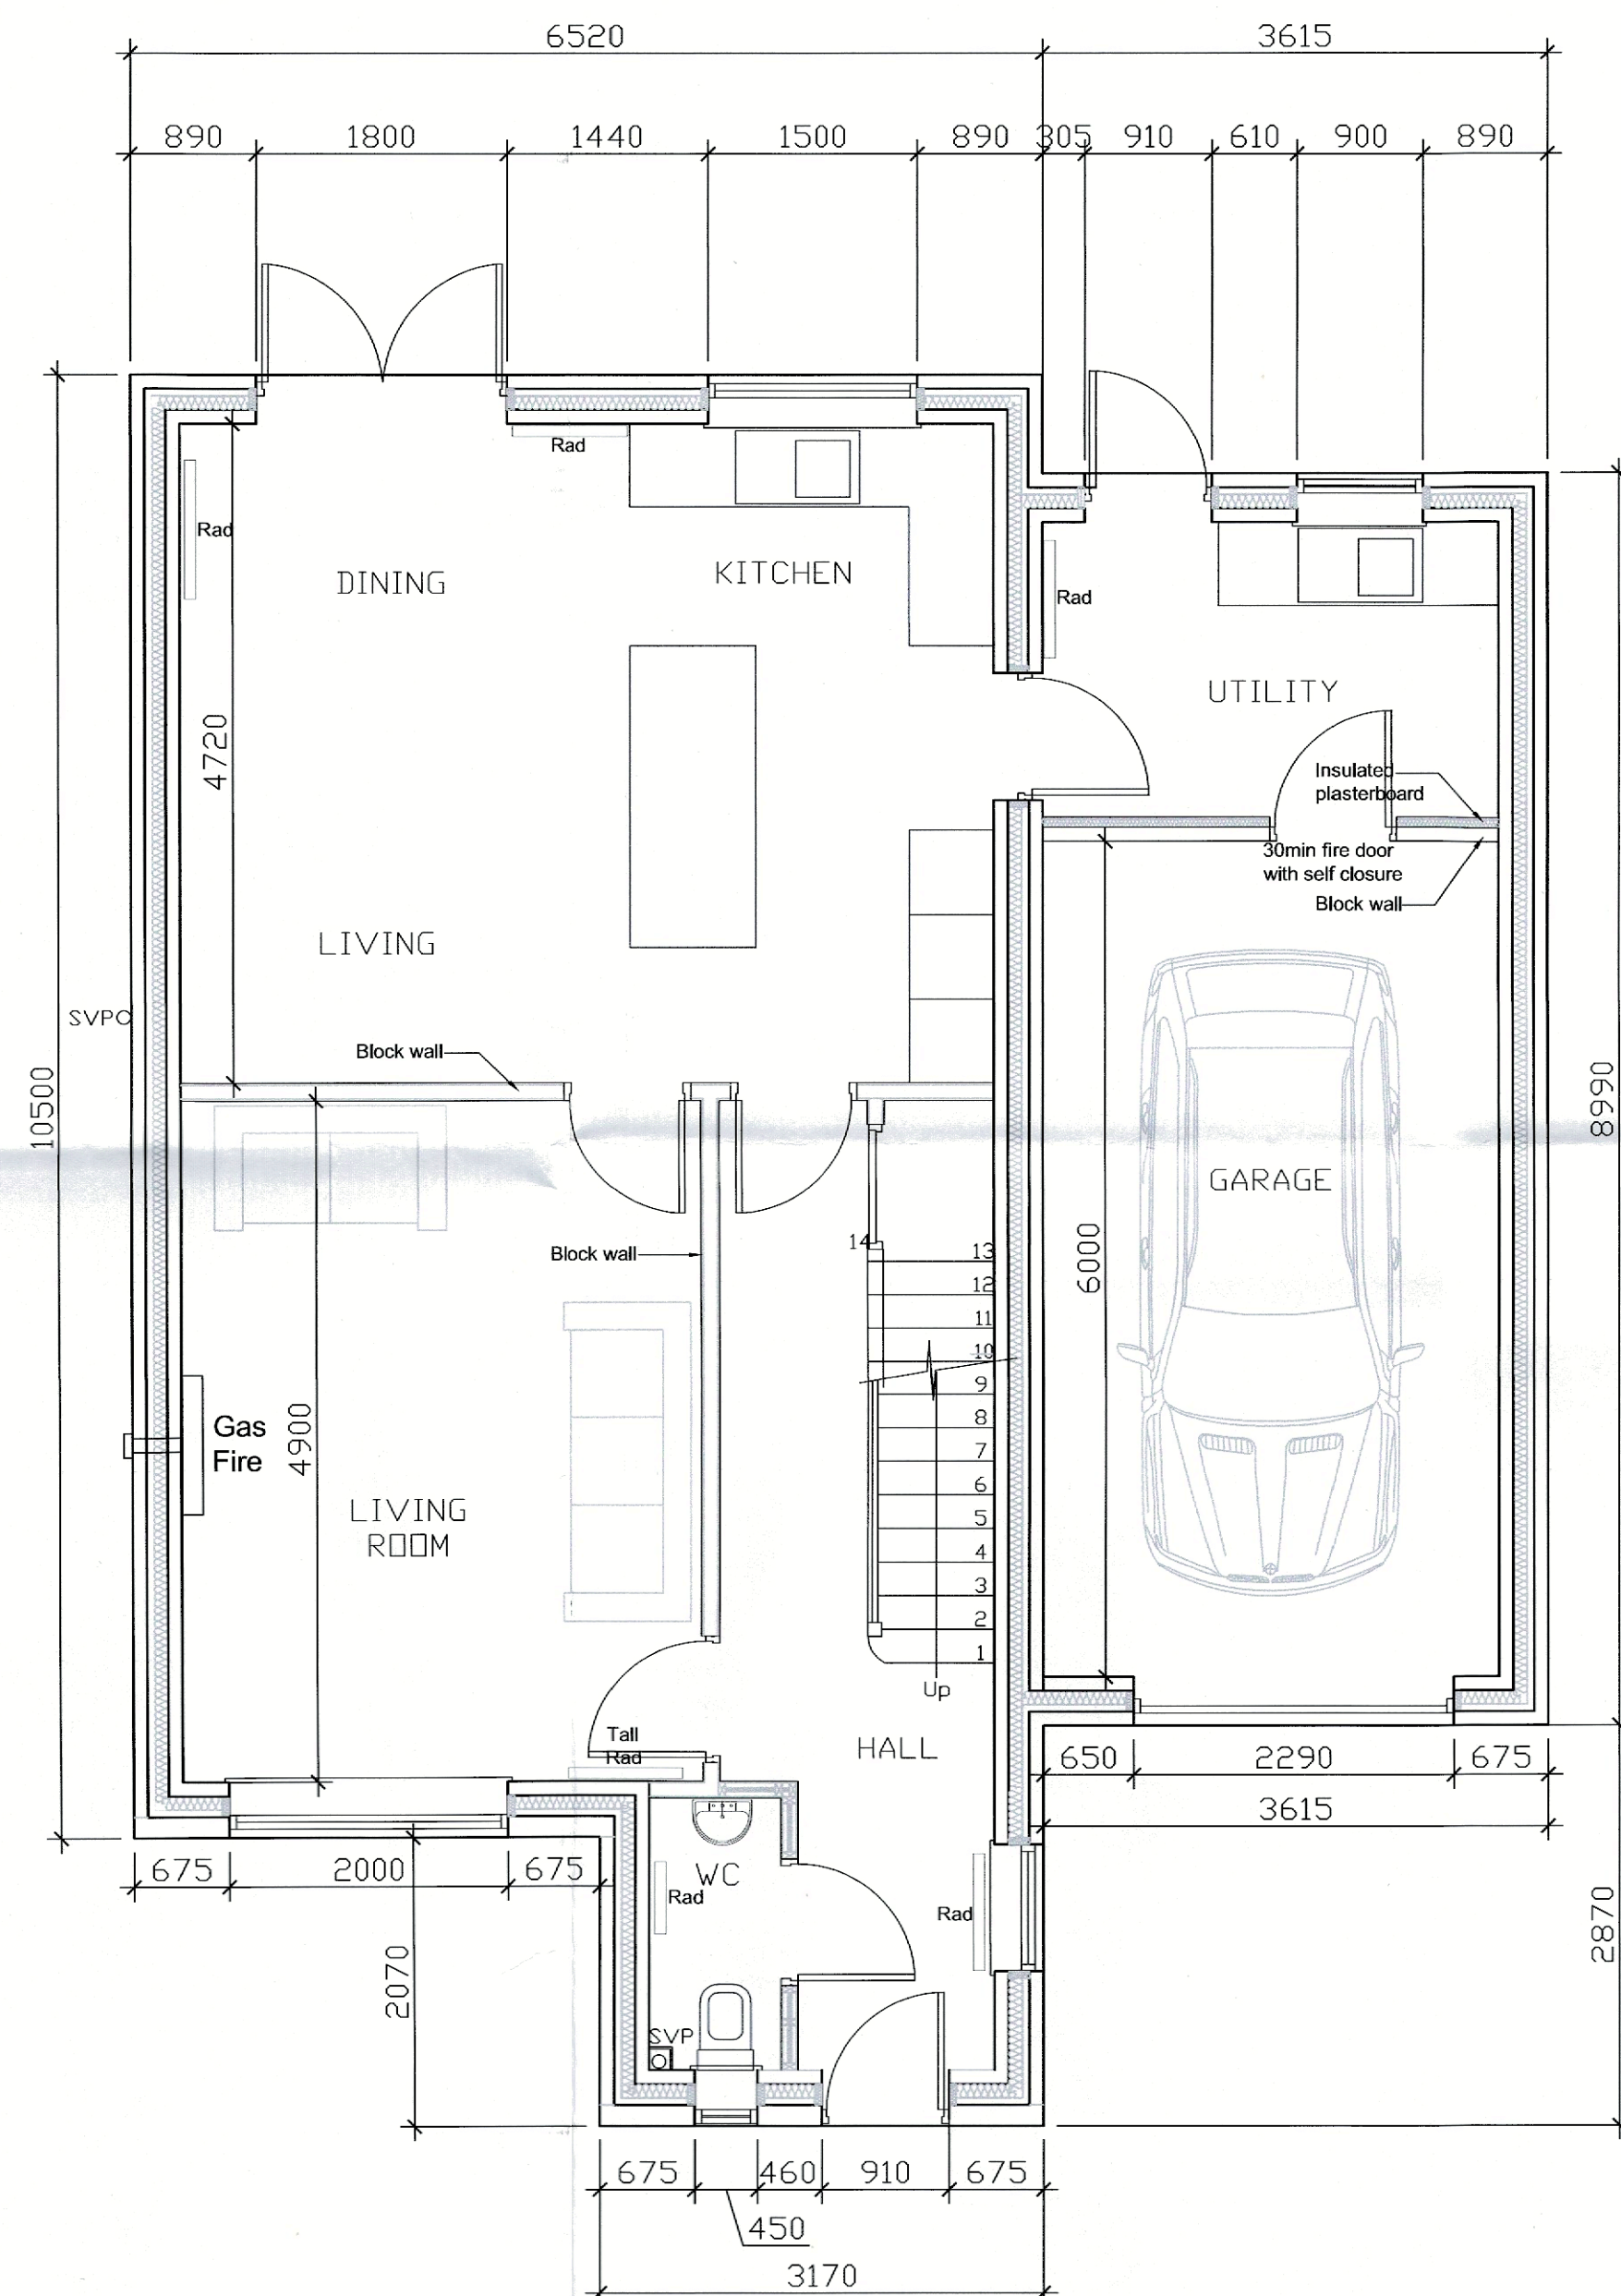

Ground Floor Plan
1:50 Scale

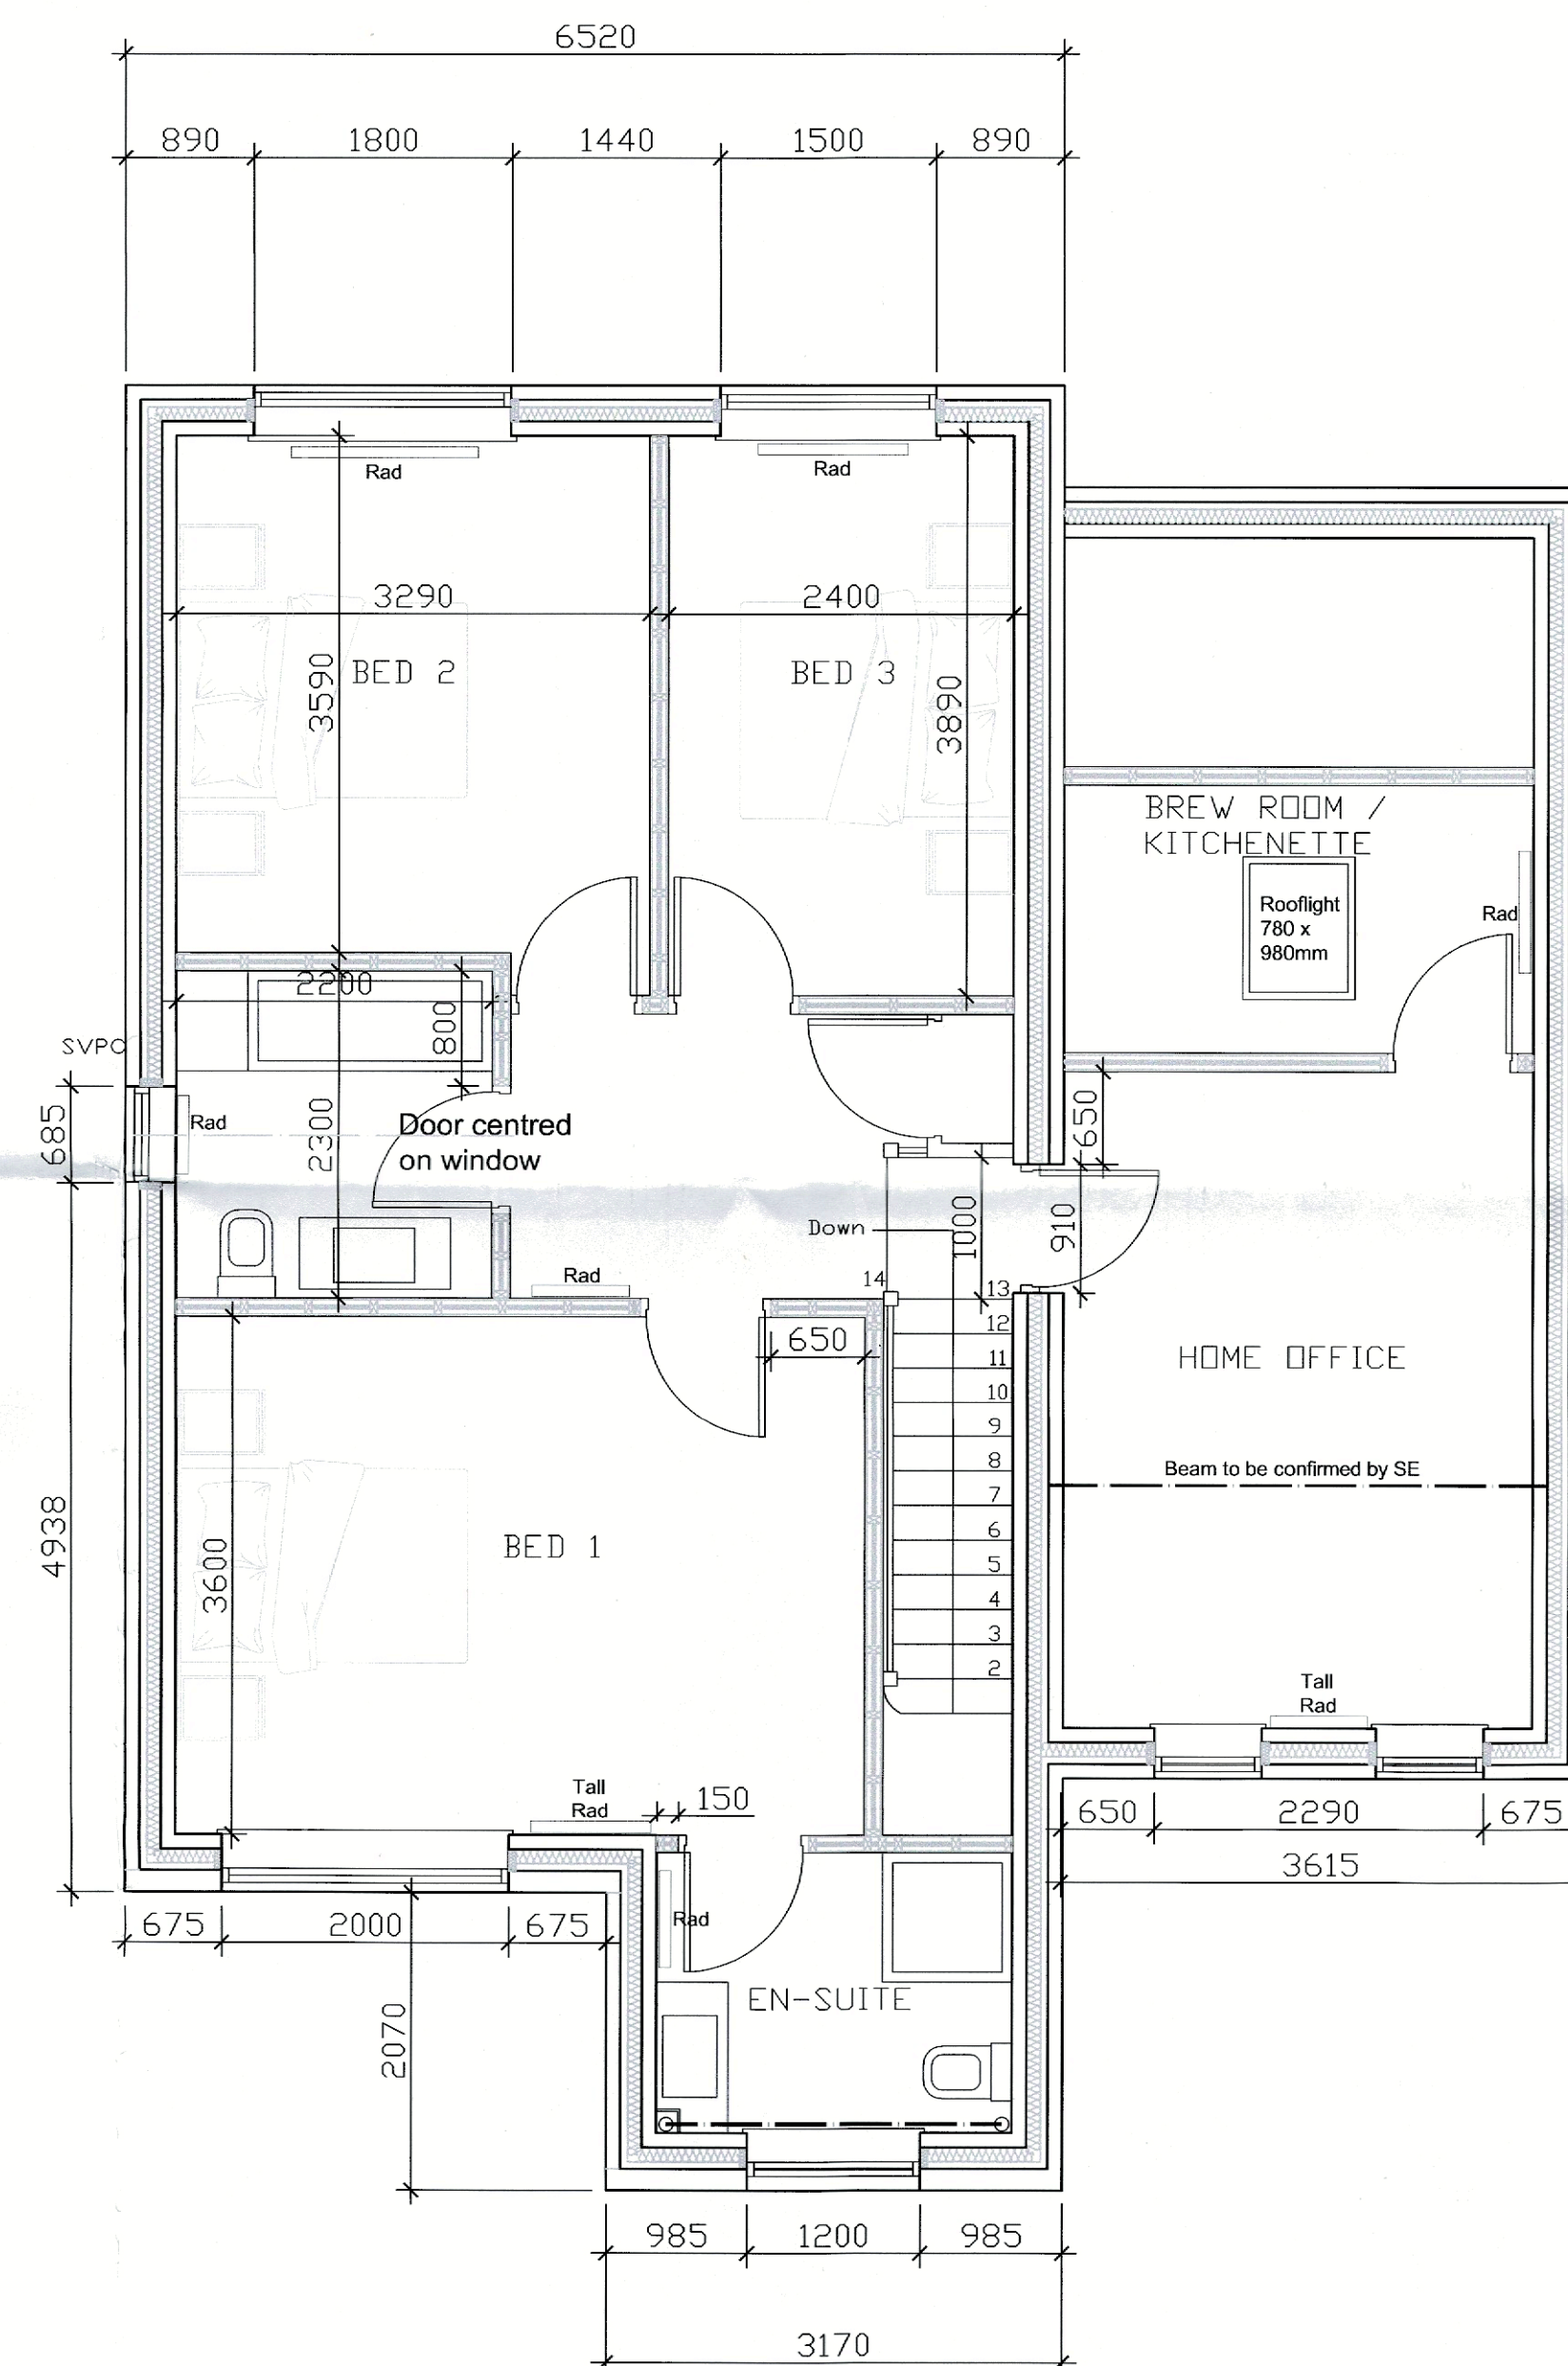

First Floor Plan
1:50 Scale

Rev F: First floor extension proposed over garage - Variation of condition application. 14.05.2021
Rev E: First floor extension omit from over garage. 13.05.2021
Rev C: Client alterations as per marked up sketches. 18.03.2021
Rev B: Electrical layout added for pricing. 25.02.2020

Client
MFH Projects (Harrison)

Job Title
Proposed Dwellings
Land at Victoria Terrace
Mellor Brook

Drawing Title
Proposed Floor Plans
Unit 3

Scale
Various @ A1

Date
Dec 2019

Drawn
Craig Harrison

spa
SUNDERLAND PEACOCK ARCHITECTS
SUNDERLAND PEACOCK & ASSOCIATES LTD.
HAZELHIRE, PIMICO ROAD, CLITHEROE
LANCASHIRE, B97 2AG
01200 423178 01200 427328
info@sunderlandpeacock.com
www.sunderlandpeacock.com

5766 - T05F