


DO NOT SCALE

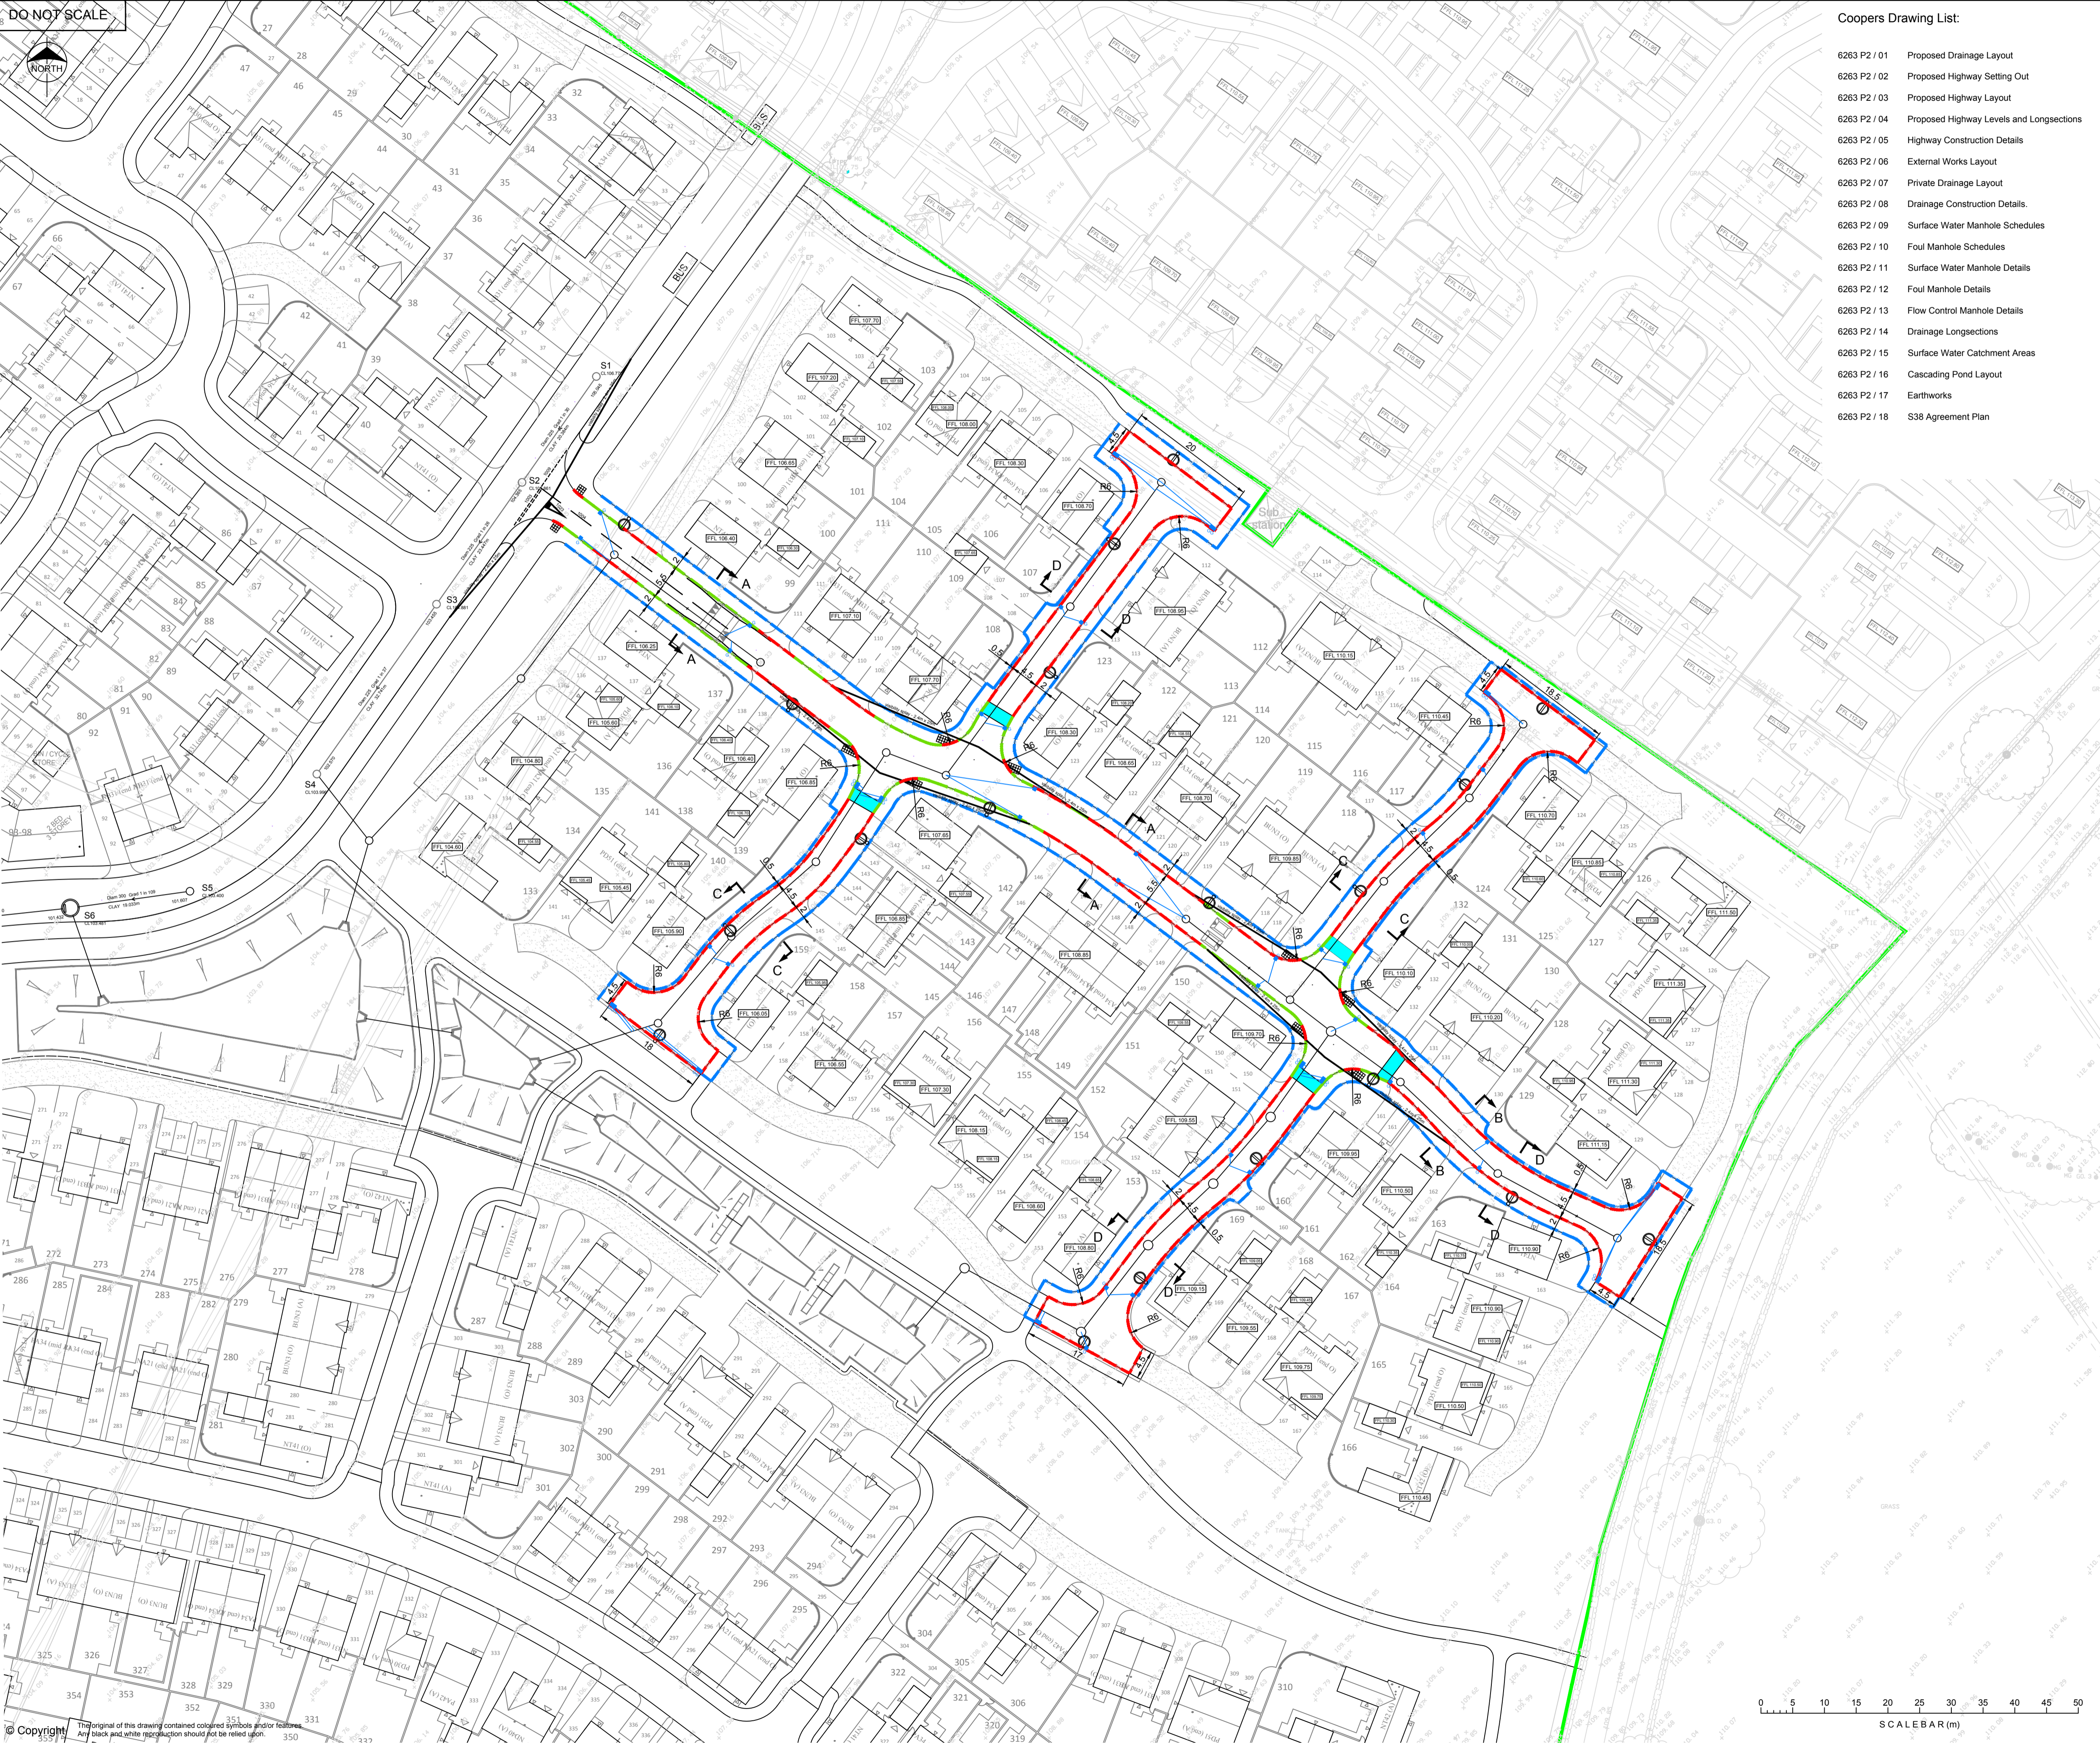

Coopers Drawing List:

- 6263 P2 / 01 Proposed Drainage Layout
- 6263 P2 / 02 Proposed Highway Setting Out
- 6263 P2 / 03 Proposed Highway Layout
- 6263 P2 / 04 Proposed Highway Levels and Longsections
- 6263 P2 / 05 Highway Construction Details
- 6263 P2 / 06 External Works Layout
- 6263 P2 / 07 Private Drainage Layout
- 6263 P2 / 08 Drainage Construction Details
- 6263 P2 / 09 Surface Water Manhole Schedules
- 6263 P2 / 10 Foul Manhole Schedules
- 6263 P2 / 11 Surface Water Manhole Details
- 6263 P2 / 12 Foul Manhole Details
- 6263 P2 / 13 Flow Control Manhole Details
- 6263 P2 / 14 Drainage Longsections
- 6263 P2 / 15 Surface Water Catchment Areas
- 6263 P2 / 16 Cascading Pond Layout
- 6263 P2 / 17 Earthworks
- 6263 P2 / 18 S38 Agreement Plan

Notes

1. Refer to Drawing No. 6263 P2 / 02 for general highway notes.
2. Refer to Drawing No. 6263 P2 / 05 for typical cross sections.
3. All works to be in accordance with Lancashire County Council's Specification and Standard Details, and as agreed with Lancashire County Council's representative.
4. All sign diagram numbers are in accordance with The Traffic Signs Regulations and General Directions 2016 and The Traffic Signs Manual : Chapter 5 Road Markings.
5. Flat top edgings to be installed at back of all footways unless stated otherwise.
6. For radii of 12m or less, purpose made radi kerbs are to be used.
7. Kerb face for Vehicular Crossing = 25mm
Kerb Face for Pedestrian Crossing - 6mm (maximum)

Legend

- Site Boundary
- Half Battered kerb (HB2) - 100mm UPSTAND
- Flat top edging kerb (EF) - FLUSH
- Bull nose kerb (BN) - 25mm UPSTAND
6mm (maximum) at pedestrian crossing
- 2.0m Ramp (refer to Drg 6263 P2 / 05 for details)
- Street Light Locations
(Refer to Hartron drawing 21140-D-01)
- Street Light Locations
(TBC)
- Surface water sewer
- Highway Gully
- Tactile paving provided at all pedestrian crossings
- Speed Hump - To Lancashire County Council Specification and Standard Details
- Speed Cushions - To Lancashire County Council Specification and Standard Details

APPROVAL

A	02.04.20	Issued for S38 Approval	PJN	AJ
Rev.	Date	Revision	By	Appd.


coopers
 chartered consulting engineers
 Park House
 Sandpiper Court
 Chester Business Park
 Chester
 CH4 9QU
 Tel: 01244 684910
 Fax: 01244 684911
 Email: admin@coopers.co.uk
 Web: http://coopers.co.uk

Client
Taylor Wimpey

Project
 STANDEN HALL
 CLITHEROE

Title
 PHASE 2
 Proposed Highway Layout

DRAWING NUMBER	SCALE at A1	1:500
6263 P2 / 03	DATE	19.11.19
	DRAWN	PJN
	CHECKED	AJ
	REVISION	A

 

© Copyright The original of this drawing contained colored symbols and/or features. Any black and white reproduction should not be relied upon.