


DO NOT SCALE

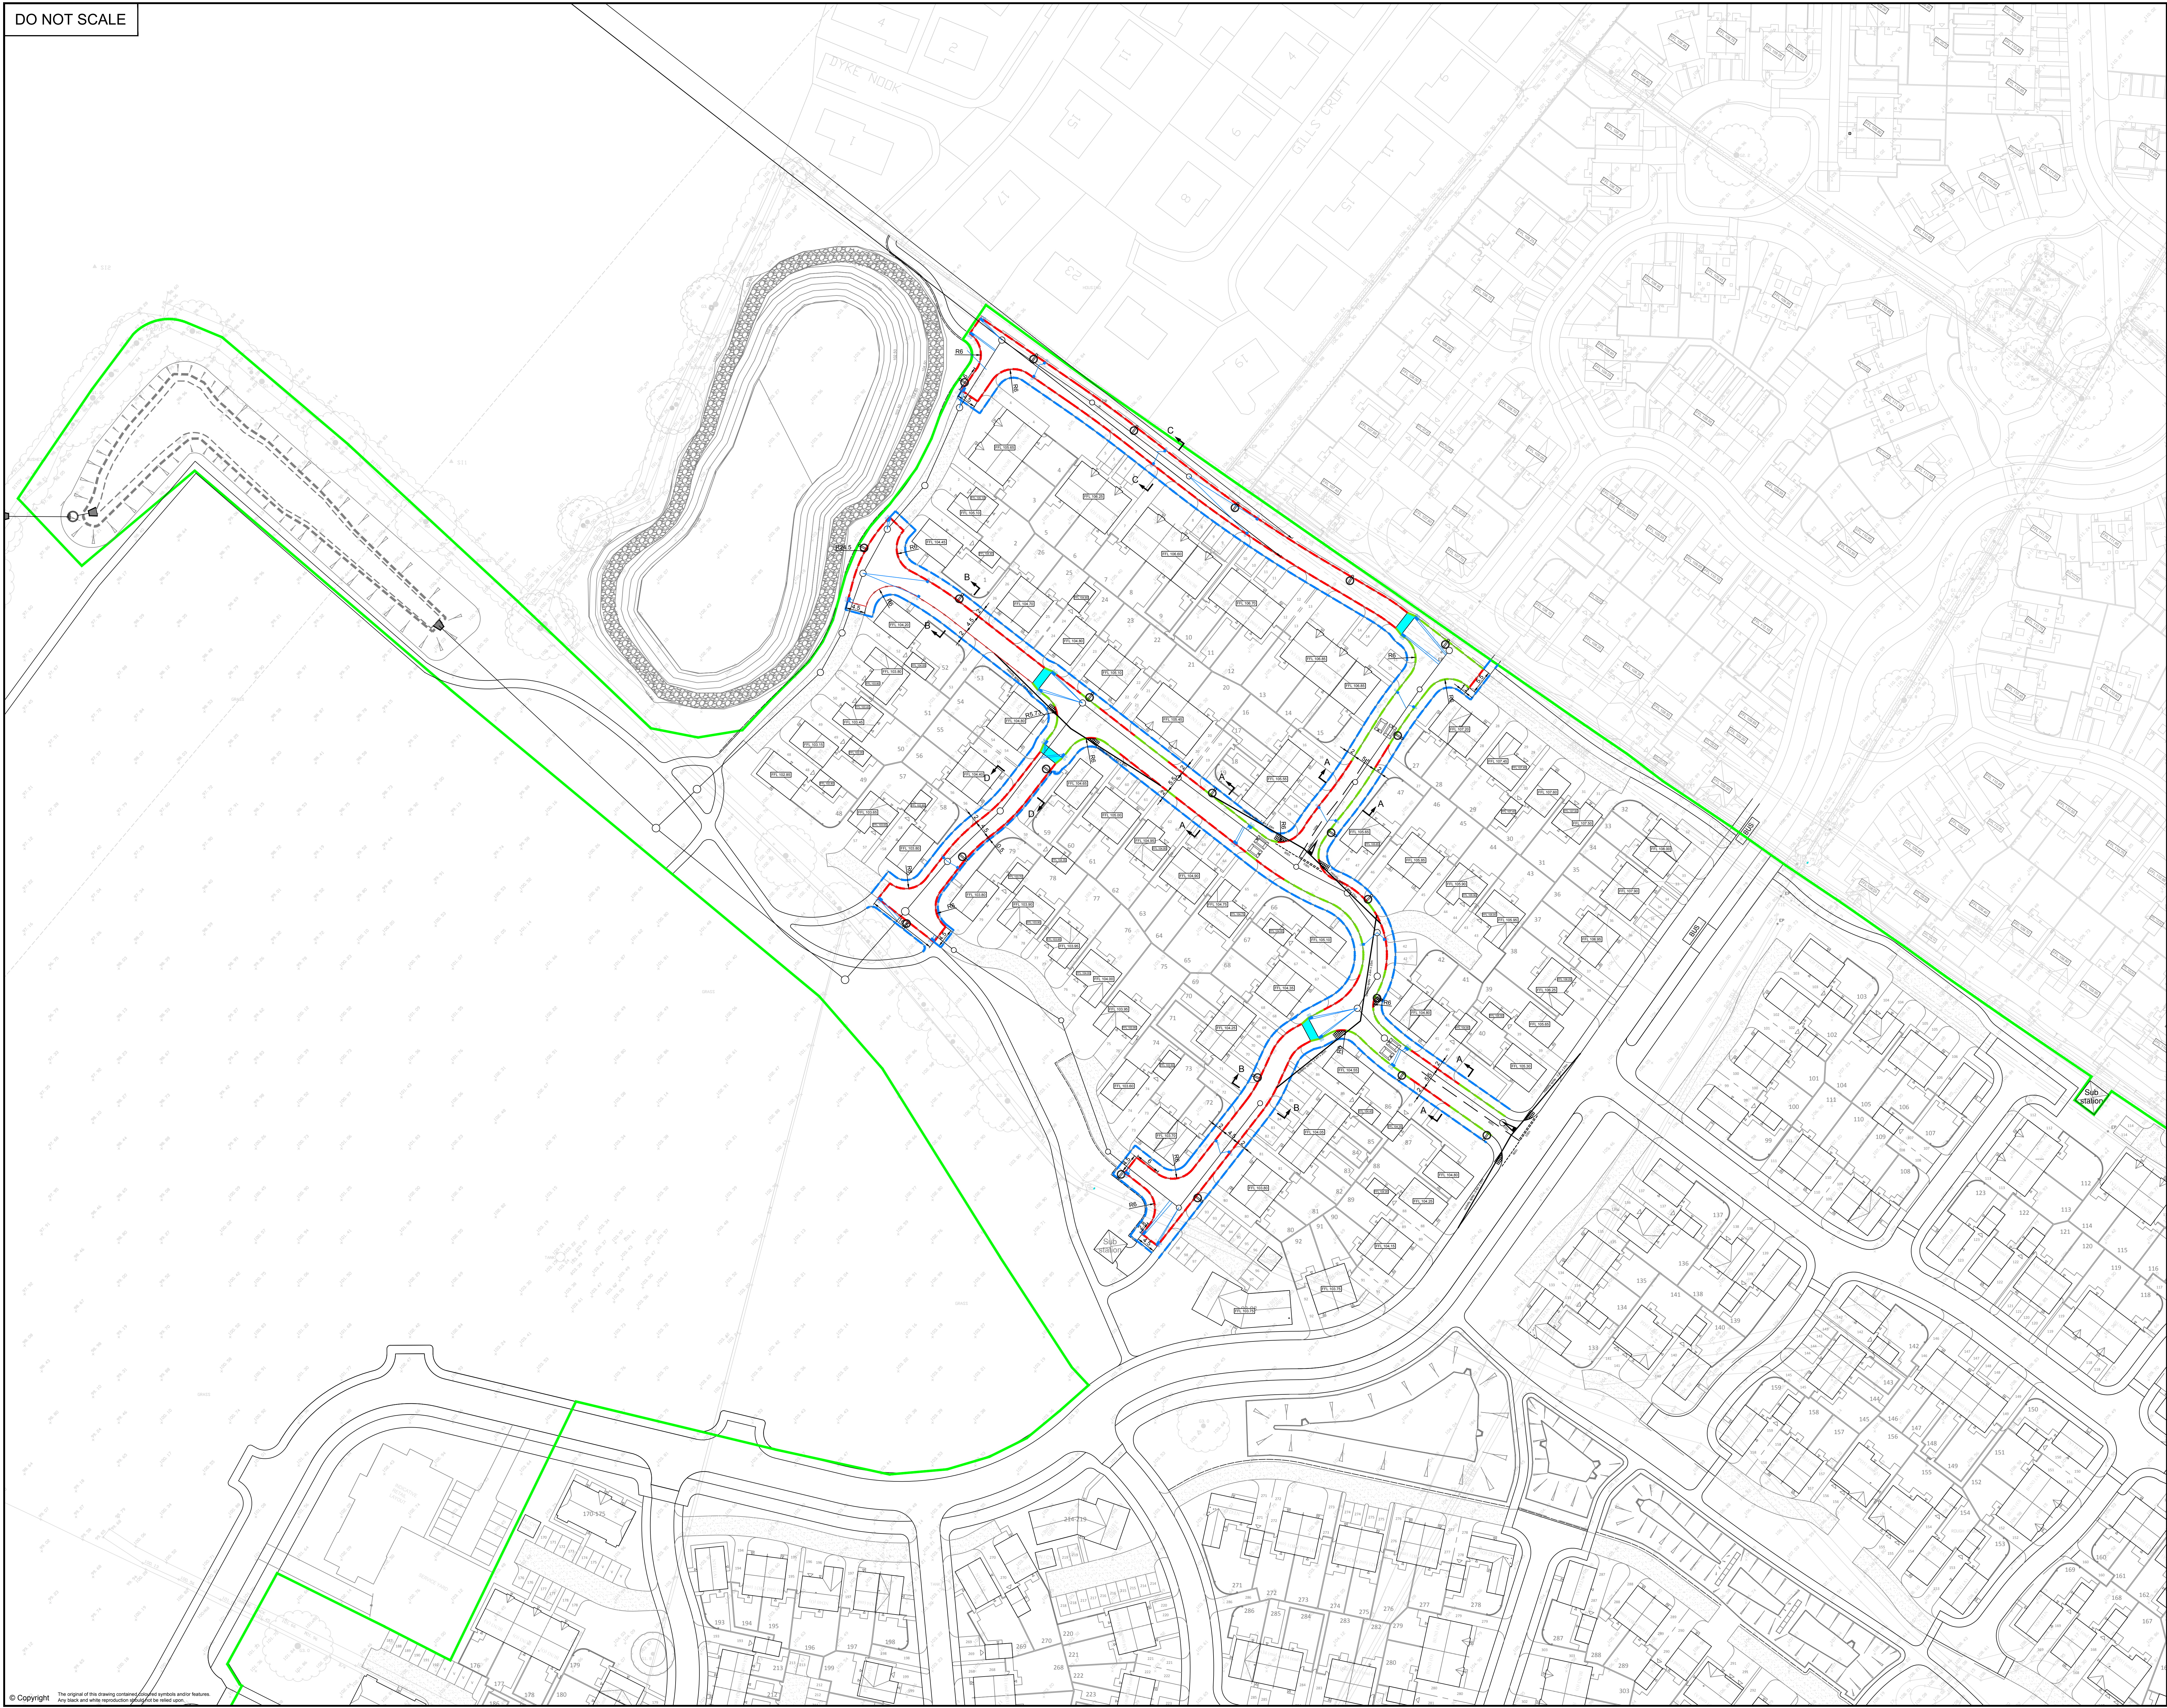

Notes

1. Refer to Drawing No. 6263 P3 / 02 for general highway notes.
2. Refer to Drawing No. 6263 P3 / 05 for typical cross sections.
3. All works to be in accordance with Lancashire County Council's Specification and Standard Details, and as agreed with Lancashire County Council's representative.
4. All sign diagram numbers are in accordance with The Traffic Signs Regulations and General Directions 2016 and The Traffic Signs Manual : Chapter 5 Road Markings.
5. Flat top edgings to be installed at back of all footways unless stated otherwise.
6. For radii of 12m or less, purpose made radii kerbs are to be used.
7. Kerb face for Vehicular Crossing = 25mm
Kerb Face for Pedestrian Crossing = 6mm (maximum)

Legend

- Site Boundary
- Half Battered kerb (HB2) - 100mm UPSTAND
- Flat top edging kerb (EF) - FLUSH
- Bull nose kerb (BN) - 25mm UPSTAND
6mm (maximum) at pedestrian crossing
- 2.0m Ramp (refer to Dig 6263 P3 / 05 for details)
- Street Light Locations
(Refer to Hartron drawing 21140-D-01)
- Street Light Locations
(TBC)
- Surface water sewer
- Highway Gully
- Tactile paving provided at all pedestrian crossings
- Speed Cushions - To Lancashire County Council Specification and Standard Details

Coopers Drawing List:

- 6263 P3 / 01 Proposed Drainage Layout
- 6263 P3 / 02 Proposed Highway Setting Out
- 6263 P3 / 03 Proposed Highway Layout
- 6263 P3 / 04 Proposed Highway Levels and Longsections
- 6263 P3 / 05 Highway Construction Details
- 6263 P3 / 06 External Works Layout
- 6263 P3 / 07 Private Drainage Layout
- 6263 P3 / 08 Drainage Construction Details
- 6263 P3 / 09 Surface Water Manhole Schedules
- 6263 P3 / 10 Foul Manhole Schedules
- 6263 P3 / 11 Surface Water Manhole Details
- 6263 P3 / 12 Foul Manhole Details
- 6263 P3 / 13 Flow Control Manhole Details
- 6263 P3 / 14 Drainage Longsections
- 6263 P3 / 15 Surface Water Catchment Areas
- 6263 P3 / 16 Detention Basin Layout
- 6263 P3 / 17 Sewer Easement Plan
- 6263 P3 / 18 S38 Agreement Plan
- 6263 P3 / 19 Earthworks

APPROVAL

A	02.04.20	Issued for S38 Approval	PJN	AJ
Rev.	Date	Revision	By	Appd.

**coopers**
chartered consulting engineers

Tel: 01244 684910
Fax: 01244 684911
Email: admin@coopers.co.uk
Web: <http://coopers.co.uk>

Park House
Sandpiper Court
Chester Business Park
Chester
CH4 9QU

Client

Taylor Wimpey

Project

STANDEN HALL
CLITHEROE

Title

PHASE 3
Highway Layout

DRAWING NUMBER	SCALE at AD	1:500	DATE	NOV 19	REVISION
6263 P3 / 03	DRAWN	LW	CHECKED	AJ	A