


DO NOT SCALE

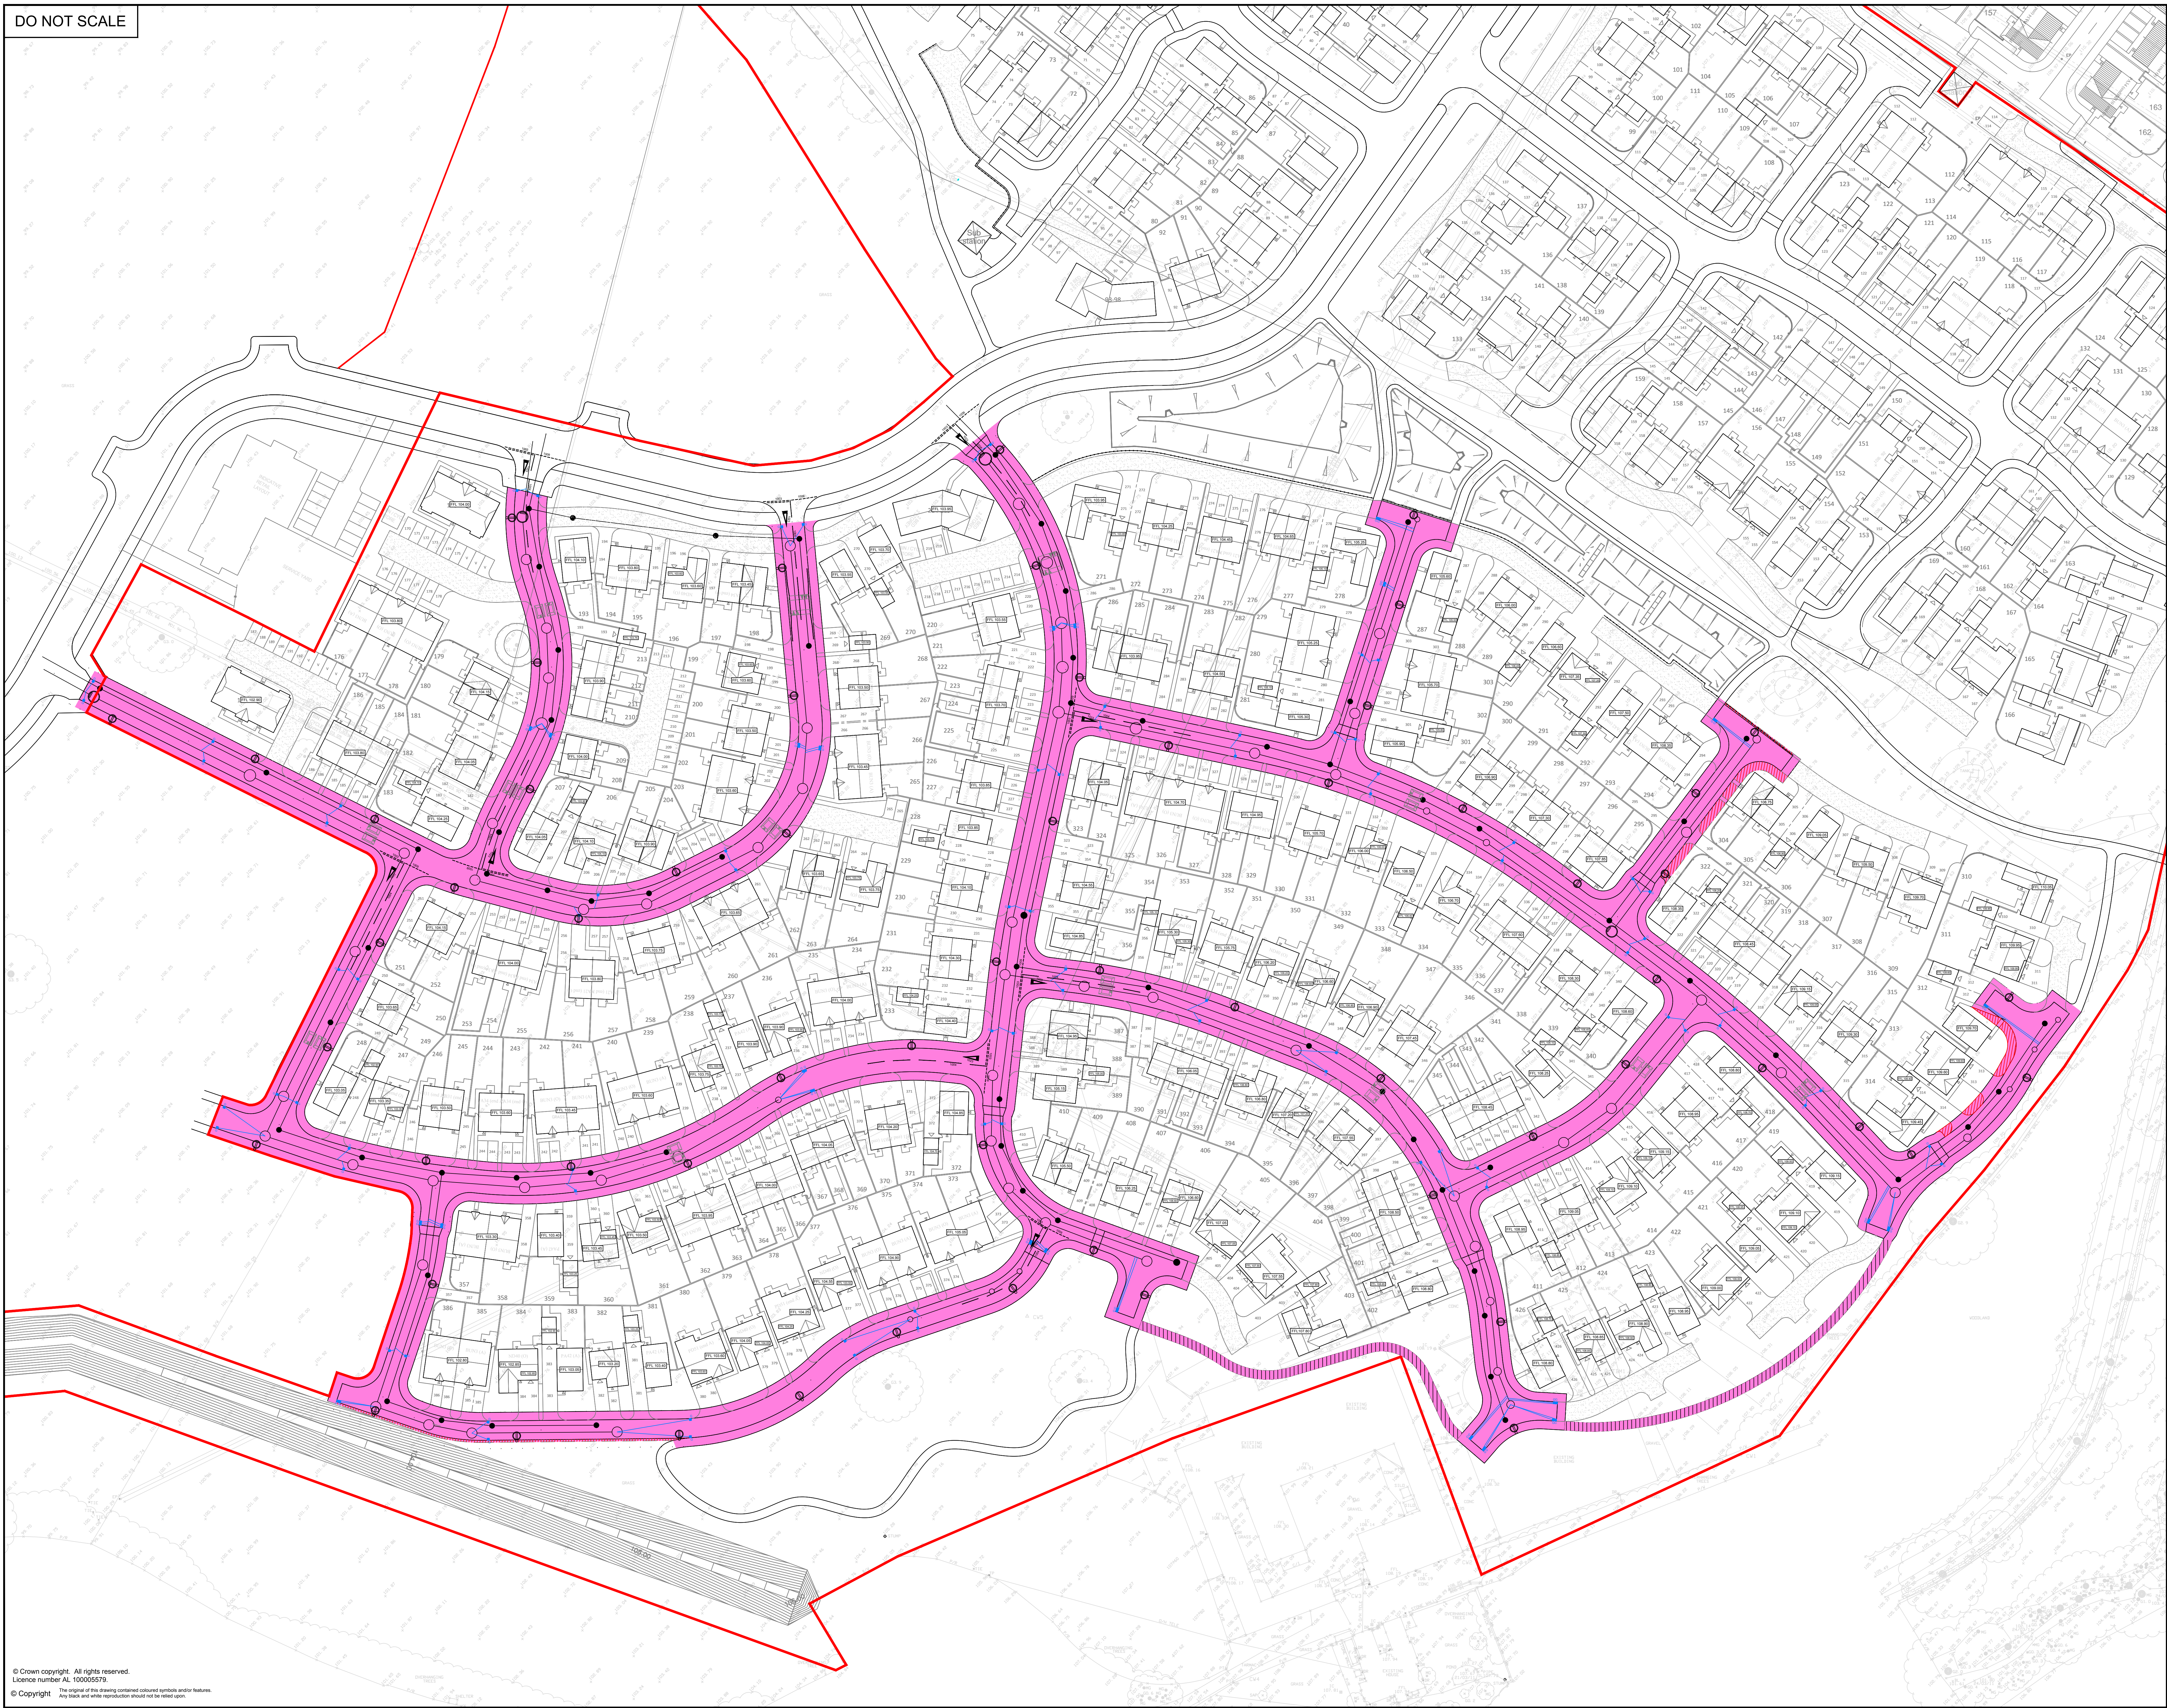

- Legend**
- Site Boundary
 - Section 38 Highway
 - Off Road Footpath
 - Section 142 Agreement for Service Verges
 - Adopted Highway Drains
 - S104 Surface Water Sewer
 - S104 Foul Water Sewer
 - Street Light Locations (Refer to Hartron drawing 21140-D-01)
 - Speed Cushions - To Lancashire County Council Specification and Standard Details
 - Speed Hump - To Lancashire County Council Specification and Standard Details

Coopers Drawing List:

- 6263 P4 / 01 Proposed Drainage Layout
- 6263 P4 / 02 Proposed Highway Setting Out
- 6263 P4 / 03 Proposed Highway Layout
- 6263 P4 / 04 Proposed Highway Levels and Longcations
- 6263 P4 / 05 Highway Construction Details
- 6263 P4 / 06 External Works Layout
- 6263 P4 / 07 Private Drainage Layout
- 6263 P4 / 08 Drainage Construction Details
- 6263 P4 / 09 Surface Water Manhole Schedules
- 6263 P4 / 10 Foul Manhole Schedules
- 6263 P4 / 11 Surface Water Manhole Details
- 6263 P4 / 12 Foul Manhole Details
- 6263 P4 / 13 Flow Control Manhole Details
- 6263 P4 / 14 Drainage Longcations
- 6263 P4 / 15 Surface Water Catchment Areas
- 6263 P4 / 16 Sower Easement Plan
- 6263 P4 / 17 S38 Agreement Plan

APPROVAL

A	05.05.20	Updated to show Plots 200 & 201, 258 & 259, 364-366 substitutions	PJN	AJ
Rev.	Date	Revision	By	Appd.
 chartered consulting engineers Tel: 01244 684910 Fax: 01244 684912 Email: admin@coopers.co.uk Web: http://coopers.co.uk				
Client: Taylor Wimpey				
Project: STANDEN HALL CLITHEROE				
Title: PHASE 4 S38 Agreement Plan				
DRAWING NUMBER		SCALE at A0	1:500	REVISION
6263 P4 / 17		DATE	18.02.20	
		DRAWN	PW	
		CHECKED	AJ	A