



**Copyright notice:**  
 This and all other documents authored by CBRE and all information and concepts both depicted and implied therein are the sole property of CBRE. Reproduction or transmission in any form is strictly forbidden unless prior permission is obtained in writing from CBRE. Construction based on the depicted information at any time or location not related to this project is strictly forbidden unless prior permission is obtained in writing from CBRE.


**Disclaimer:**  
 CBRE accept no responsibility for the base build drawings. These were completed by PRA Architects on drawing no. Y81.1008.283, dates 11.11.16.

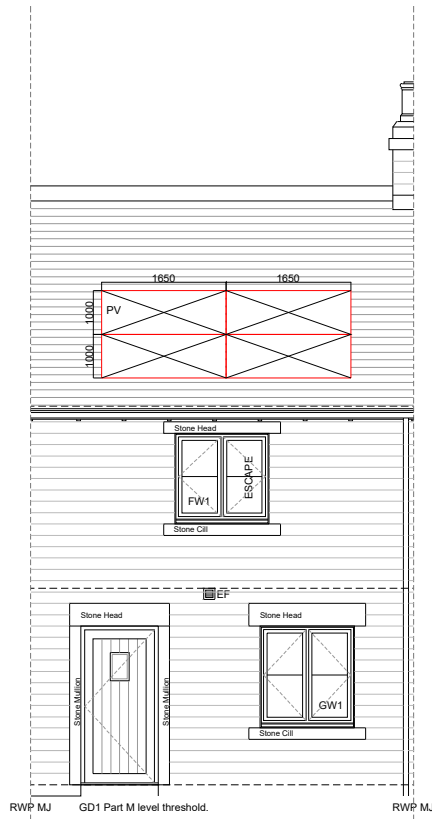


Front Elevation (South)

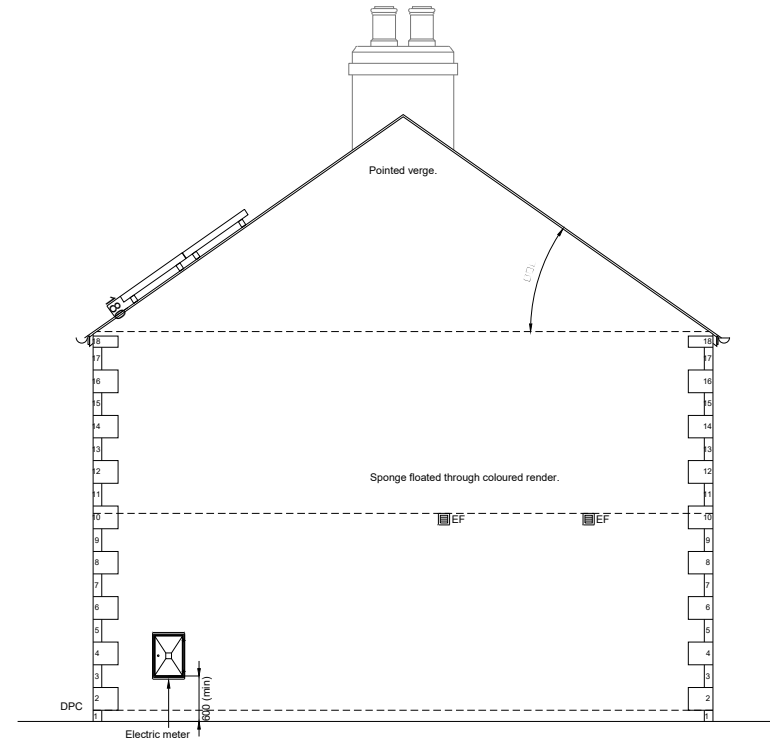

Side Elevation

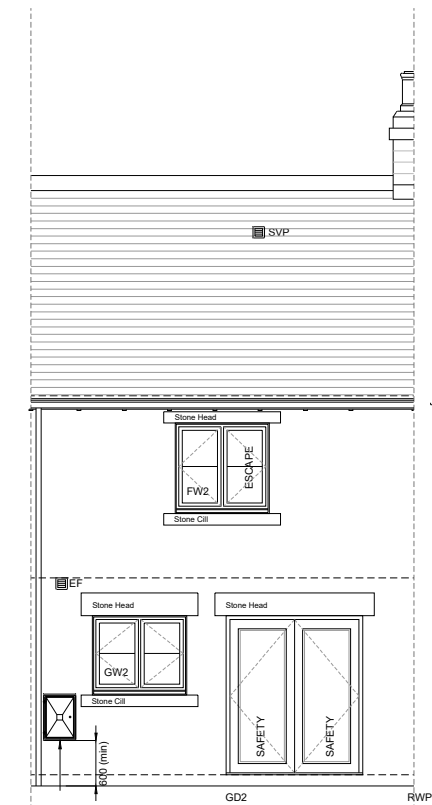

Rear Elevation (North)

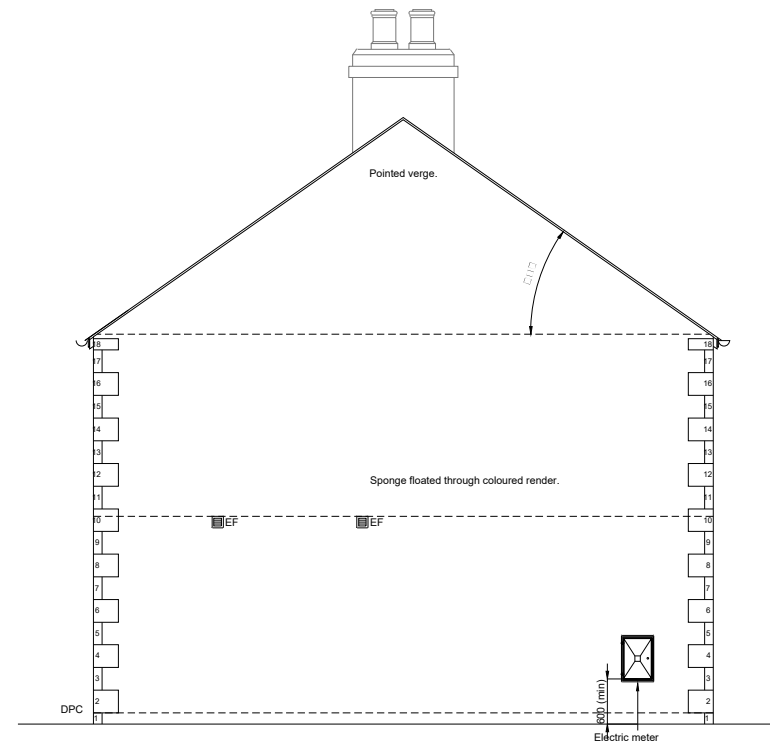

Scale 1:100 5 m

Revision	Date	Rev. Description
A	20.10.21	

Project  
**THE WARREN  
 HURST GREEN**

Drawing Title  
**CURRENT LOCATION OF SOLAR  
 PANELS - 7 FOX FALL DRIVE**

Client  
**HILLCREST HOMES**

Address Scale  
**MYNSHULLS HOUSE 1:100**  
 14 CATEATON STREET  
 MANCHESTER M3 1SQ

Drawing No. Drawing Status  
**50BCD00073923-05-04 FINAL**

Drawn Checked  
**DP OC**

Date Project Ref.  
**20.10.21 THE WARREN**

