


Copyright notice:
 This and all other documents authored by CBRE and all information and concepts both depicted and implied therein are the sole property of CBRE. Reproduction or transmission in any form is strictly forbidden unless prior permission is obtained in writing from CBRE. Construction based on the depicted information at any time or location not related to this project is strictly forbidden unless prior permission is obtained in writing from CBRE.

Disclaimer:
 CBRE accept no responsibility for the base build drawings. These were completed by PRA Architects on drawing no. Y81.1008:640, dates 07.02.17.

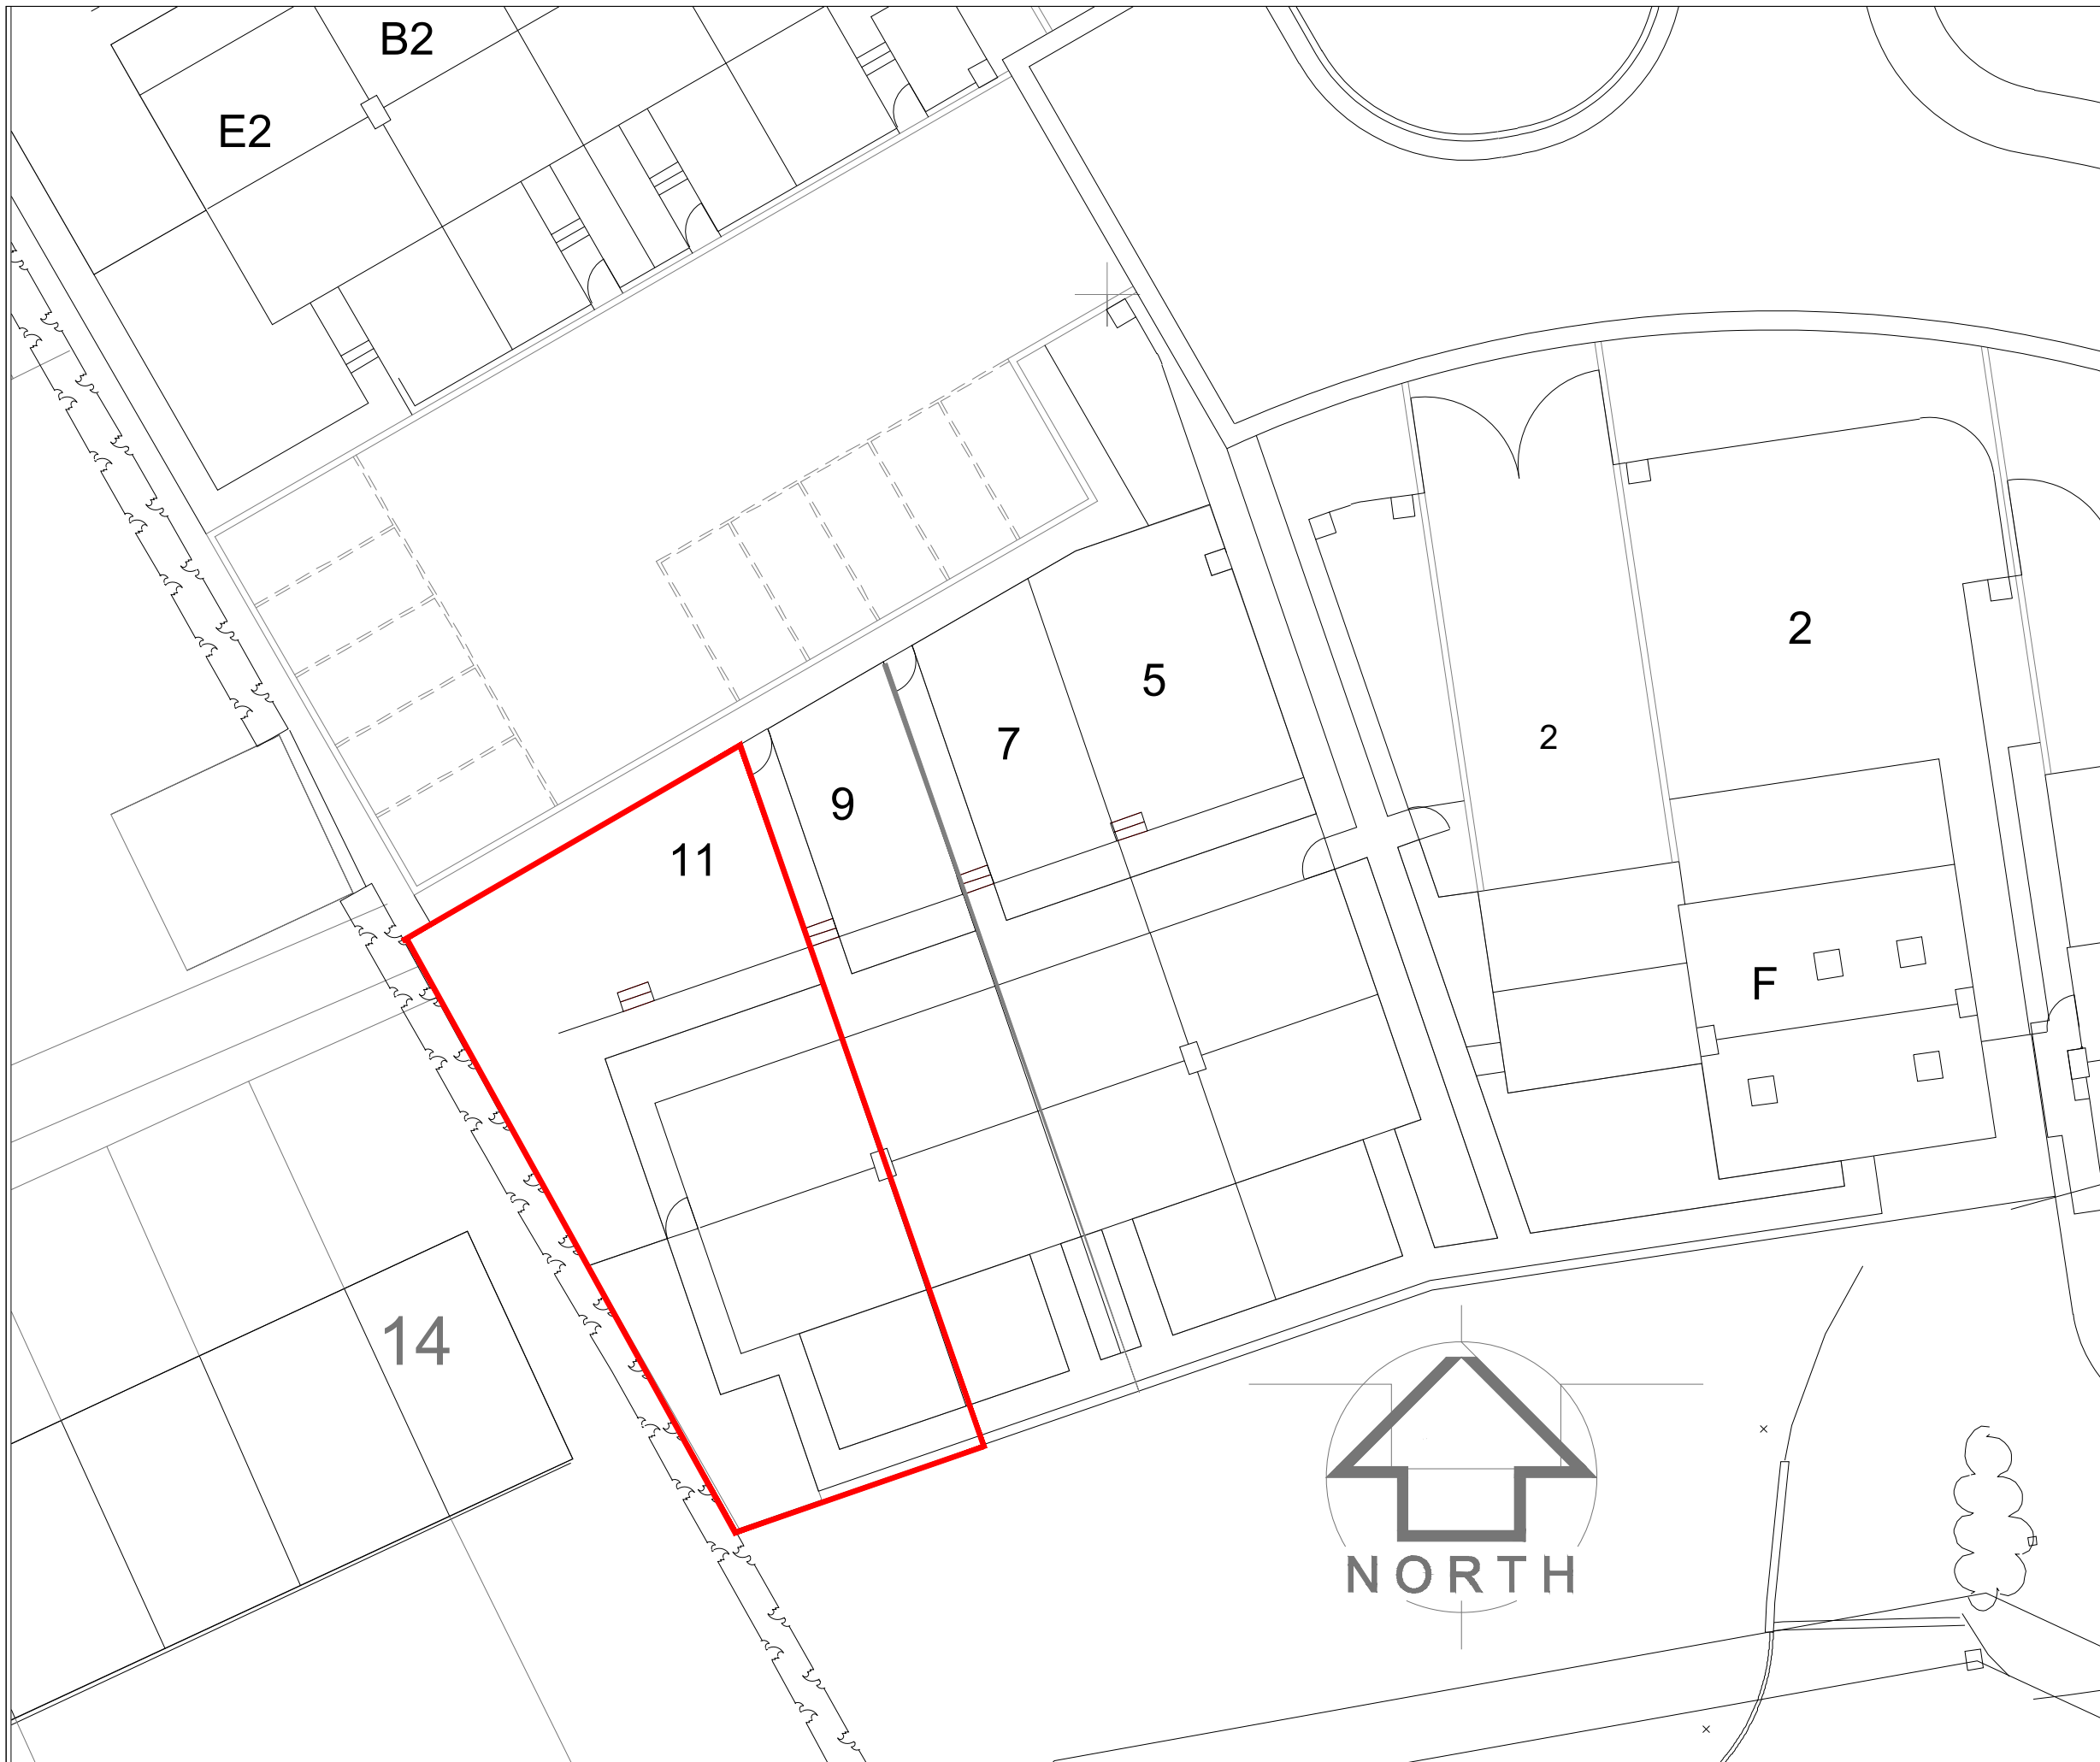

Revision	Date	Rev. Description
A	20.10.21	

Project
**THE WARREN
 HURST GREEN**

Drawing Title
**SITE PLAN -
 11 FOX FALL DRIVE**

Client
HILLCREST HOMES

Address Scale
 MYNSHULLS HOUSE 1:200
 14 CATEATON STREET
 MANCHESTER M3 1SQ

Drawing No. Drawing Status
 50BCD00073923- 11-02 FINAL

Drawn Checked
 DP OC

Date Project Ref.
 20.10.21 THE WARREN

