


**Copyright notice:**  
This and all other documents authored by CBRE and all information and concepts both depicted and implied therein are the sole property of CBRE. Reproduction or transmission in any form is strictly forbidden unless prior permission is obtained in writing from CBRE. Construction based on the depicted information at any time or location not related to this project is strictly forbidden unless prior permission is obtained in writing from CBRE.

**Disclaimer:**  
CBRE accept no responsibility for the base build drawings. These were completed by PRA Architects on drawing no. Y81.1008:640, dates 07.02.17.

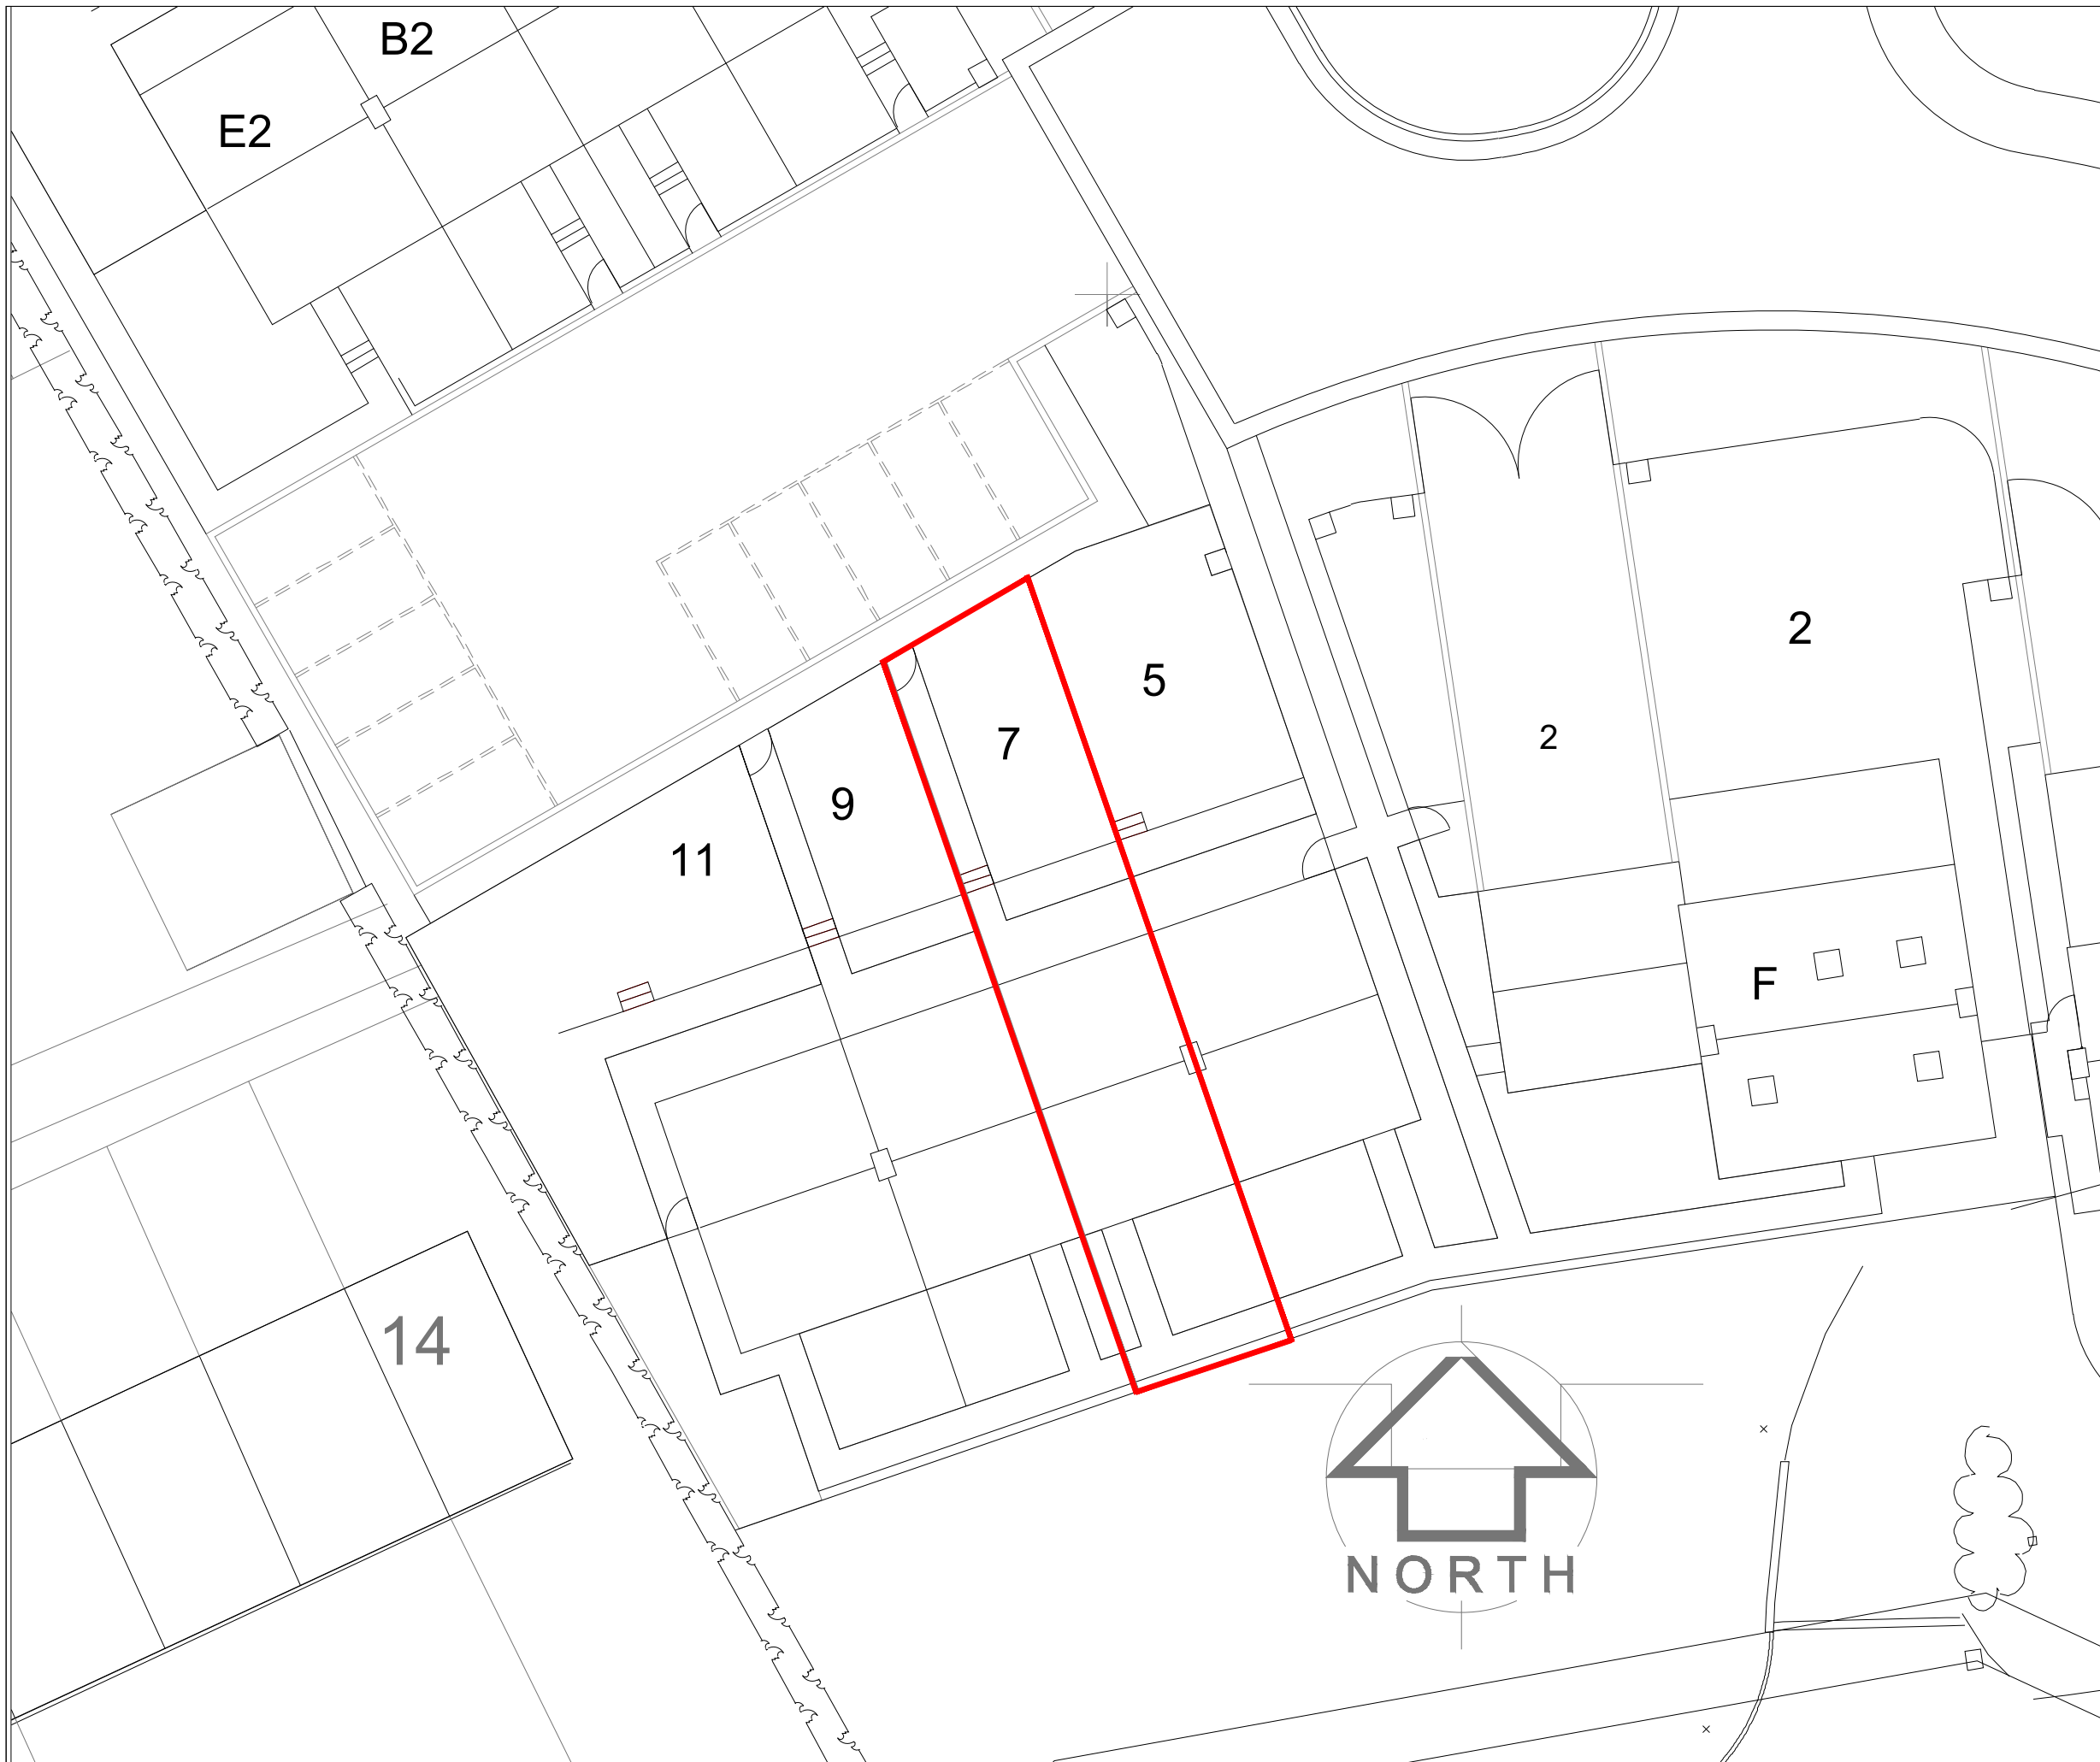

Revision	Date	Rev. Description
A	20.10.21	

Project  
**THE WARREN  
HURST GREEN**

Drawing Title  
**SITE PLAN -  
7 FOX FALL DRIVE**

Client  
**HILLCREST HOMES**

Address  
**MYNSHULLS HOUSE  
14 CATEATON STREET  
MANCHESTER M3 1SQ**

Drawing No. 50BCD00073923-07-02  
Drawing Status  
**FINAL**

Drawn DP  
Checked OC

Date 20.10.21  
Project Ref. THE WARREN

