


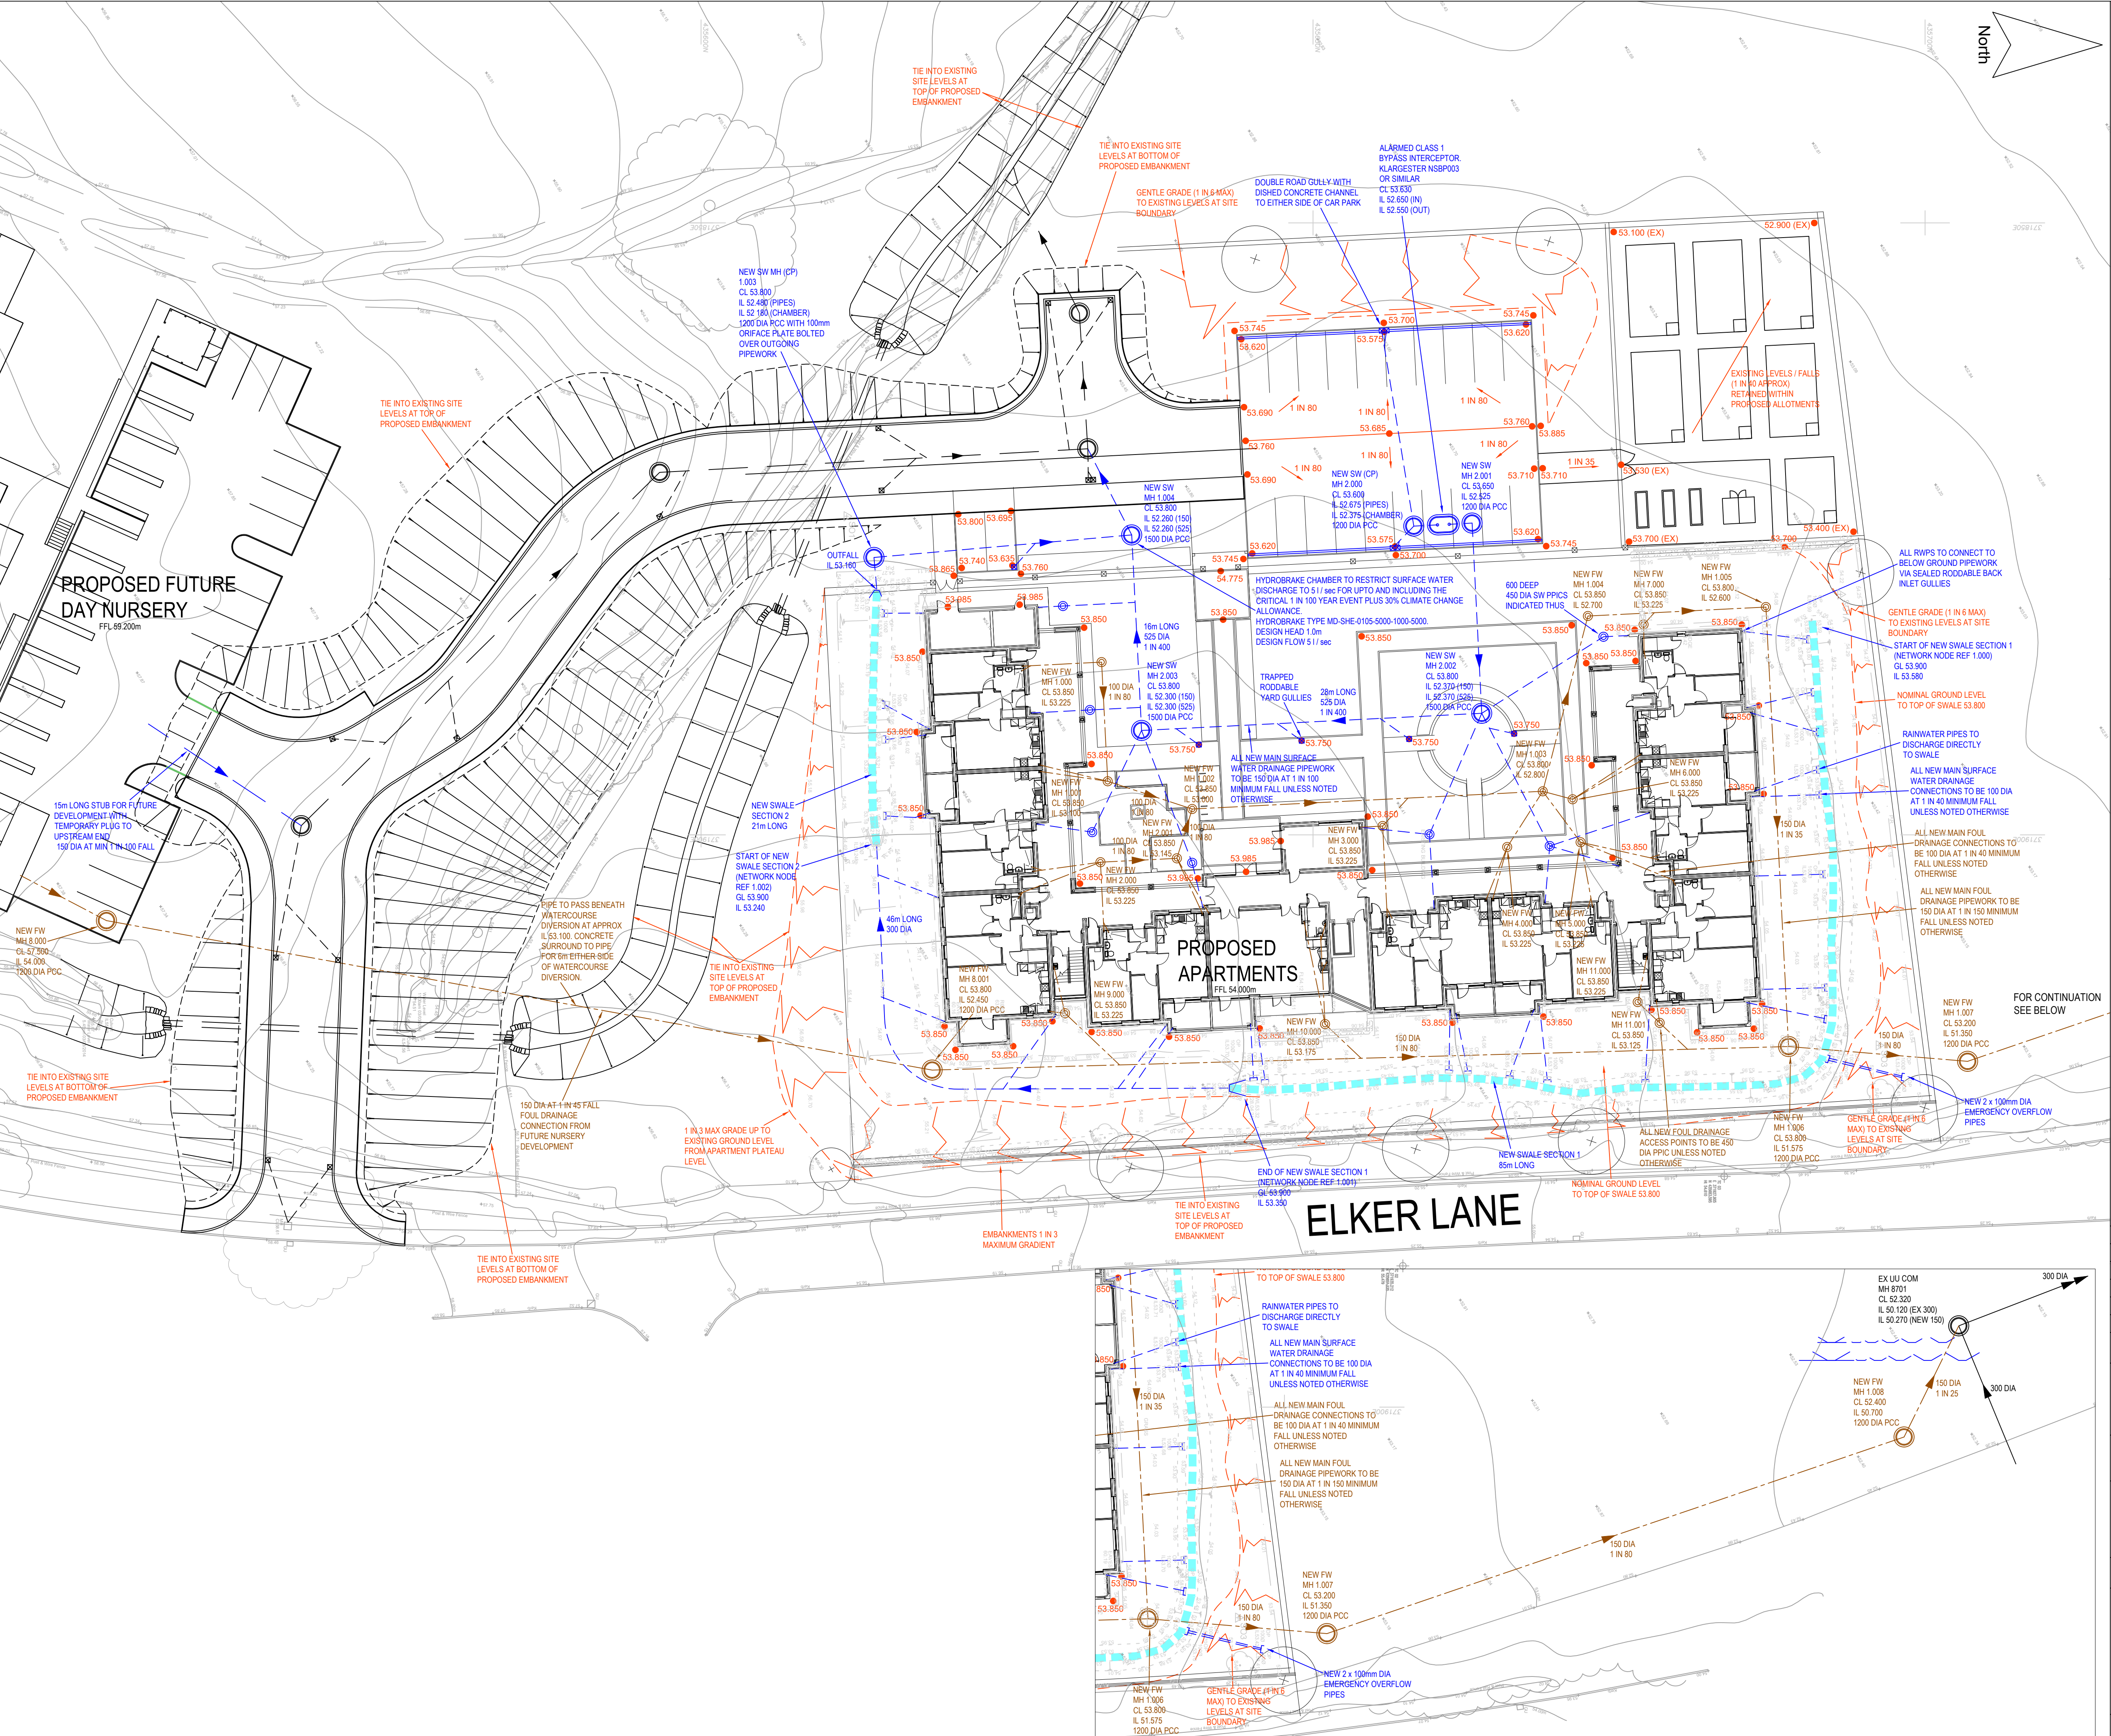

GENERAL NOTES

- 1. DO NOT SCALE FROM THIS DRAWING WORK TO FIGURED DIMENSIONS ONLY.
- 2. NO DEVIATION FROM THE DETAILS SHOWN ON THIS DRAWING IS ALLOWED WITHOUT PRIOR PERMISSION IN WRITING.
- 3. ALL DRAWINGS ARE TO BE READ IN CONJUNCTION WITH ALL ARCHITECTS, ENGINEERS AND SPECIALISTS DRAWINGS AND THE SPECIFICATION.
- 4. THE CONTRACTOR SHALL INCORPORATE ALL THE REQUIREMENTS OF THE PRE-TENDER STAGE HEALTH & SAFETY PLAN.

AS BUILT DRAWING

R3	AS BUILT / RECORD DRAWING ISSUE.	19.07.22	KPT	CM
R2	AS BUILT / RECORD DRAWING ISSUE.	08.05.17	KPT	CM
R1	RECORD DRAWING ISSUE.	07.12.16	KPT	CM
C2	AMENDED TO SUIT ARCHITECTS REVISED POP UP INFO.	02.11.15	KPT	CM
C1	CONSTRUCTION ISSUE.	04.09.15	KPT	CM
P1	PRELIMINARY ISSUE.	20.04.15	KPT	CM
Rev.	Amendment	Date	By	Chkd

Project
**ELKER LANE
BILLINGTON**

Client
ST VINCENTS HOUSING ASSOCIATION

Title
**PROPOSED PRIVATE
DRAINAGE LAYOUT**

Drawn KPT	Checked CM	Date APRIL 2015	Scale 1:250 @ A1
--------------	---------------	--------------------	---------------------

WML CONSULTING
Chartered Civil and Structural Engineers

No.8 Oak Green
Earl Road
Stanley Green Business Park
Cheshire SK9 6GL
Tel 0161 482 0600
Fax 0161 486 9210
e-mail info@wmlconsulting.com
www.wmlconsulting.com

Job No. 6421	Drawing No. E01 R3
------------------------	------------------------------