


FOR S10 DETAILS PLEASE REFER TO DRAWING  
19310-EDGE-XX-XX-DR-C-C2209\_SW HYDROBRAKE  
DETAILS

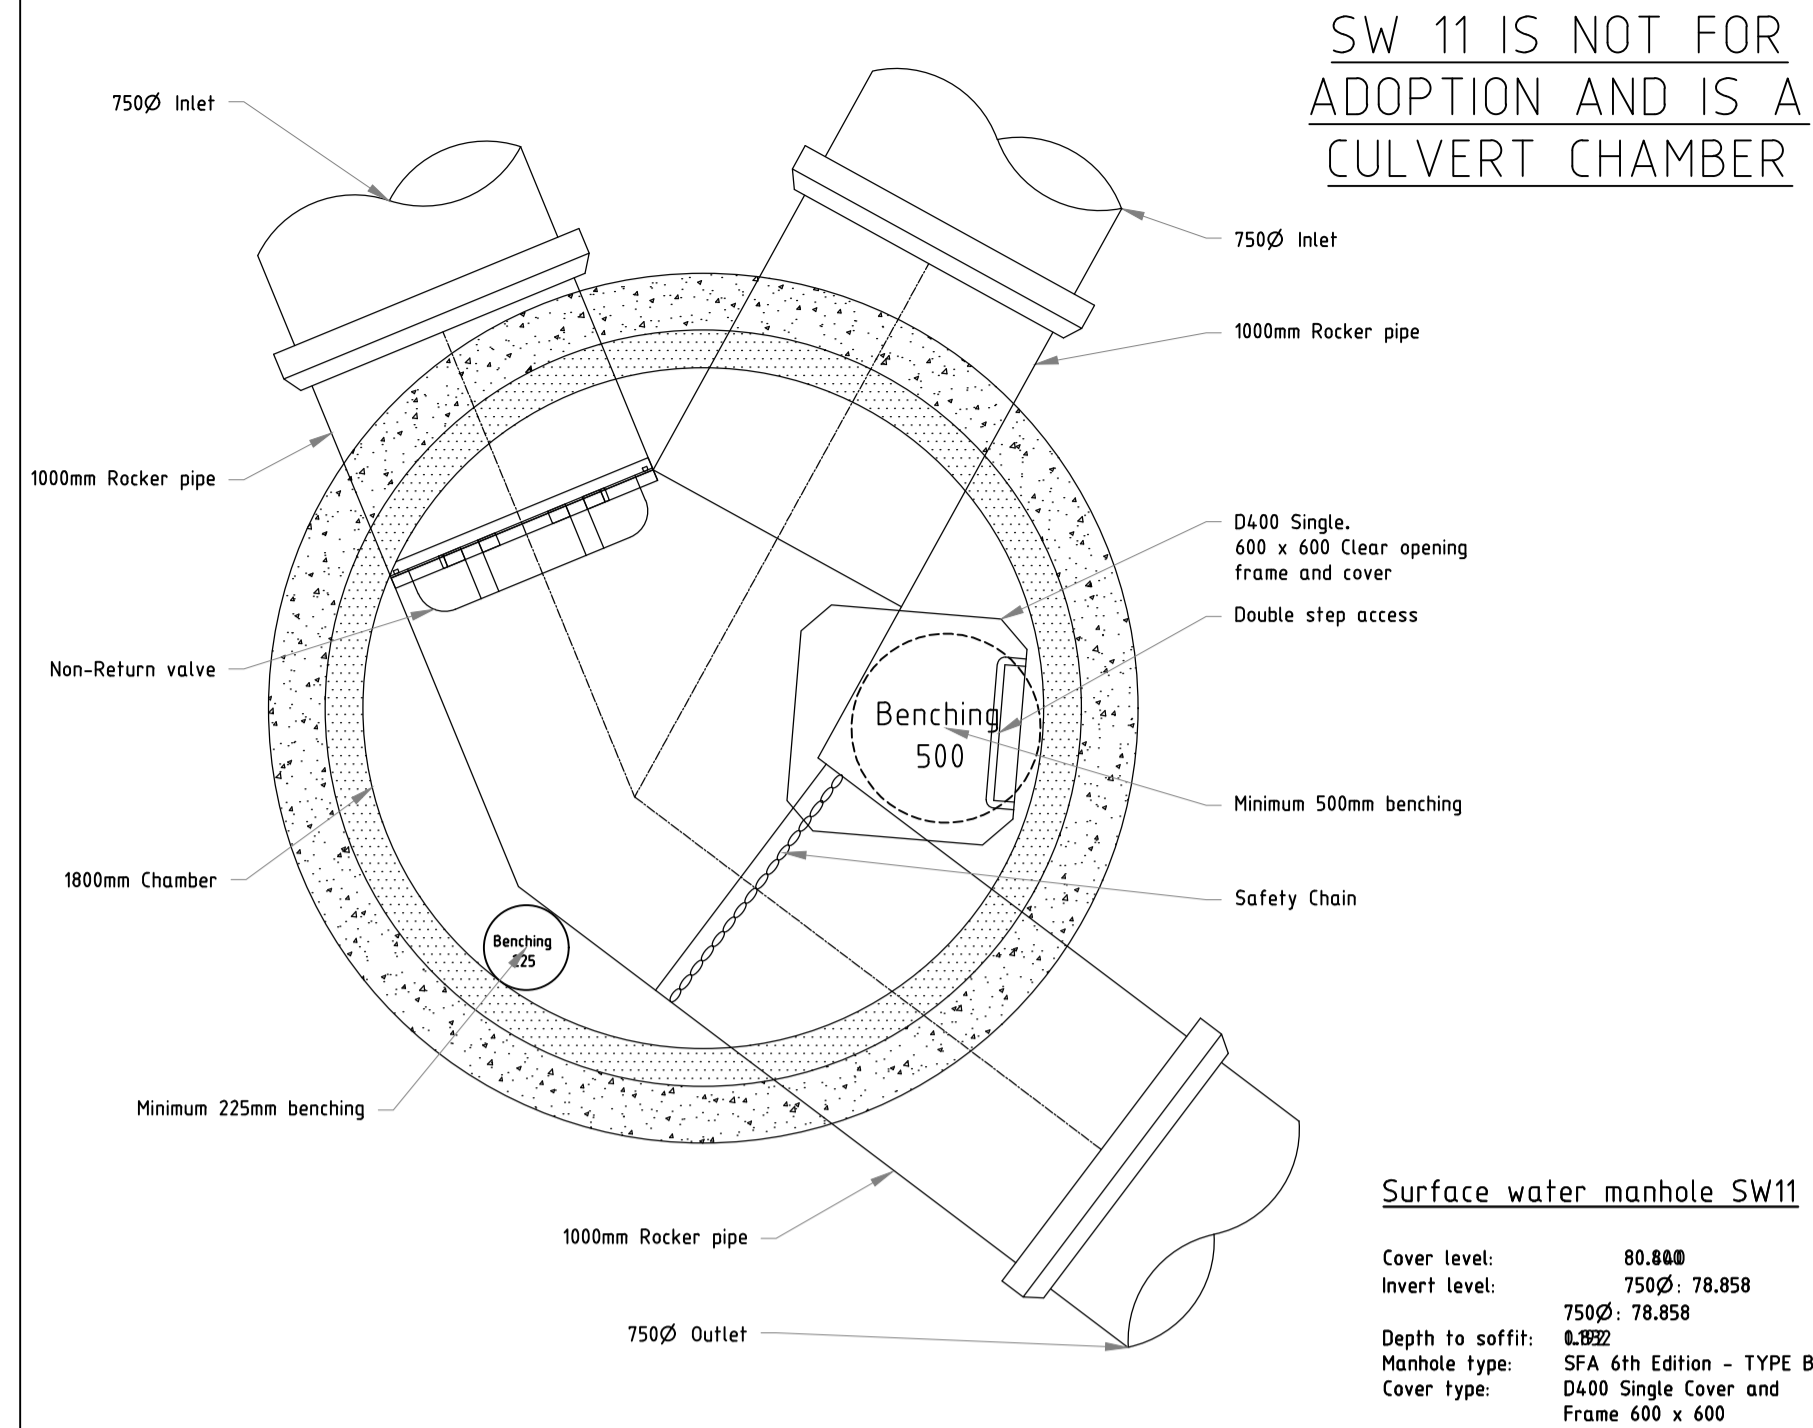

Rev	Date	Description	By	CHK
P07	29.10.20	Updated to match drainage layout	J.C	R.A
P06	17.09.20	PRELIMINARY - Updated to suit S.104 comments	D.A	R.A
P05	30.06.20	PRELIMINARY - Updated to suit S.104 comments	D.A	R.A
P04	17.04.20	PRELIMINARY - Updated to suit S.104 comments	D.A	R.A
P03	23.03.20	PRELIMINARY - Updated to suit S.104 comments	D.A	R.A
P02	20.02.20	PRELIMINARY - Updated S10 note	J.C	R.A
P01	24.01.20	PRELIMINARY - Issued for information	D.A	R.A

**EDGE CONSULTING ENGINEERS**  
www.edgece.com

**Manchester - UK**  
3rd Floor, Cornaton Court,  
12 Blackfriars Street,  
Manchester, M3 5BQ,  
United Kingdom

T: +44 (0) 161 834 1938  
E: manchester@edgece.com

The concepts + information contained in this document are the copyright of EDGE Consulting Engineers. Use or copying of this document in whole or in part without the written permission of EDGE Consulting Engineers constitutes an infringement of copyright.  
**DO NOT SCALE DRAWINGS. IF IN DOUBT, ASK!**

Project Name  
**HAWTHORNE FARM  
CLITHEREO**

Client  
**PERSIMMON HOMES**

Designed	Drawn	Checked	Scale @) A1
D.A	D.A	M.A	1:20

Drawing Title  
**1 TO 20  
SURFACE MANHOLE DETAILS  
SHEET 2**

Project No.  
**19310**

Drawing No.  
**19310-EDGE-XX-XX-DR-C-C2112**

Revision  
**P07**

**PRELIMINARY  
NOT FOR CONSTRUCTION**

PLOT DATE

