


Sunny Meade

N

0.018Ha to drain to existing gully in Whalley Road. Subject to approval from relevant authorities.

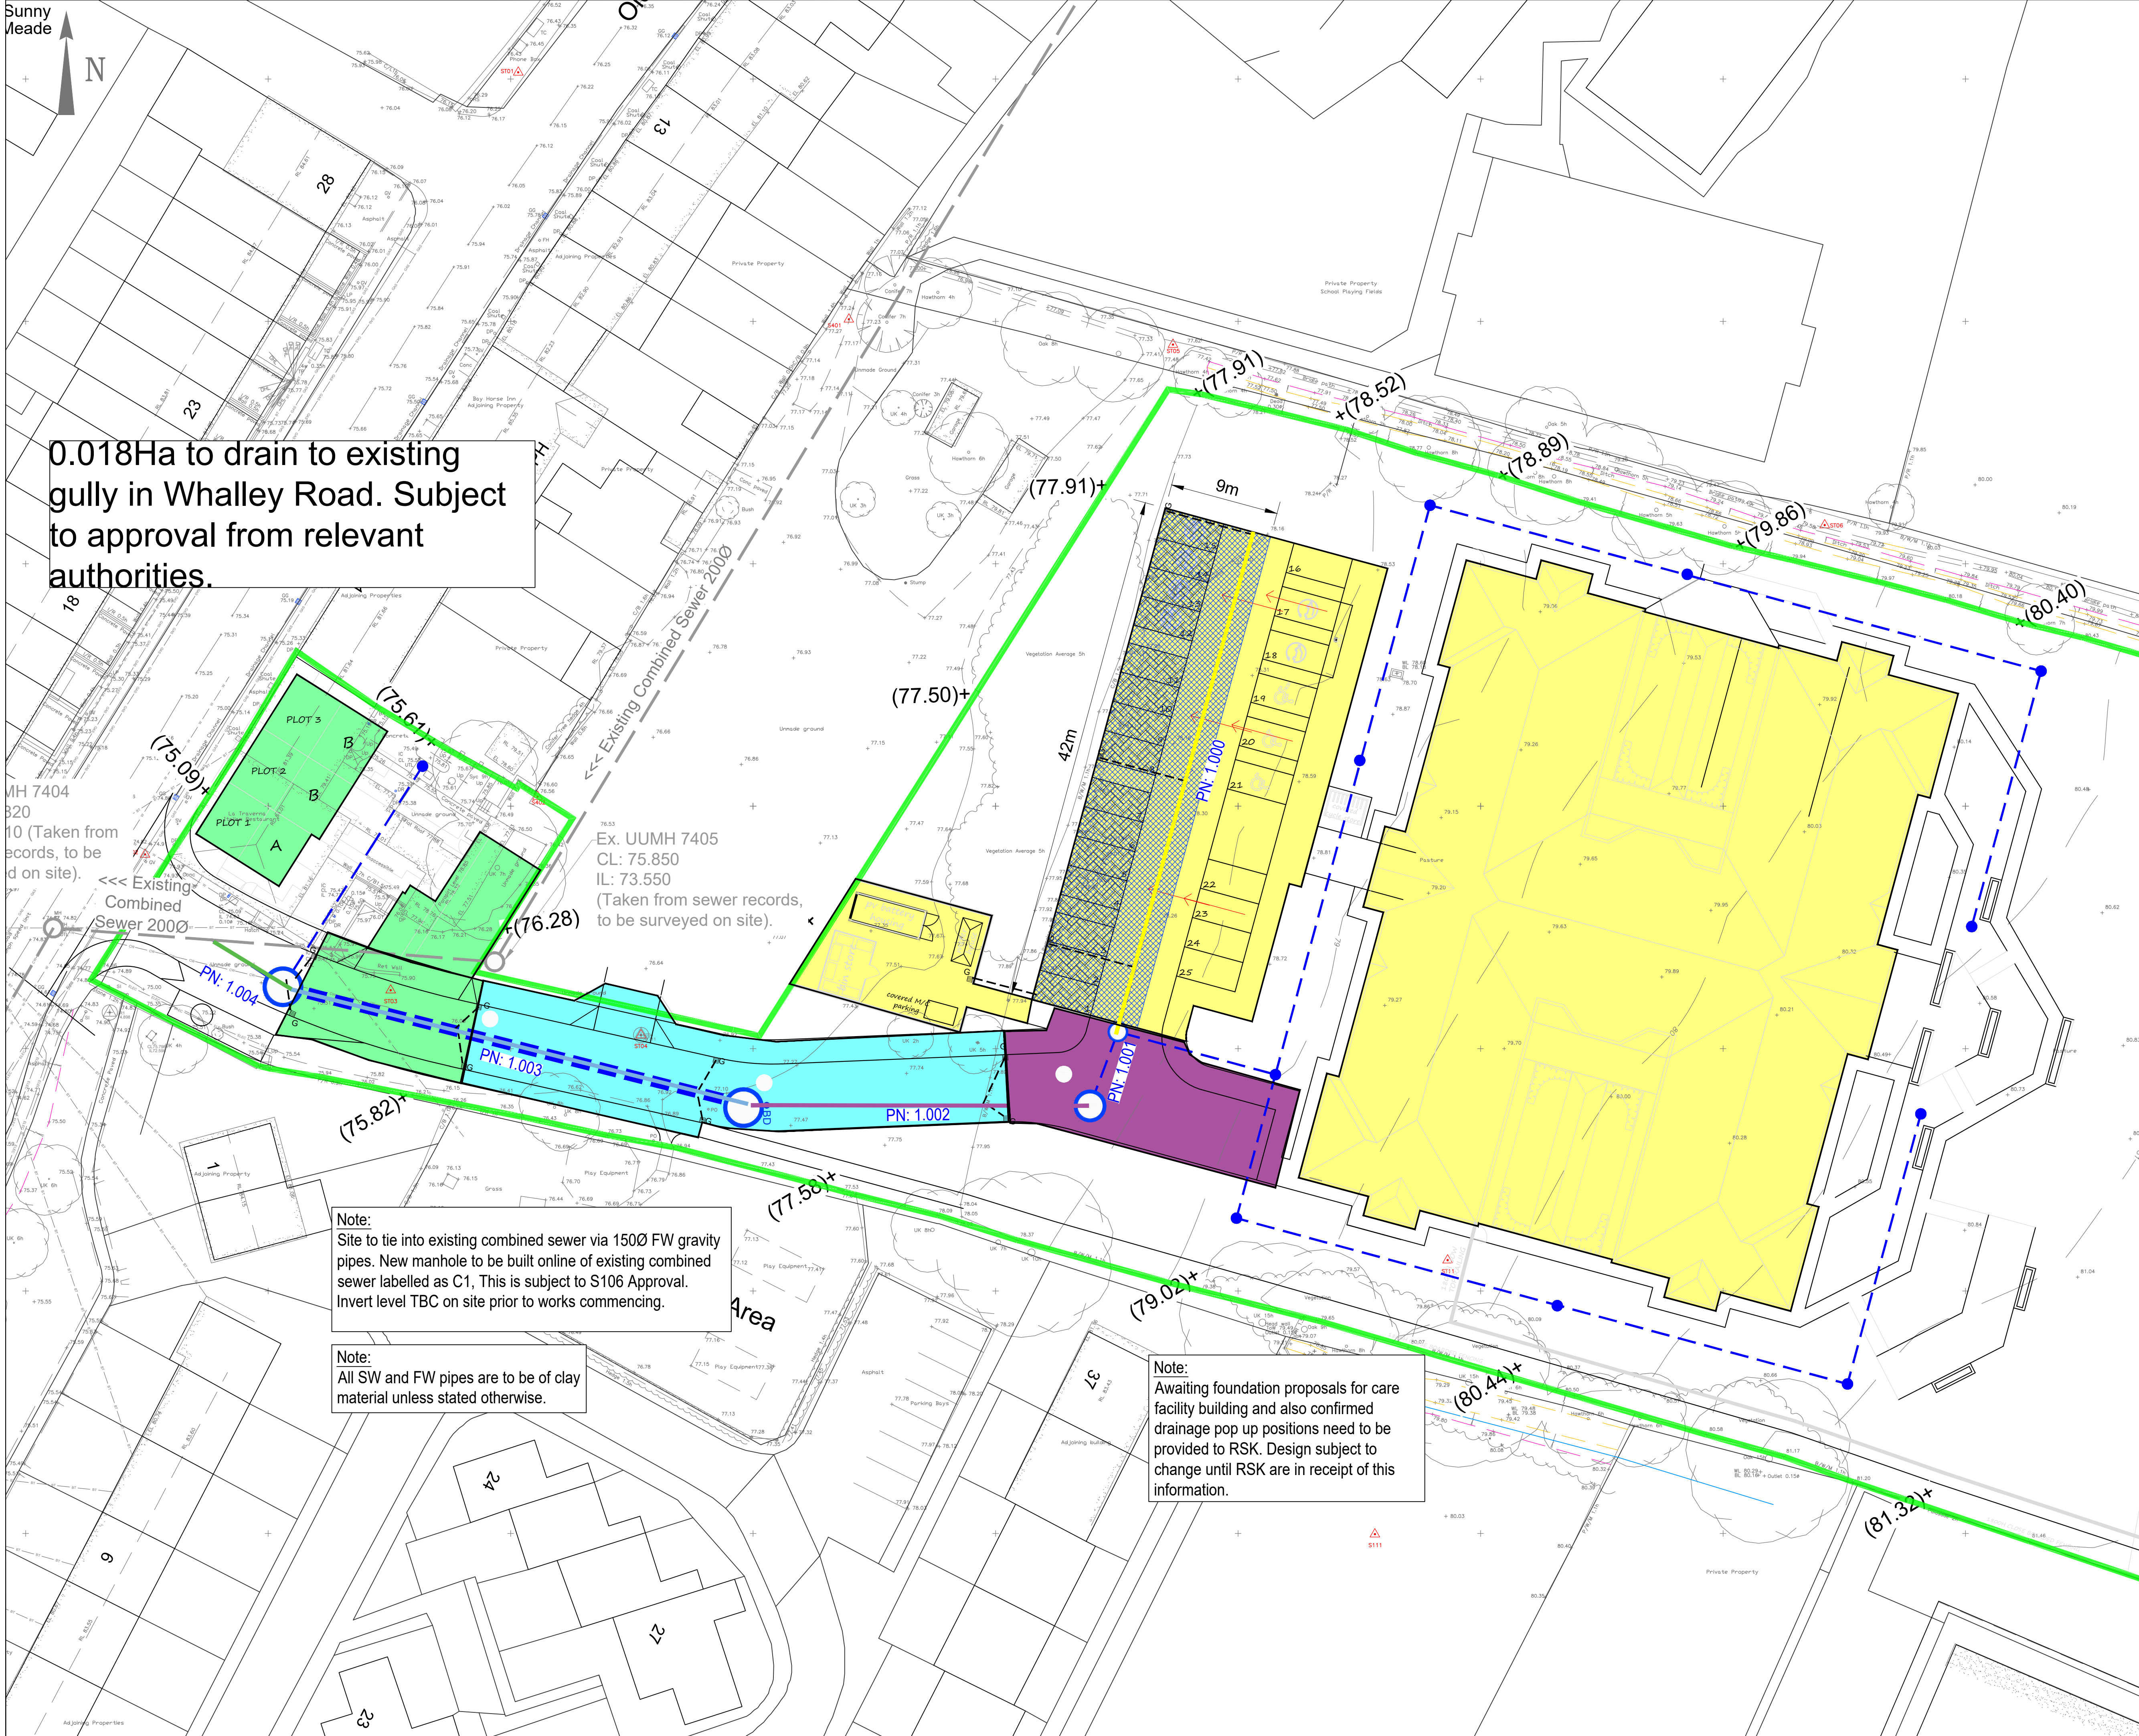

CIVIL / STRUCTURAL DESIGN RISK MANAGEMENT

Abnormal or unusual residual risks associated with the design outcomes shown on this drawing are:-

RSK LDE LTD has followed its Design Risk Management process for Hazard Elimination and Risk reduction in developing the designs shown on this drawing. Abnormal or unusual residual risks may be shown above where it is considered that such risk may not normally be expected by competent persons engaged on work of this nature or type.

Notes:

1. This drawing is to be read in conjunction with all relevant Architect's and Engineer's drawings.
2. All levels quoted are in metres A.O.D.
3. The drainage and storage design assumes the catchments as shown these may be subject to change.
4. For drainage layout please see RSK drawing '10-01'

Legend

- Proposed Surface Water sewer and manhole
- Existing Combined Water sewer and manhole
- Proposed Combined Water manhole
- PN1.000 - 0.310Ha
- PN1.001 - 0.000Ha
- PN1.002 - 0.020Ha
- PN1.003 - 0.041Ha
- PN1.004 - 0.035Ha
- TOTAL IMPERMEABLE AREA = 0.406Ha
- Site Boundary

P1	02.06.23	First Issue		MH	MS
Rev.	Date	Amendment	Drawn	Chkd.	Appd.

RSK
LAND & DEVELOPMENT ENGINEERING LTD
Spring Lodge
172 Chester Road
Helsby
Cheshire, WA6 0AR
United Kingdom
Tel: +44 (0) 1928 726006
Fax: +44 (0) 1928 725633
Email: lda@rsk.co.uk
Web: www.rsk.co.uk

Client
LNT Construction

Project Title
Whalley Road
Barrow

Status
INFORMATION

Drawing Title
Impermeable Area Plan

Drawn MH	Date May 23	Checked MS	Date	Approved	Date
Scale 1:250	Orig Size A1	Dimensions	Project No. 882667	Drawing File	
Drawing No. 10-02	Rev. P1				