


0 2 4 6m

1:100 Scale

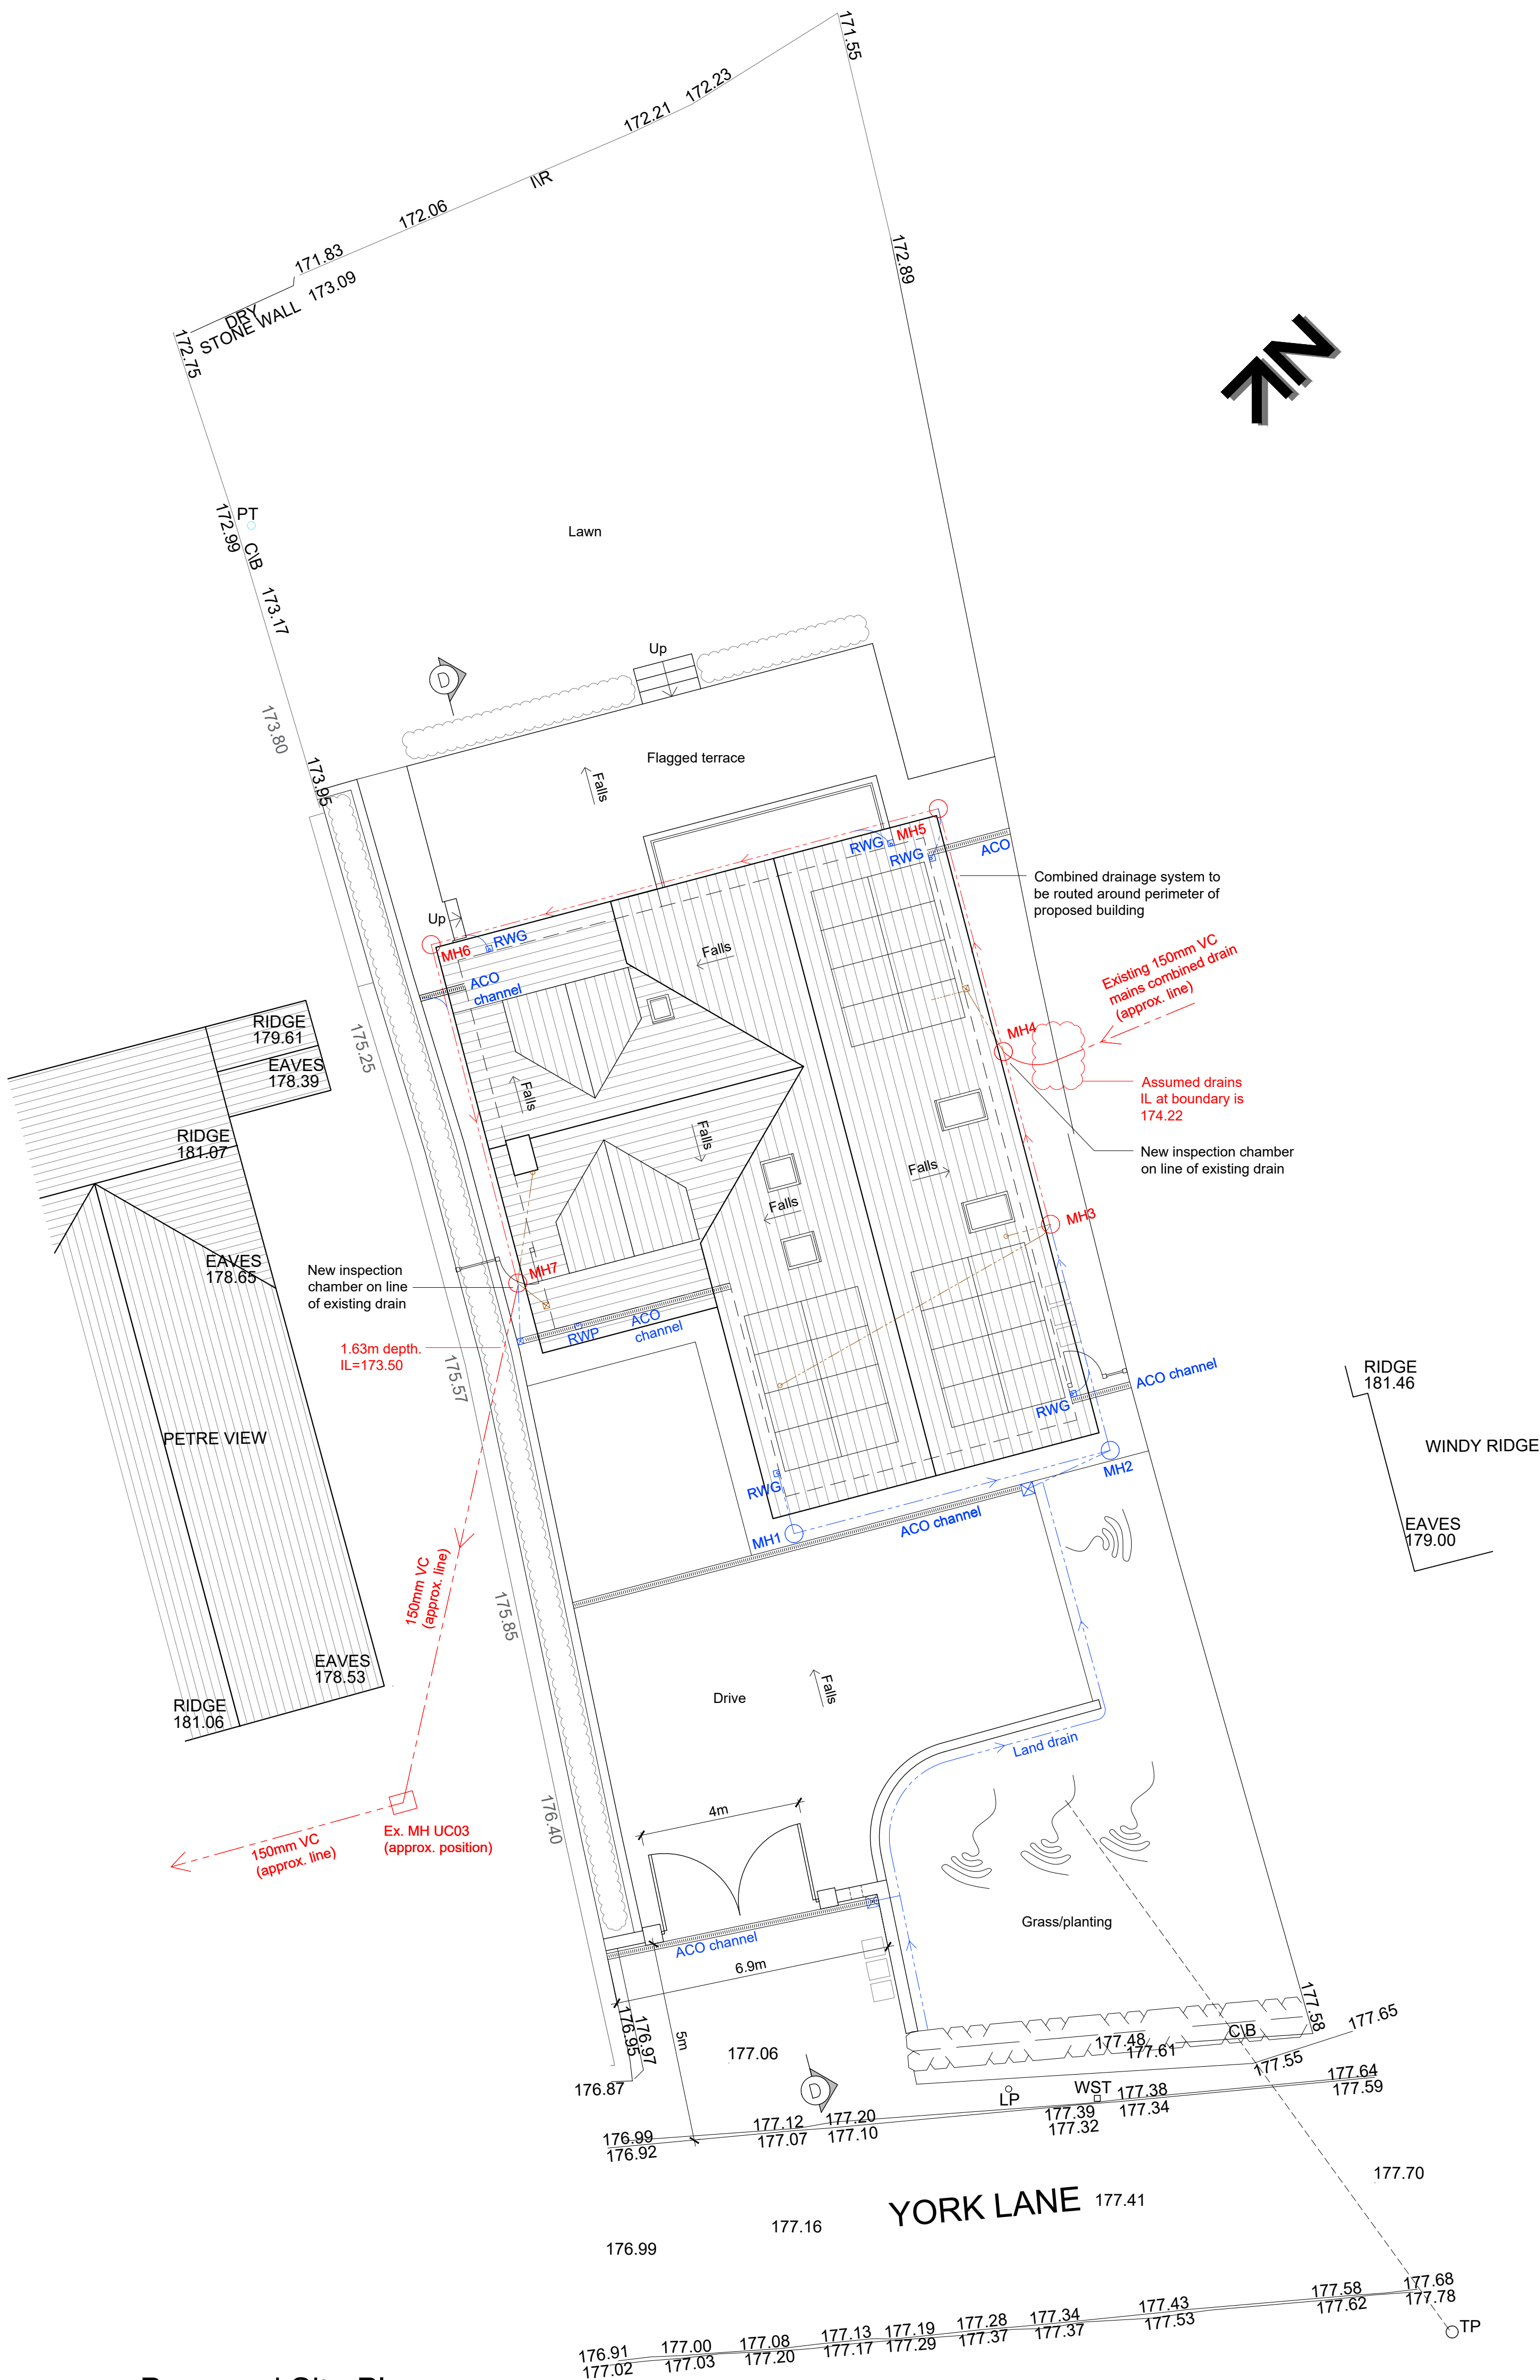


Proposed Site Plan

1:100 Scale



Extract of United Utilities' sewer record plan (NTS).
Plan shows approximate position of existing combined drainage run through the site.

REVISIONS:
Rev A - Position of soakaway amended. - 16.08.23 - NE
Rev B - Garage omitted. - 18.08.23 - NE
Rev C - Drainage strategy amended. - 13.09.23 - NE

Client Mr J Croak and Miss C Seal		
Job Title Proposed New Replacement Dwelling at Overdale York Lane Langho. BB6 8DT		
Drawing Title Proposed Site Drainage Strategy Plan		
PLANNING		
Scale 1:100 @ A1	Date June 2023	Drawn NE
 SUNDERLAND PEACOCK & ASSOCIATES LTD. HAZELBERRY, PEARCE ROAD, GLITHEROE LANCASHIRE, BB7 2AG T 01200 423178 F 01200 427328 E info@sunderlandpeacock.com www.sunderlandpeacock.com		