




Typical Section Thro' Filter Drain (Section A-A)
Scale 1:20

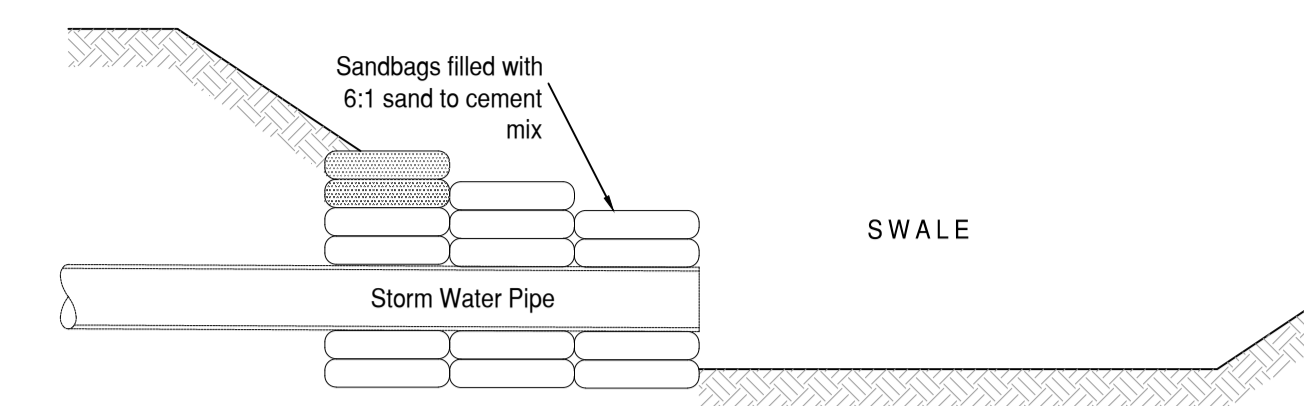


Typical Sandbag Headwall Detail
Scale 1:20

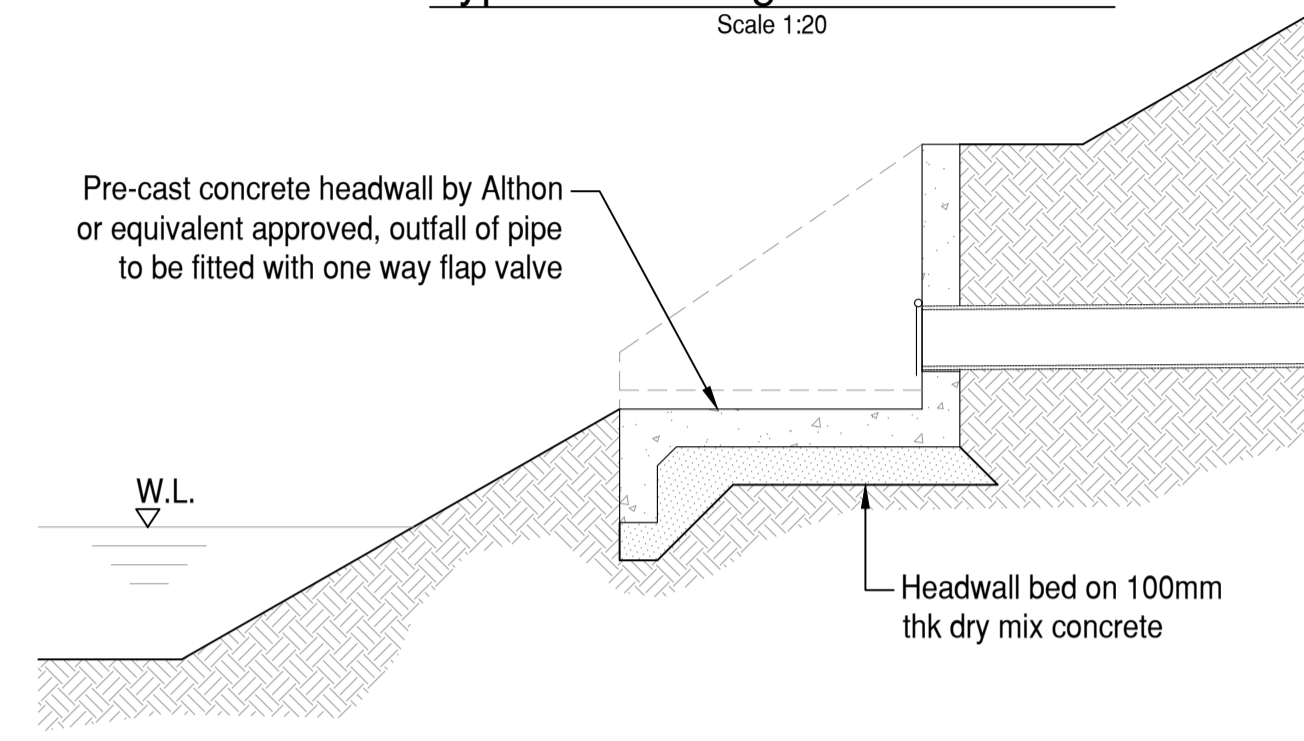


Typical Concrete Headwall Detail
Scale 1:20

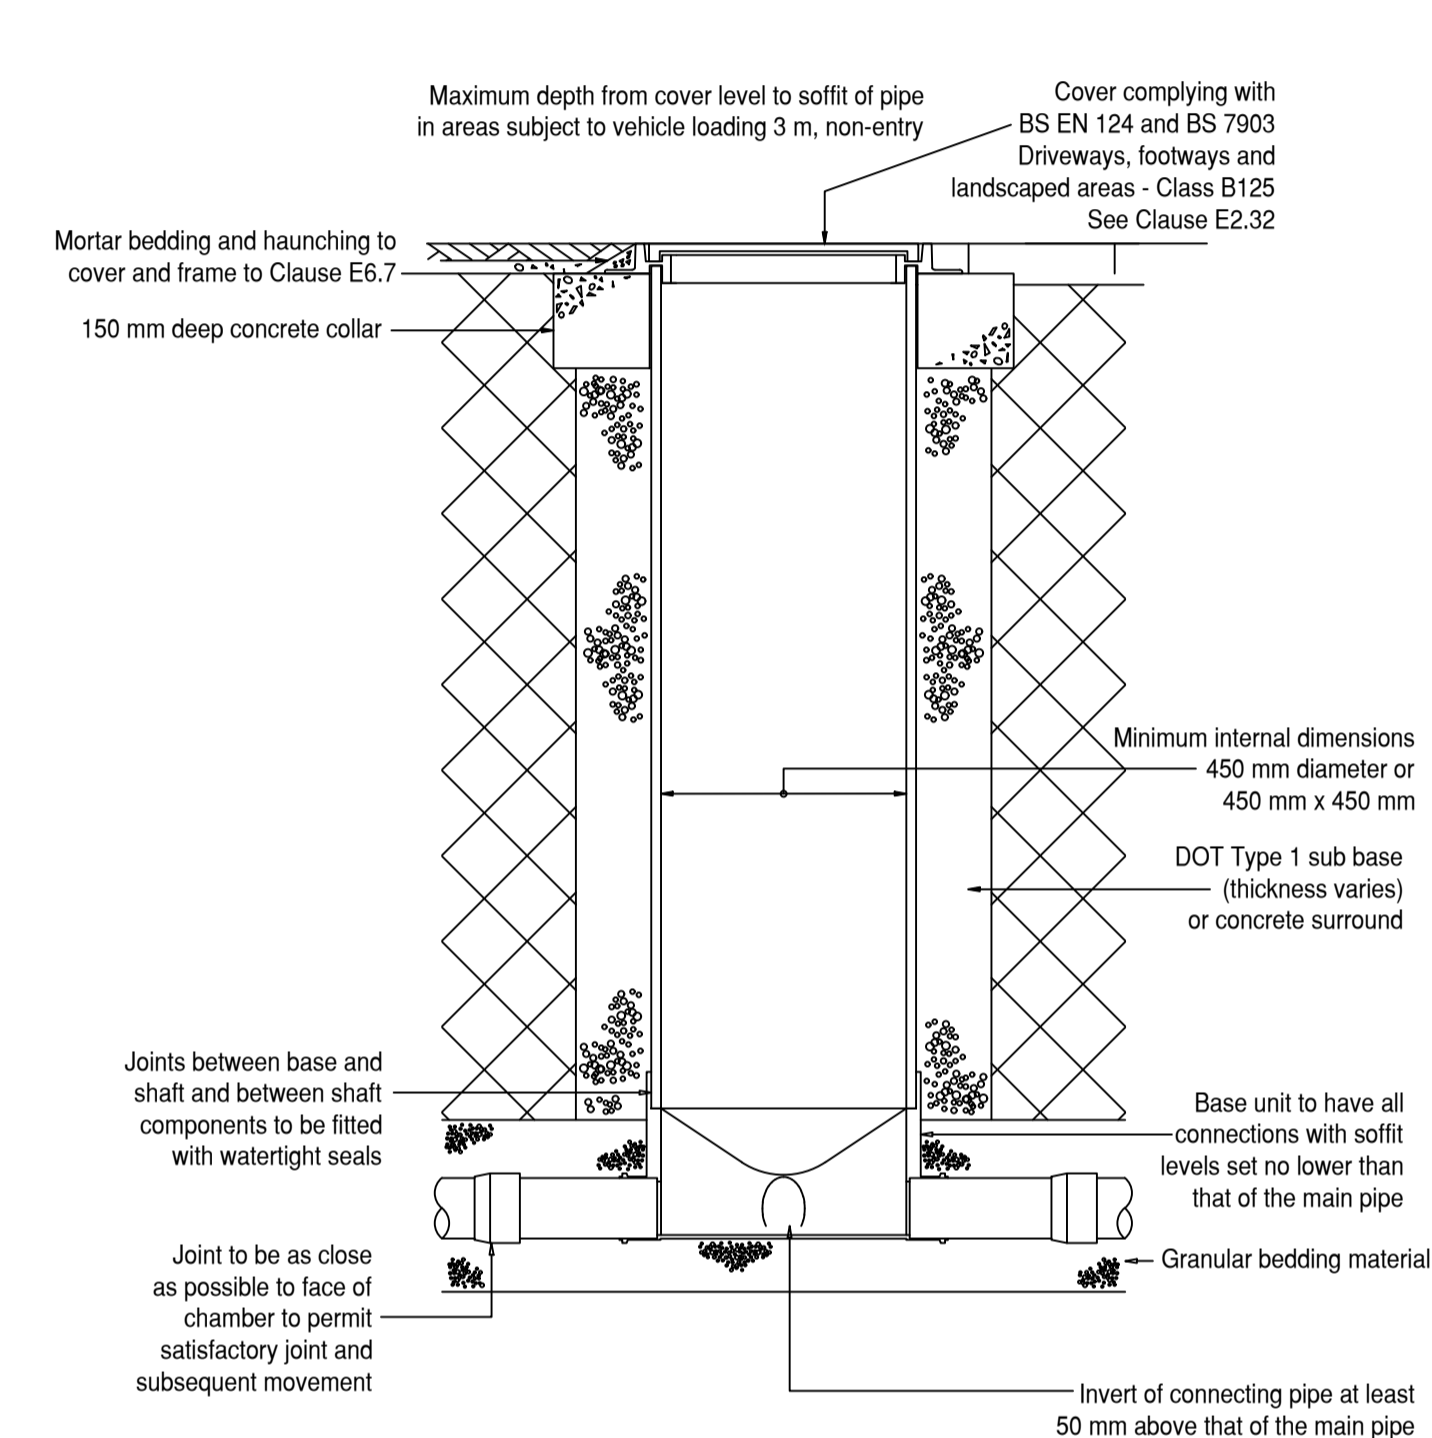


Typical Inspection Chamber Detail (Flecible Material Detail)
NTS

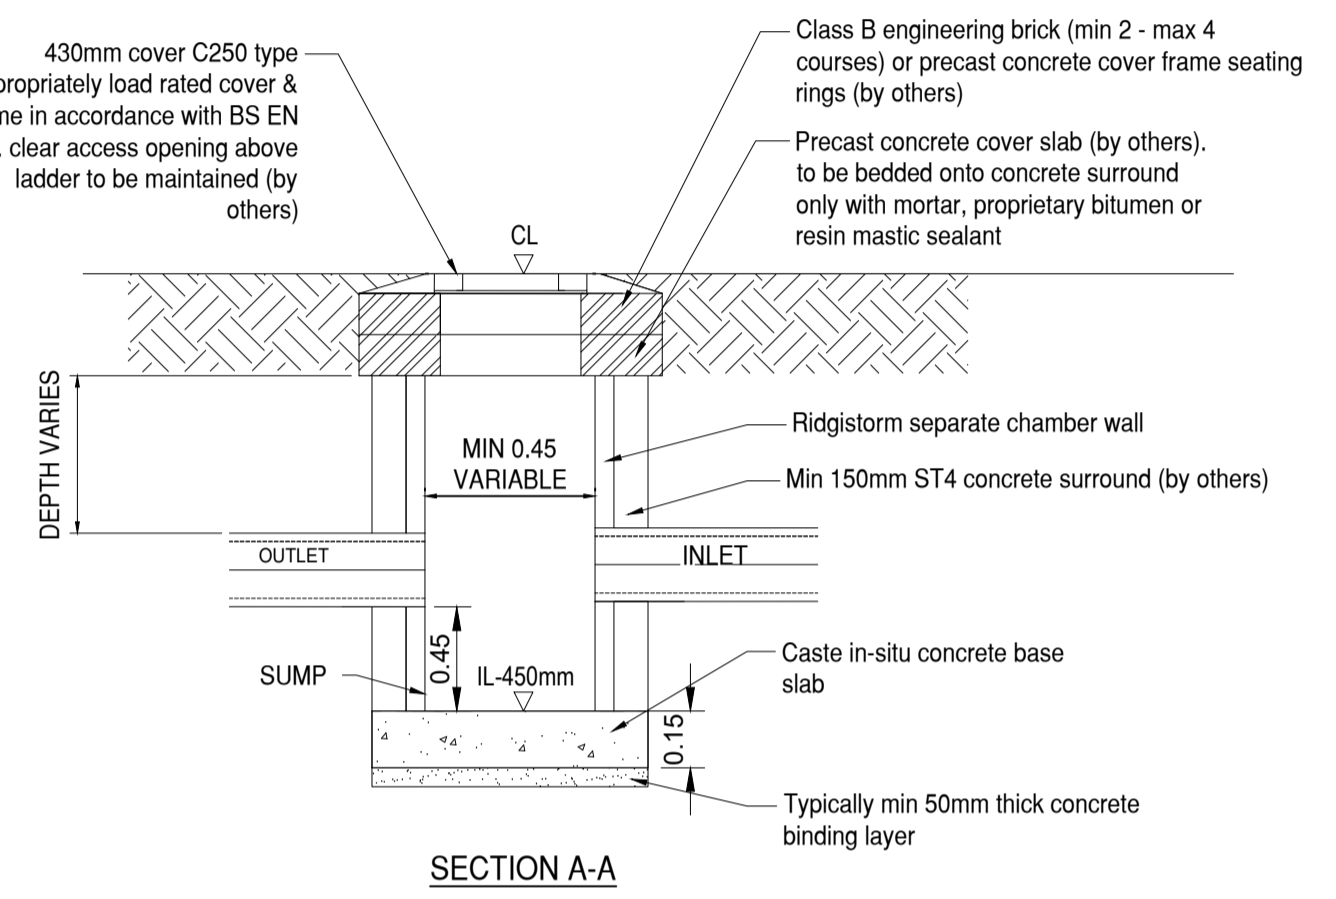


Ridgistorm Separate Catchpit
NTS

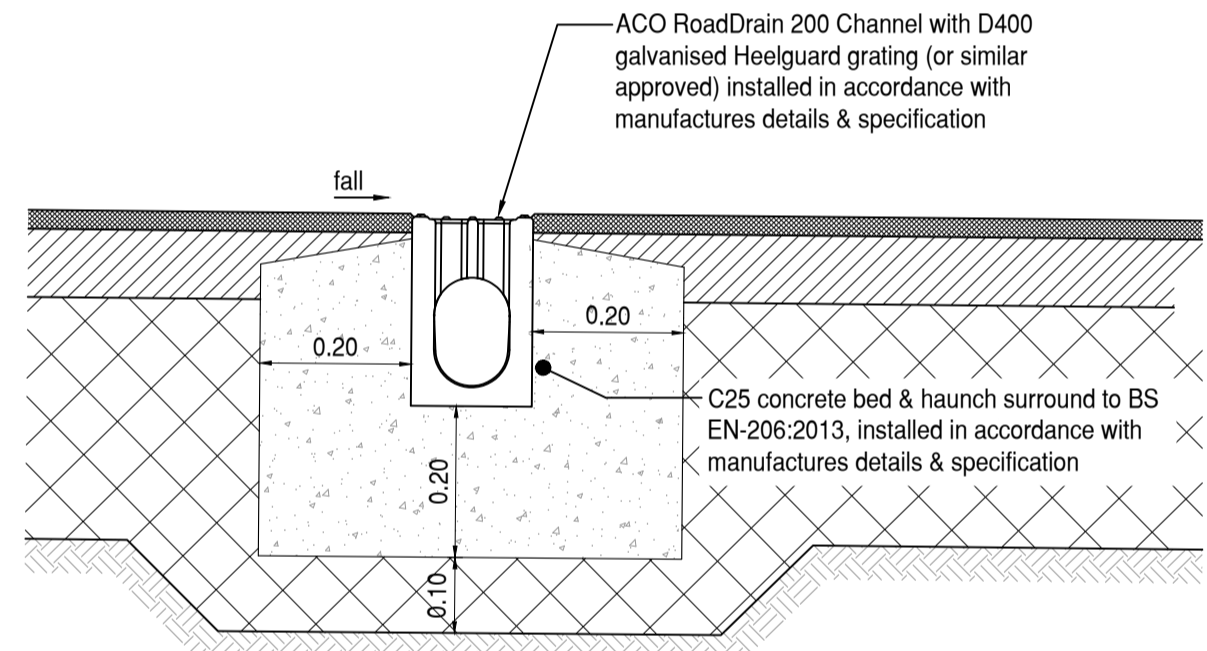

ACO RoadDrain Detail
NTS

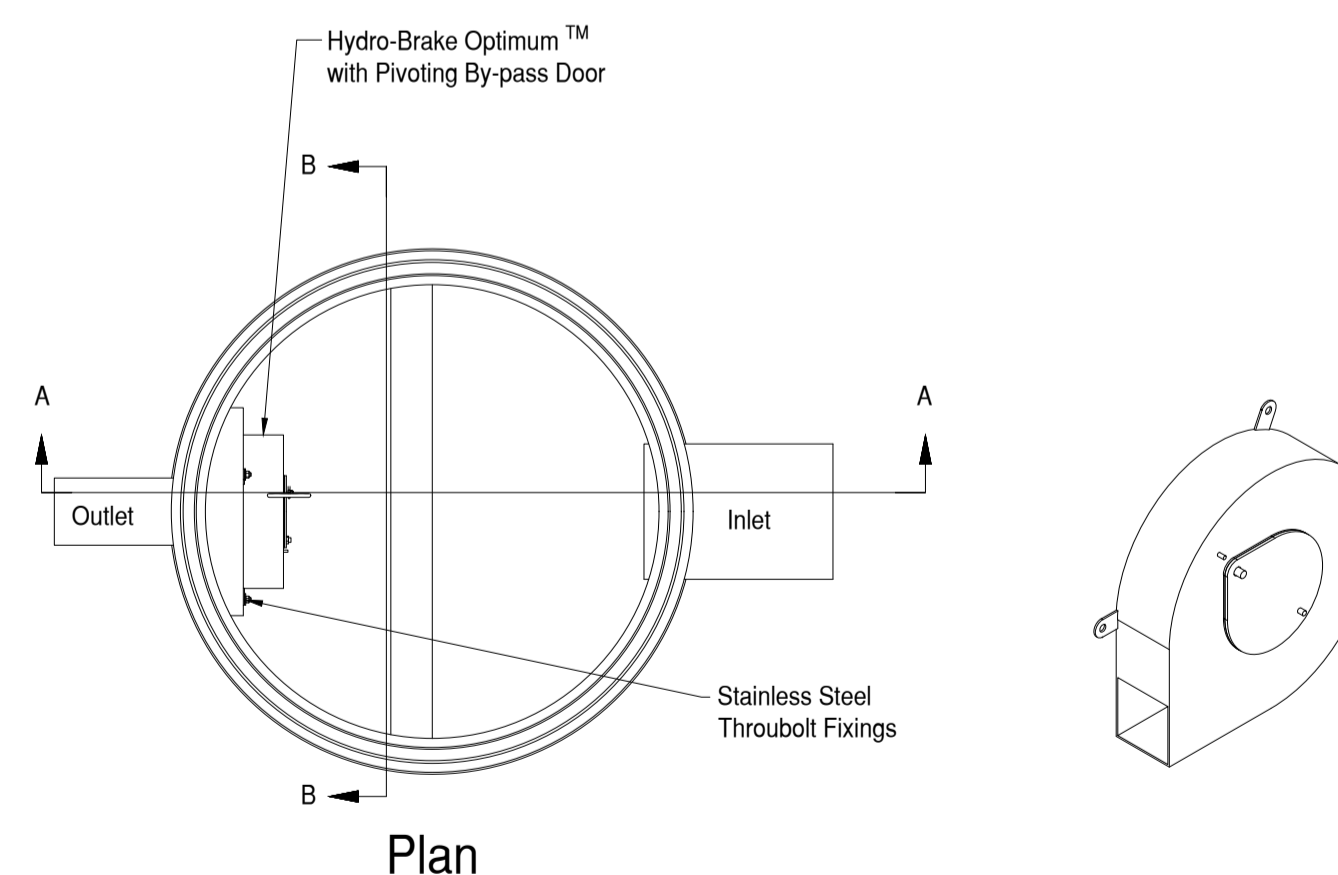

Typical Hydrobrake Chamber Detail With Overflow Pipe
Scale 1:20

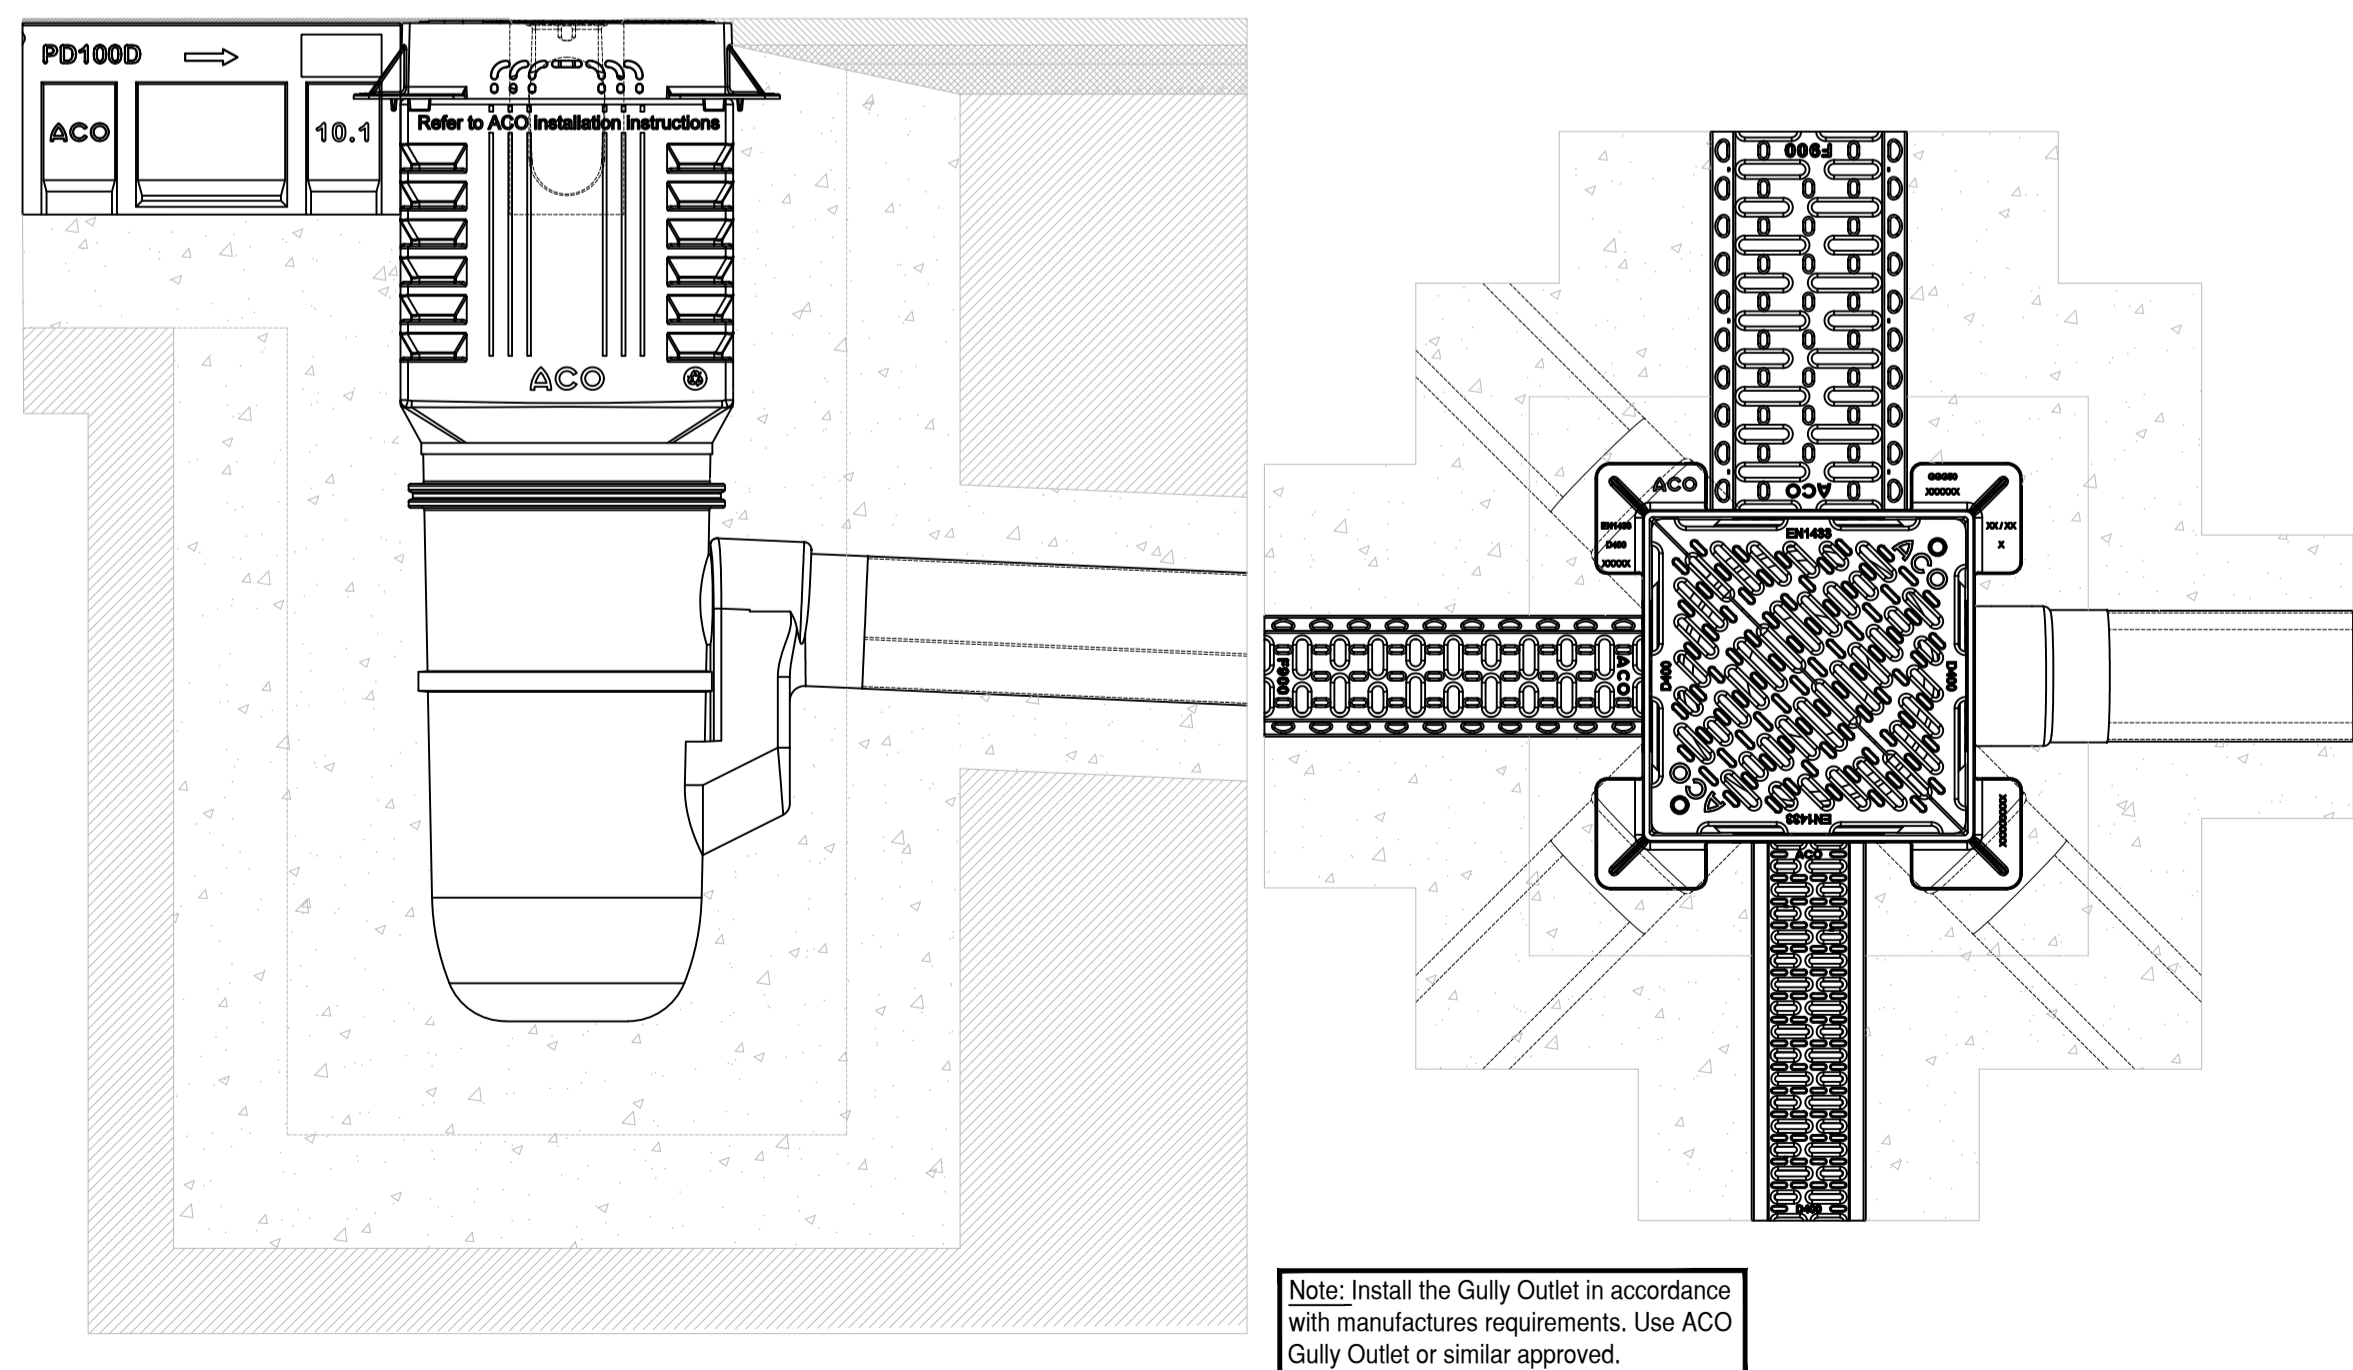

ACO Gully Outlet Details
NTS

Safety, Health & Environmental Information:
In addition to the hazards and risks normally associated with the types of work detailed on this drawing, please note the significant hazards identified by symbols below.

⚠ INDICATES A RESIDUAL RISK AS A WARNING

ℹ INDICATES A RESIDUAL RISK FOR INFORMATION and described below:

Construction/Maintenance/Cleaning/Demolition
Refer to Drawing:

- General Notes:**
- Do not scale from this drawing.
 - All dimensions are in millimetres (mm), all levels in metres (m) unless noted otherwise.
 - Discrepancies or omissions are to be reported to the Engineer prior to work commencing.
 - Materials and workmanship are to comply in all respects with current British Standard Specifications, Codes of Practice, and Building Regulations Approved Documents.
 - The copyright of this drawing is vested in the Engineer and must not be copied or reproduced without written consent.
 - The Contractor is to check and verify all building and site dimensions, levels and sewer invert levels at connection points before work commences.
 - This drawing is to be read in conjunction with all relevant specifications and drawings issued by the Engineer, Architect and other Specialists.
 - For drainage plans refer to drawing:
- RCF-BML-ERD-ZZ-DR-C-0550 Combined Drainage Layout

PRELIMINARY DRAWING
This drawing is not to be used for construction

Rev	By	Chk'd	Date	Description
P01	RA	GM	13/04/23	Preliminary

Client

BarnsleyMarshall Limited
1 Birch Court
Blackpole East
Worcester
WR3 8SG

Tel: 01905 330550
Email: design@barnsleymarshall.co.uk

BarnsleyMarshall

Project
Cow Shed
Elmridge Lane, Preston,
PR3 2NY

Drawing
Drainage Details
Sheet 2 of 2

Drawn by	Date
Checked by RA/GM	Date 05/04/2023

Drawing No. **CSH-BML-XX-XX-DR-C-0502** | P01
BML Job No.
1000-05

Drawing Scale at A1: NTS
CAD Filename: