


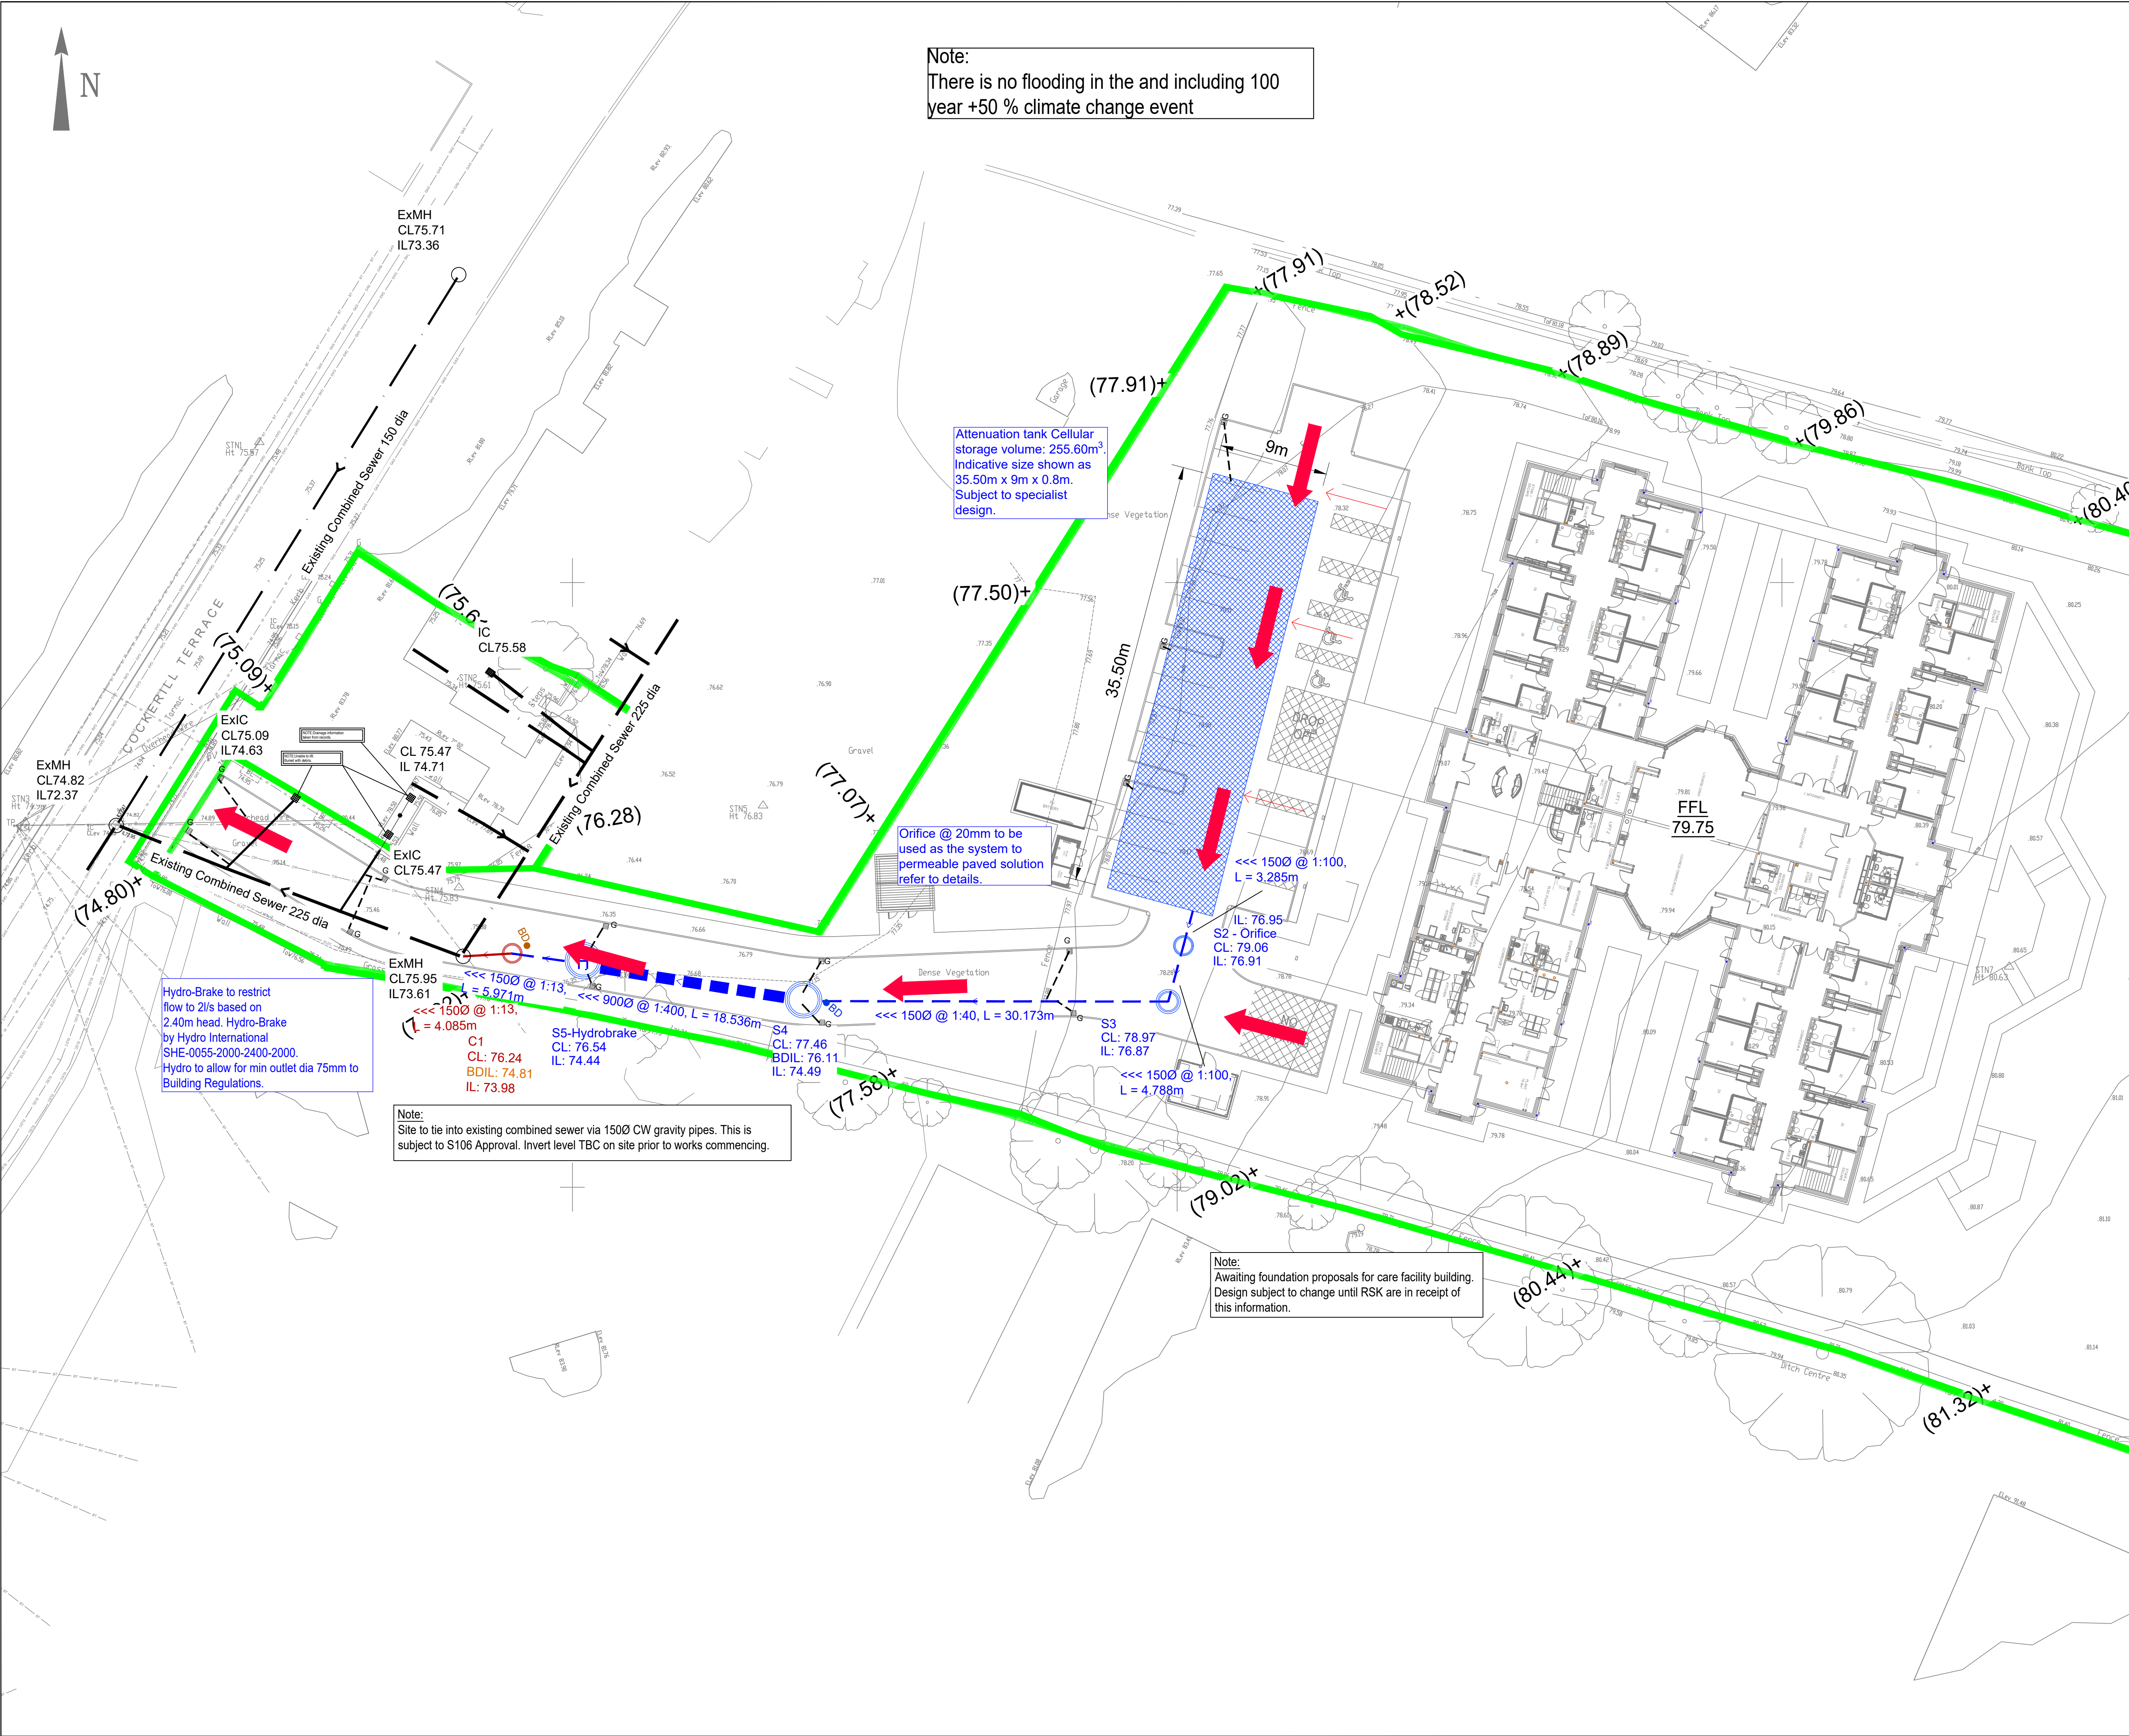

CIVIL / STRUCTURAL DESIGN RISK MANAGEMENT

Abnormal or unusual residual risks associated with the design outcomes shown on this drawing are:-

RSK LDE LTD has followed its Design Risk Management process for Hazard Elimination and Risk reduction in developing the designs shown on this drawing. Abnormal or unusual residual risks may be shown above where it is considered that such risk may not normally be expected by competent persons engaged on work of this nature or type.

Notes:

1. This drawing is to be read in conjunction with all relevant Architect's and Engineer's drawings.

2. All levels quoted are in metres A.O.D.

3. The drainage and storage design assumes the catchments as shown these may be subject to change.

4. For complete drainage layout see drawing 10-01.

Legend

Proposed Surface Water drain and manhole

Exceedance flow route

Development Boundary

P3	04.10.23	Updated to new layout and receipt of existing sewer records	MS		
P2	21.08.23	Updated following LLFA comments	MH	MS	
P1	01.06.23	First Issue	MH	MS	
Rev.	Date	Amendment	Drawn	Chkd.	Appd.

RSK

LAND & DEVELOPMENT ENGINEERING LTD

Spring Lodge
172 Chester Road
Helsby
Cheshire, WA6 0AR
United Kingdom

Tel: +44 (0) 1928 726006
Fax: +44 (0) 1928 725633
Email: ldes@rsk.co.uk
Web: www.rsk.co.uk

Client

LNT Construction

Project Title

Whalley Road
Barrow

Status

INFORMATION

Drawing Title

Flood Routing Plan

Drawn	Date	Checked	Date	Approved	Date
MH	May 23	MS	May 23		
Scale	1:250	Orig Size	A1	Dimensions	
Project No.	882667	Drawing File			
Drawing No.	10-09	Rev.	P3		