


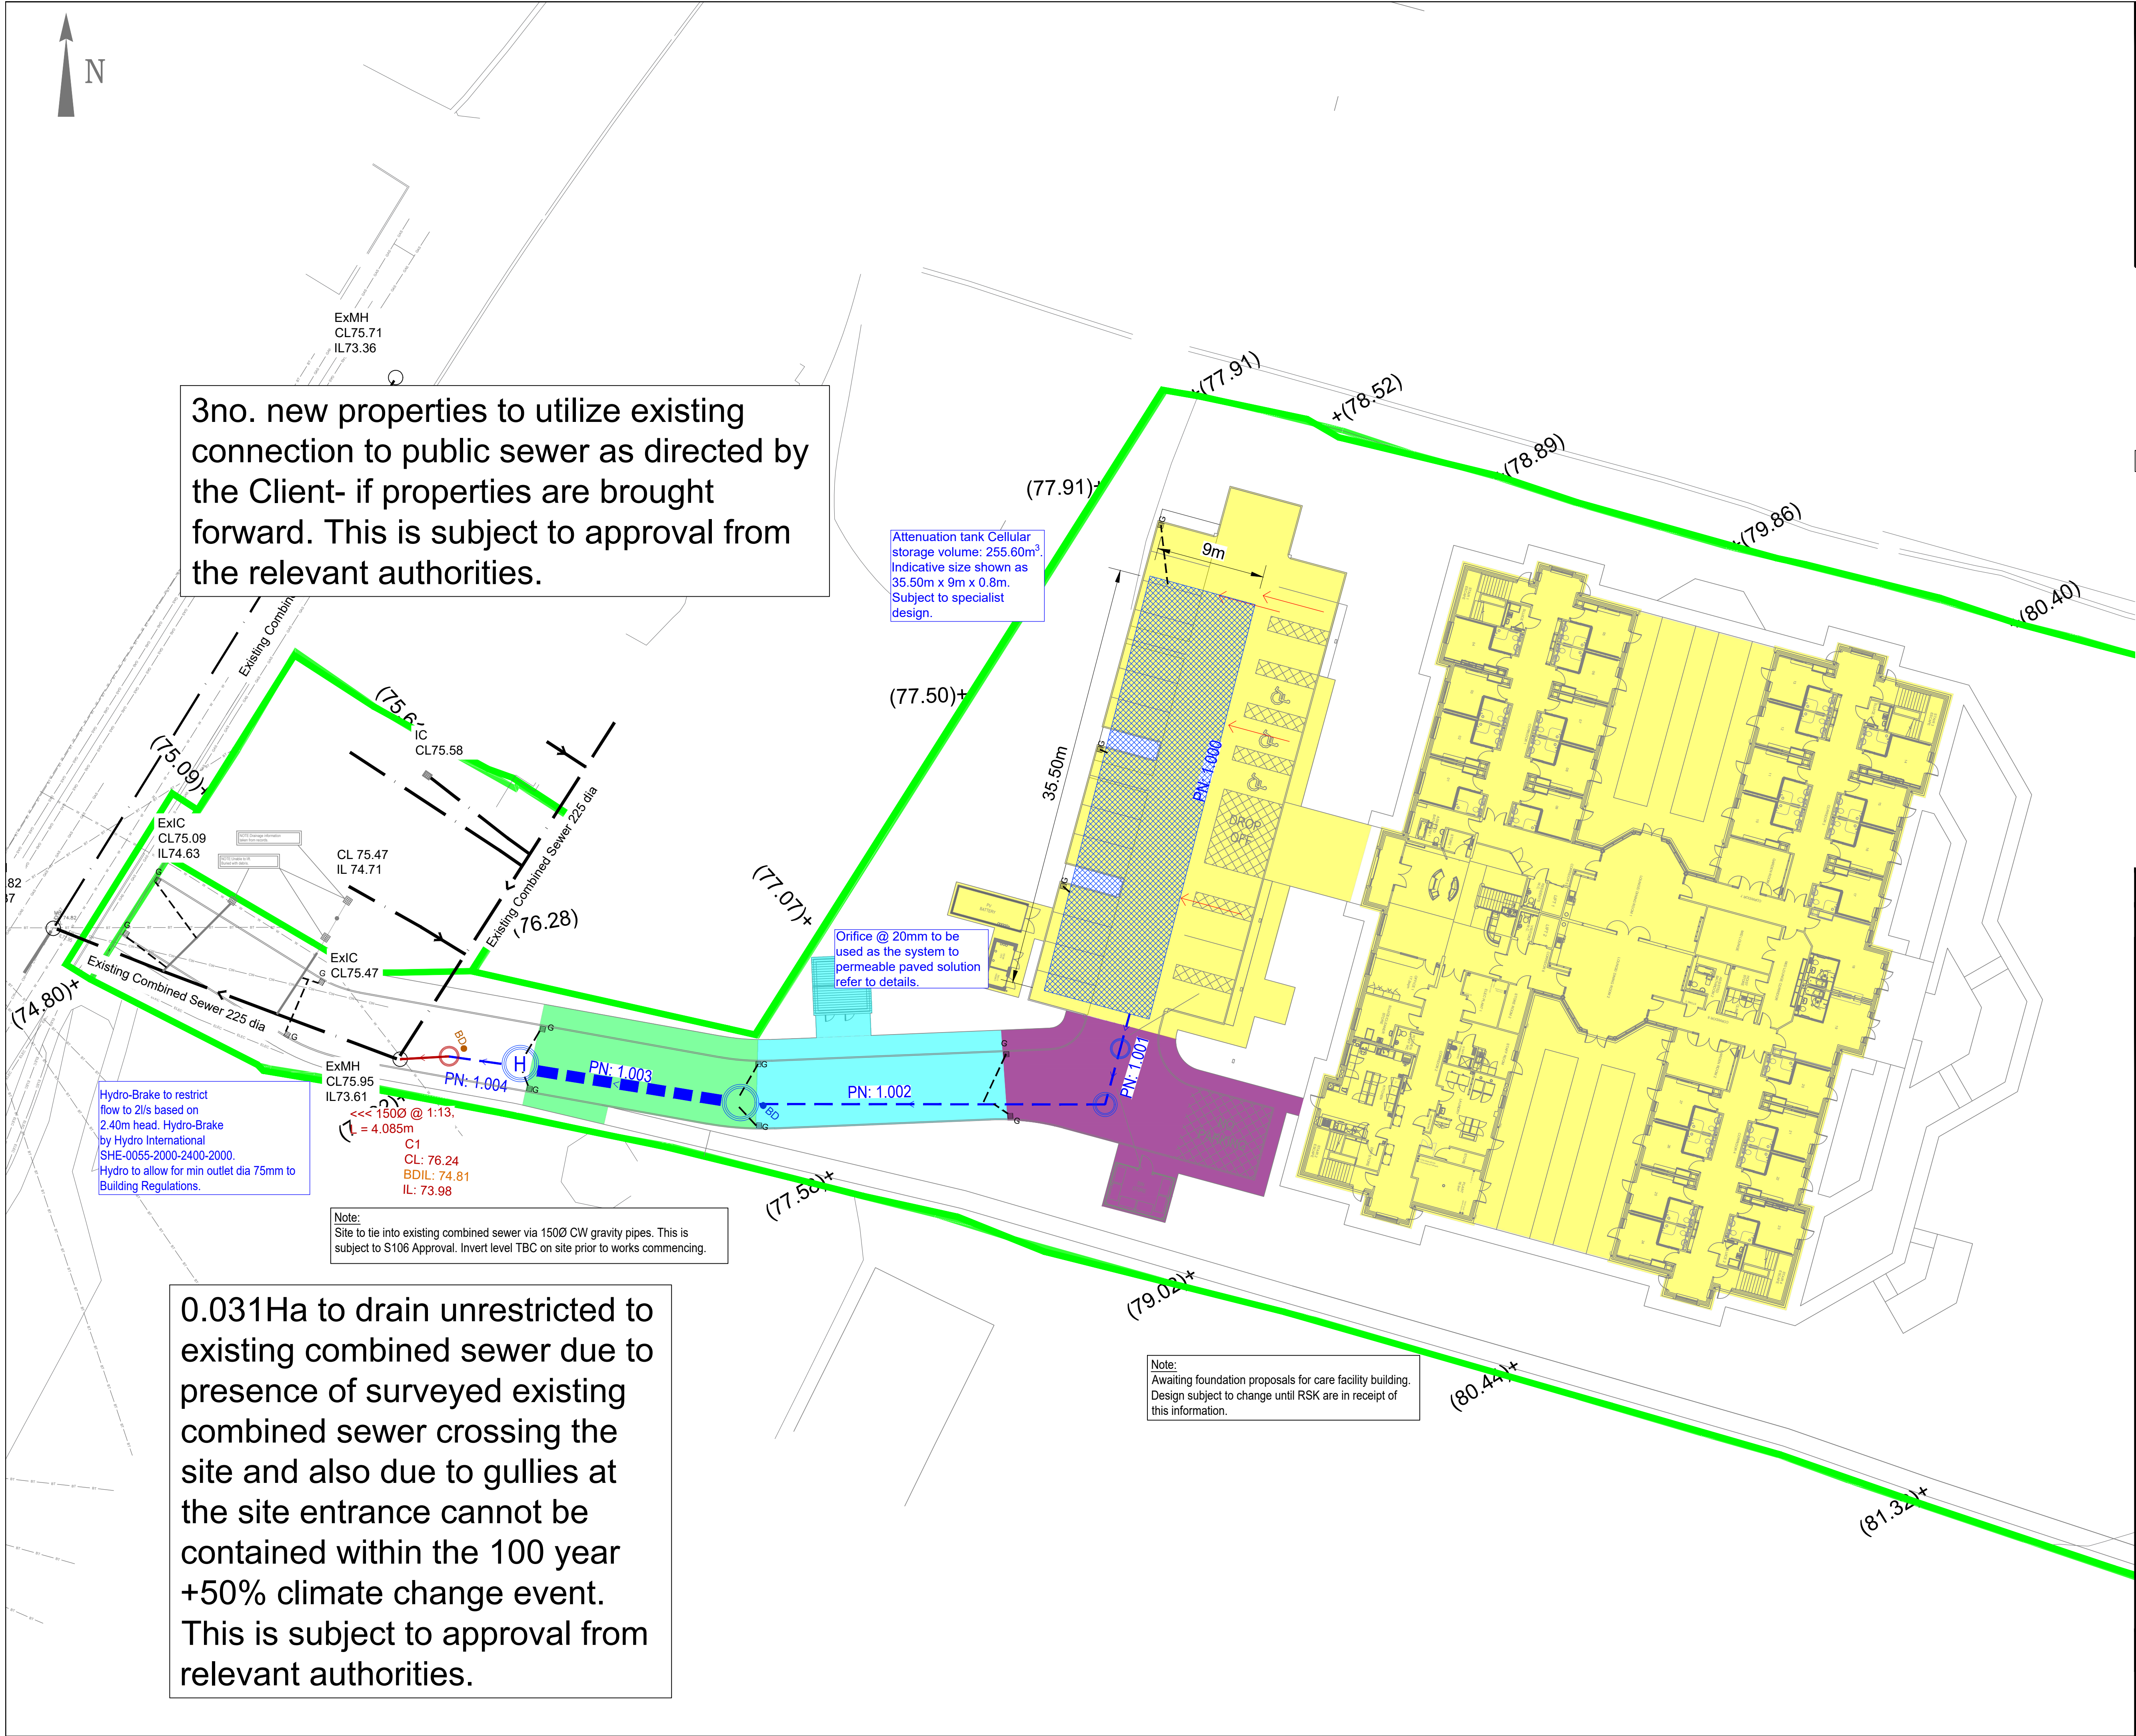

CIVIL / STRUCTURAL DESIGN RISK MANAGEMENT

Abnormal or unusual residual risks associated with the design outcomes shown on this drawing are:-

RSK LDE LTD has followed its Design Risk Management process for Hazard Elimination and Risk reduction in developing the designs shown on this drawing. Abnormal or unusual residual risks may be shown above where it is considered that such risk may not normally be expected by competent persons engaged on work of this nature or type.

Notes:

1. This drawing is to be read in conjunction with all relevant Architect's and Engineer's drawings.

2. All levels quoted are in metres A.O.D.

3. The drainage and storage design assumes the catchments as shown these may be subject to change.

4. For drainage layout please see RSK drawing '10-01'

Legend

Proposed Surface Water sewer and manhole

Proposed Combined Water sewer and manhole

Existing Combined Water sewer and manhole

PN1.000 - 0.310Ha

PN1.001 - 0.000Ha

PN1.002 - 0.024Ha

PN1.003 - 0.018Ha

PN1.004 - 0.015Ha

TOTAL IMPERMEABLE AREA = 0.367Ha

10% Urban Creep allowance has been included in calculations

Site Boundary

P3	10.10.23	Road gully note updated	MS		
P2	04.10.23	Updated to new layout and receipt of existing sewer records	DS	MS	
Rev.	Date	Amendment	Drawn	Chkd.	Appd.

RSK

LAND & DEVELOPMENT ENGINEERING LTD

Spring Lodge
172 Chester Road
Helsby
Cheshire, WA6 0AR
United Kingdom

Tel: +44 (0) 1928 726006
Fax: +44 (0) 1928 725633
Email: lda@rsk.co.uk
Web: www.rsk.co.uk

Client

LNT Construction

Project Title

Whalley Road
Barrow

Status

INFORMATION

Drawing Title

Impermeable Area Plan

Drawn MH	Date May 23	Checked MS	Date	Approved	Date
Scale 1:250	Orig Size A1	Dimensions			

Project No. 882667	Drawing File
Drawing No. 10-02	Rev. P3