



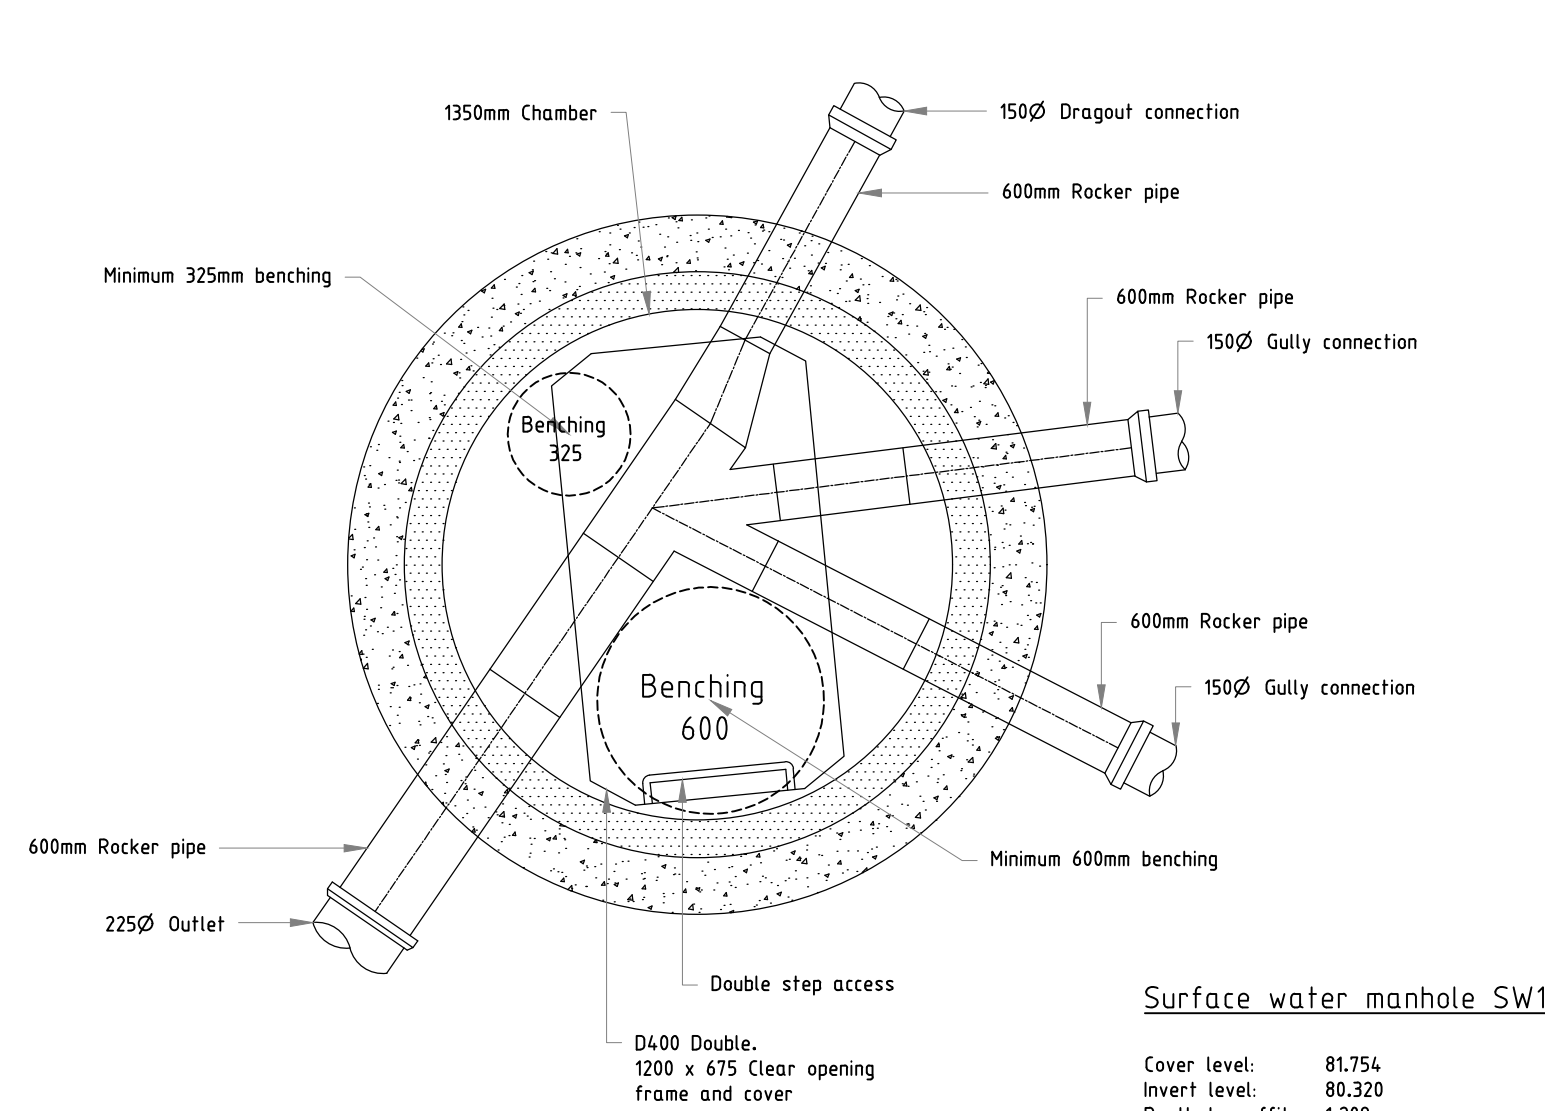


Surface water manhole SW1

Cover level: 81.754
Invert level: 80.320
Depth to soffit: 1.209
Manhole type: UU Type 4
Cover type: Double 1200 x 675 Clear Opening

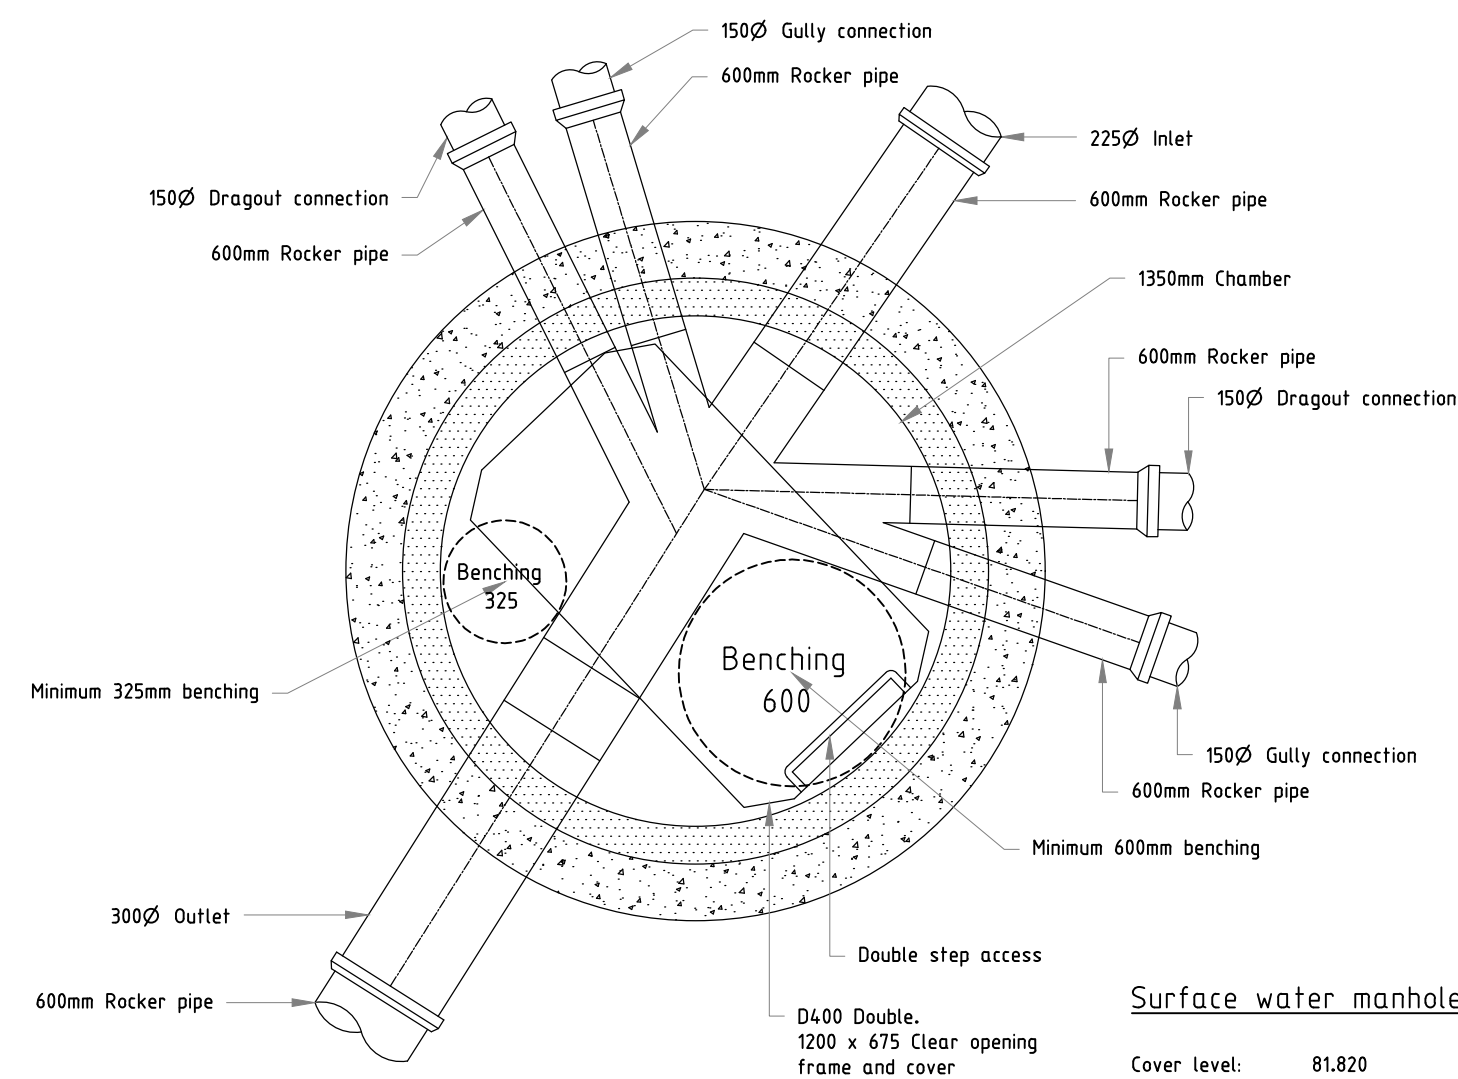


Surface water manhole SW2

Cover level: 81.820
Invert level: 225Ø: 80.209
300Ø: 80.134
Depth to soffit: 1.386
Manhole type: UU Type 4
Cover type: Double 1200 x 675 Clear Opening

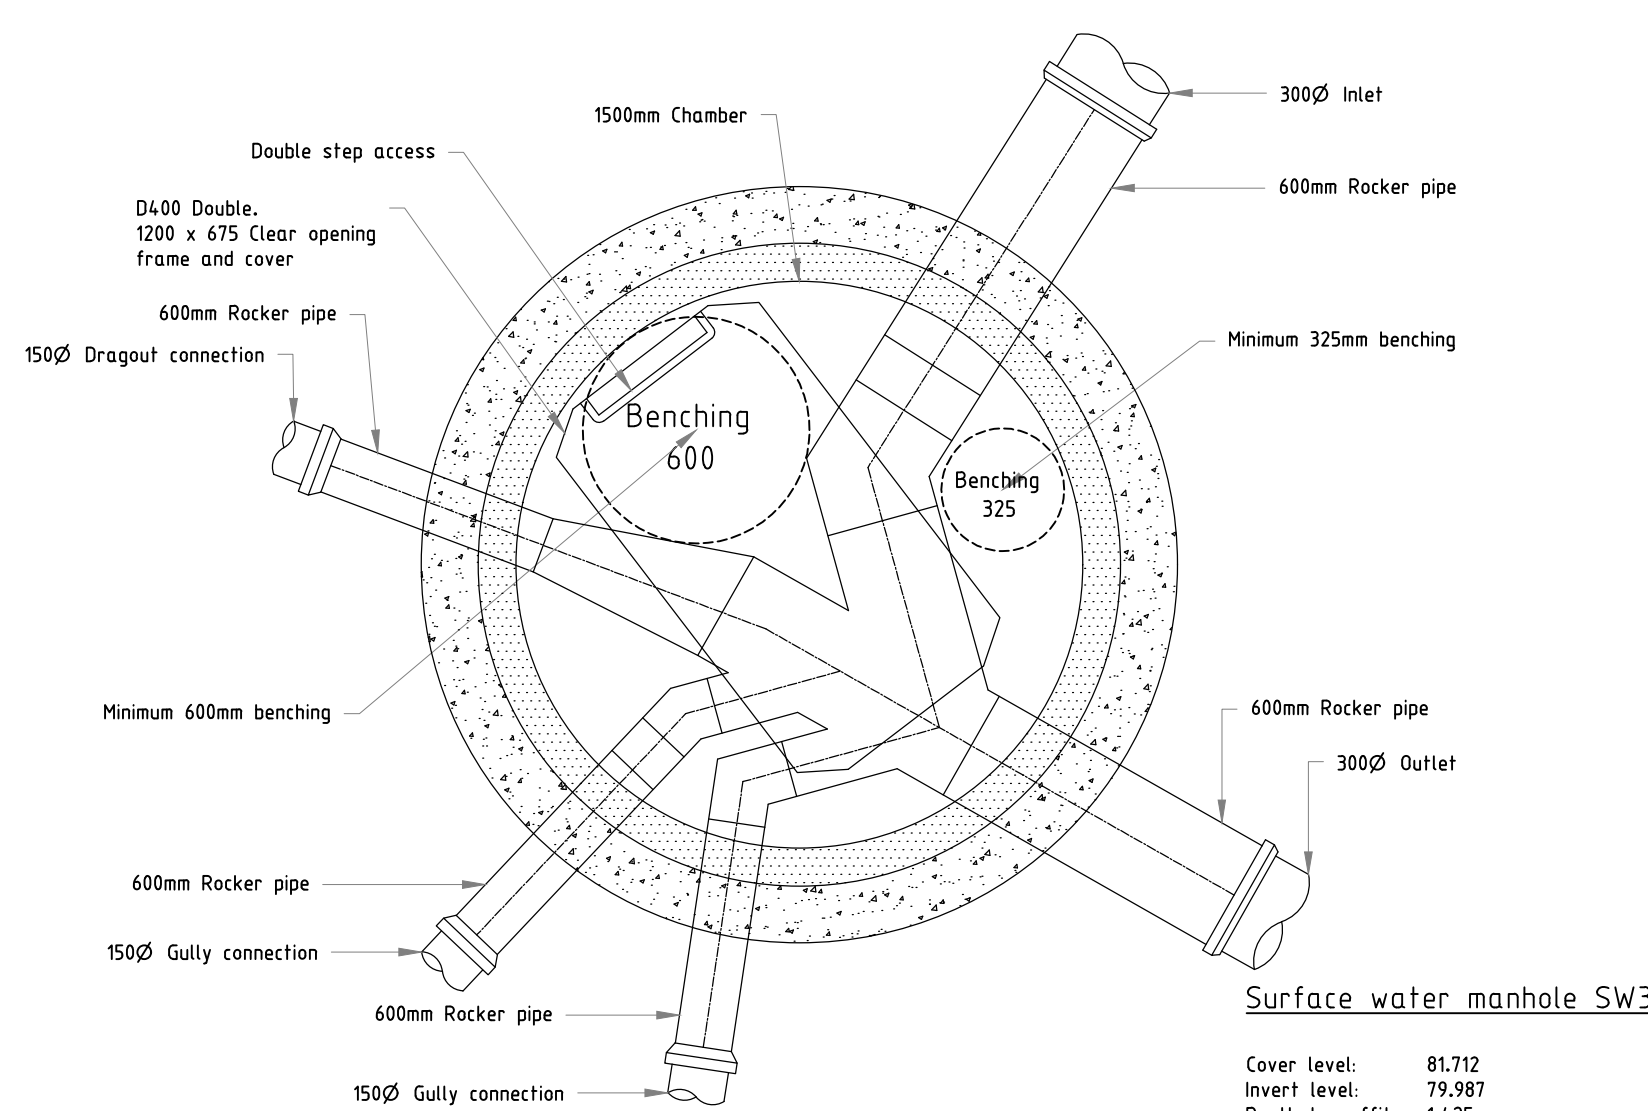


Surface water manhole SW3

Cover level: 81.712
Invert level: 79.987
Depth to soffit: 1.425
Manhole type: UU Type 4
Cover type: Double 1200 x 675 Clear Opening

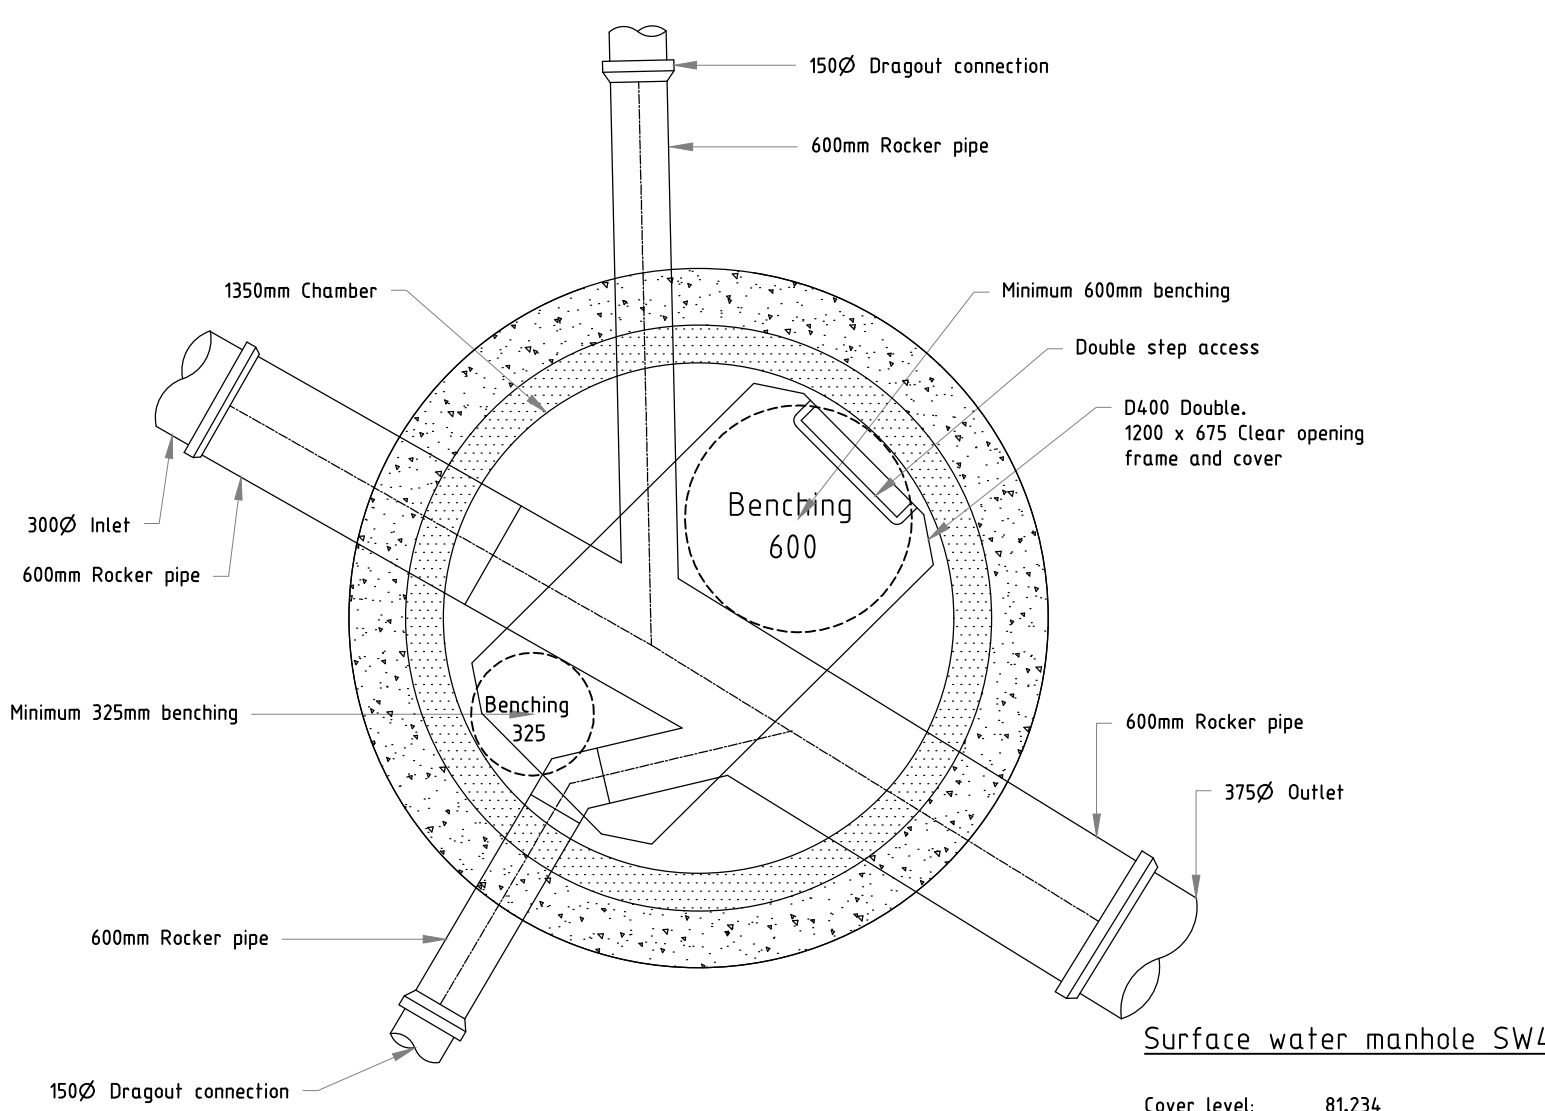


Surface water manhole SW4

Cover level: 81.224
Invert level: 300Ø: 79.734
375Ø: 79.659
Depth to soffit: 1.200
Manhole type: UU Type 4
Cover type: Double 1200 x 675 Clear Opening

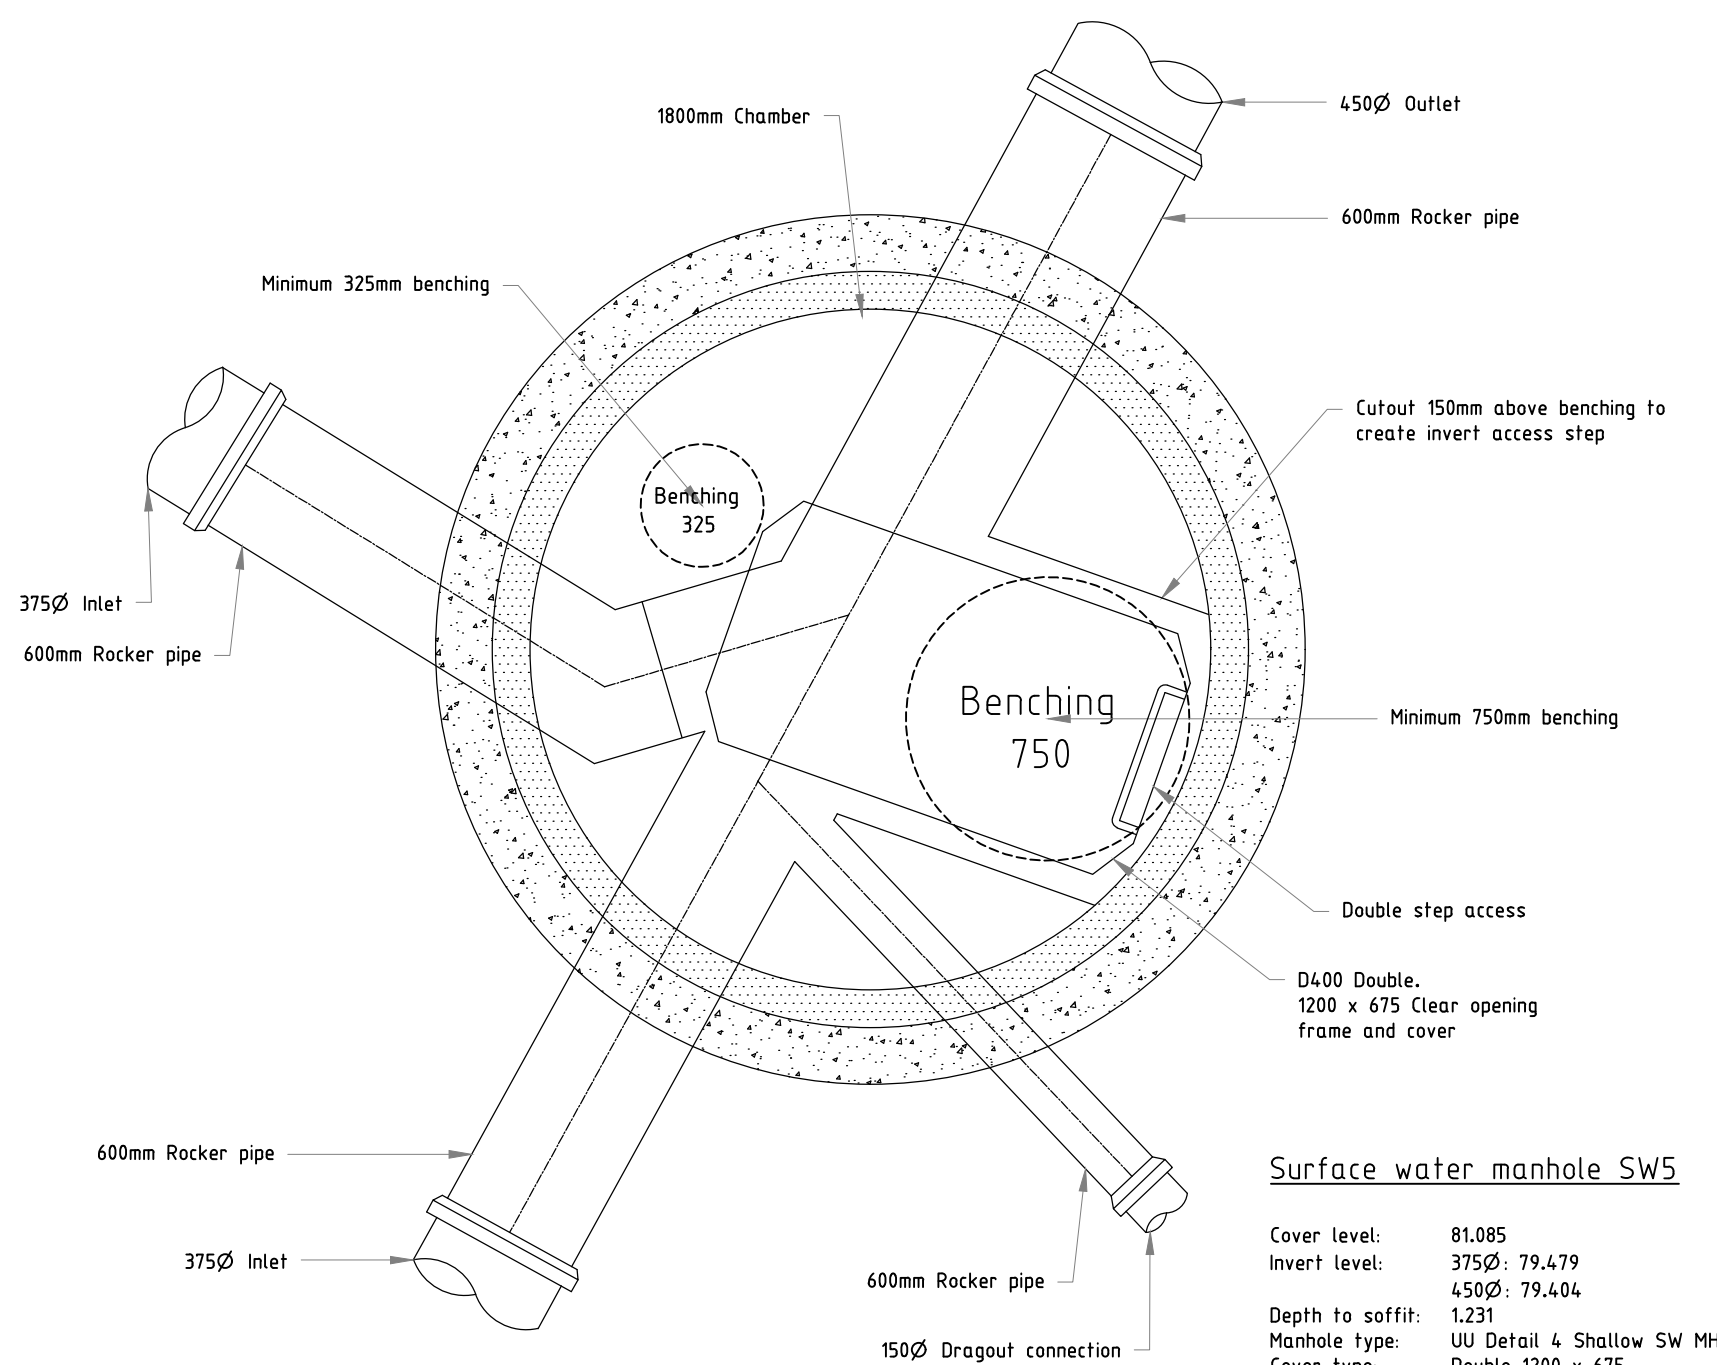


Surface water manhole SW5

Cover level: 81.805
Invert level: 375Ø: 79.479
450Ø: 79.404
Depth to soffit: 1.231
Manhole type: UU Detail 4 Shallow SW MH
Cover type: Double 1200 x 675 Clear Opening

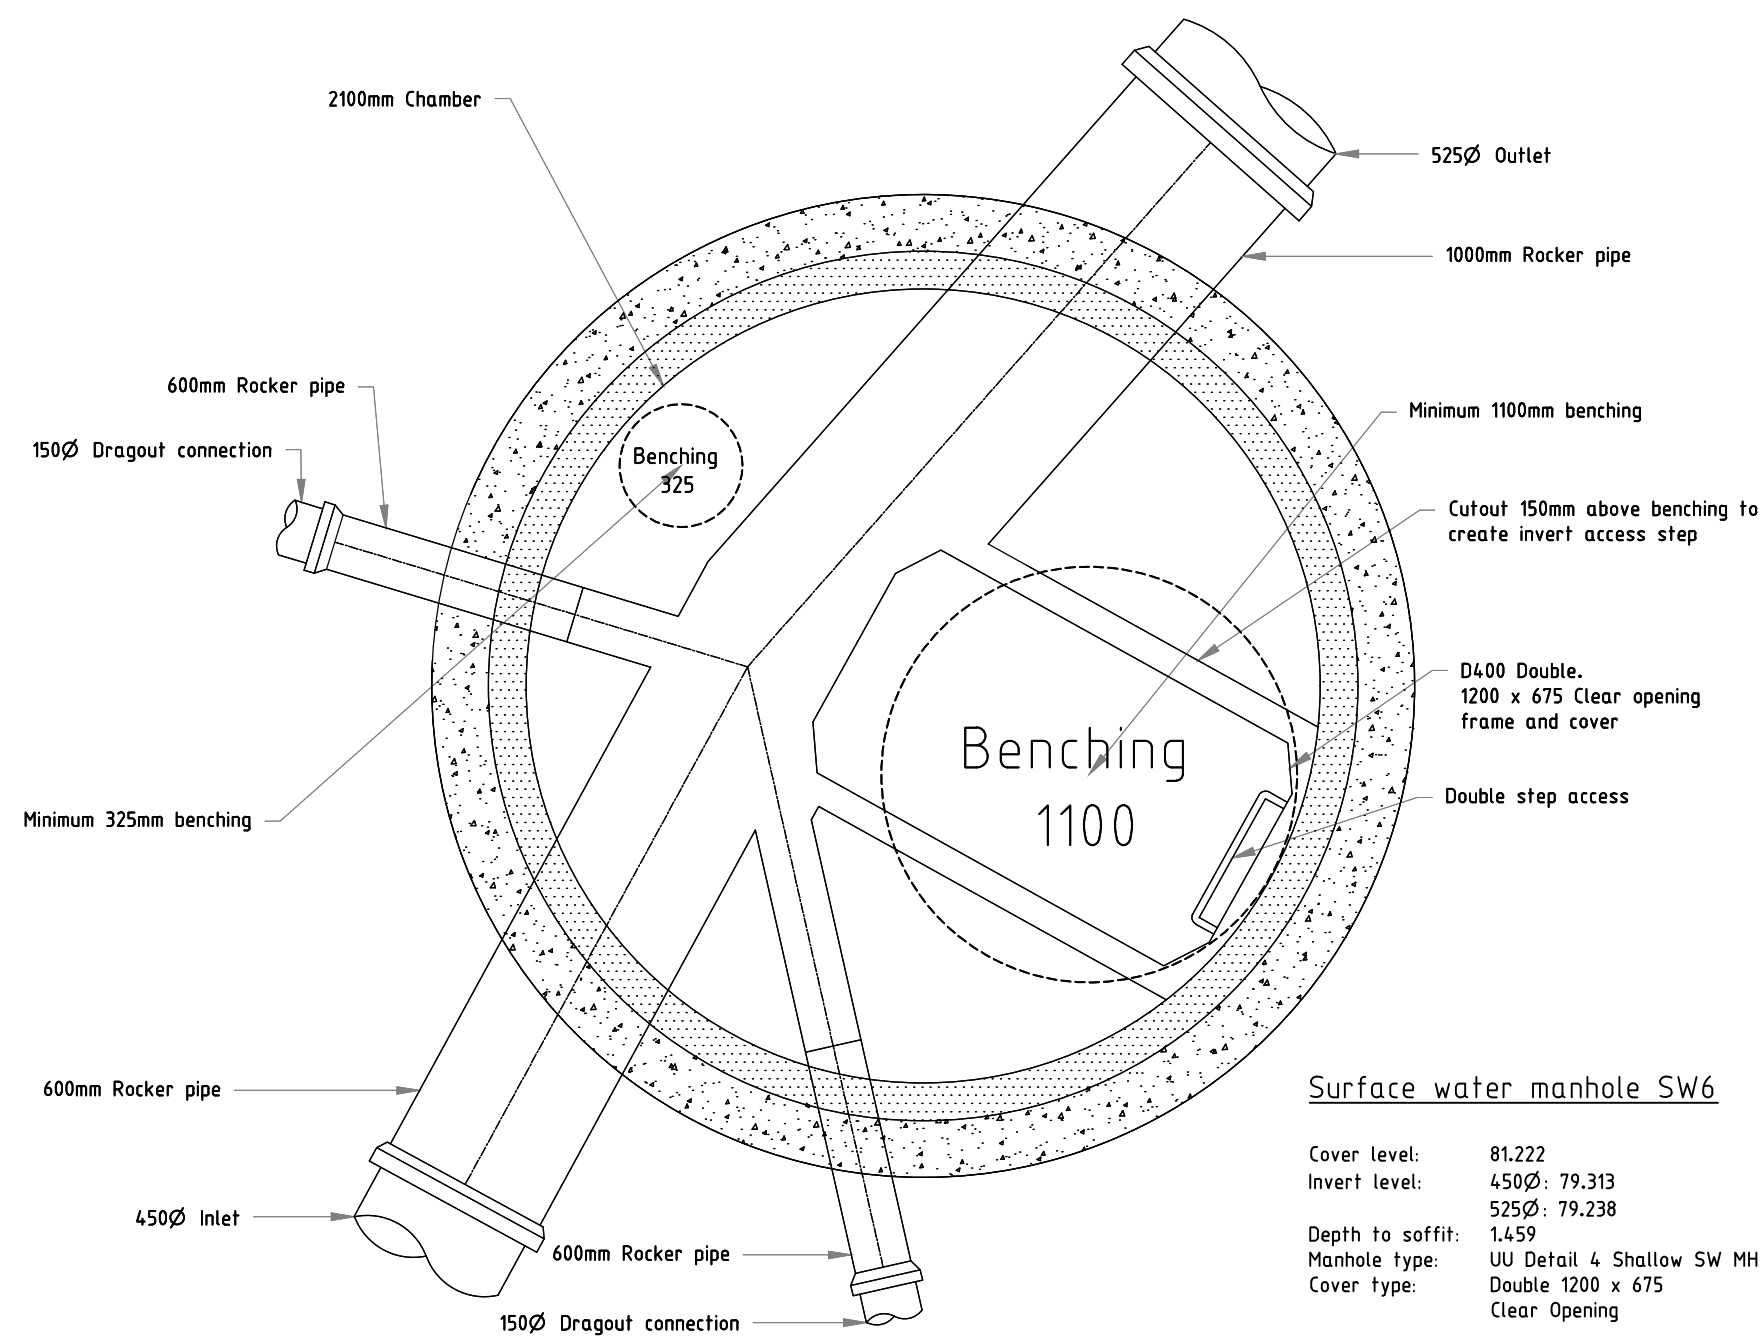


Surface water manhole SW6

Cover level: 81.222
Invert level: 450Ø: 79.319
525Ø: 79.238
Depth to soffit: 1.459
Manhole type: UU Detail 4 Shallow SW MH
Cover type: Double 1200 x 675 Clear Opening

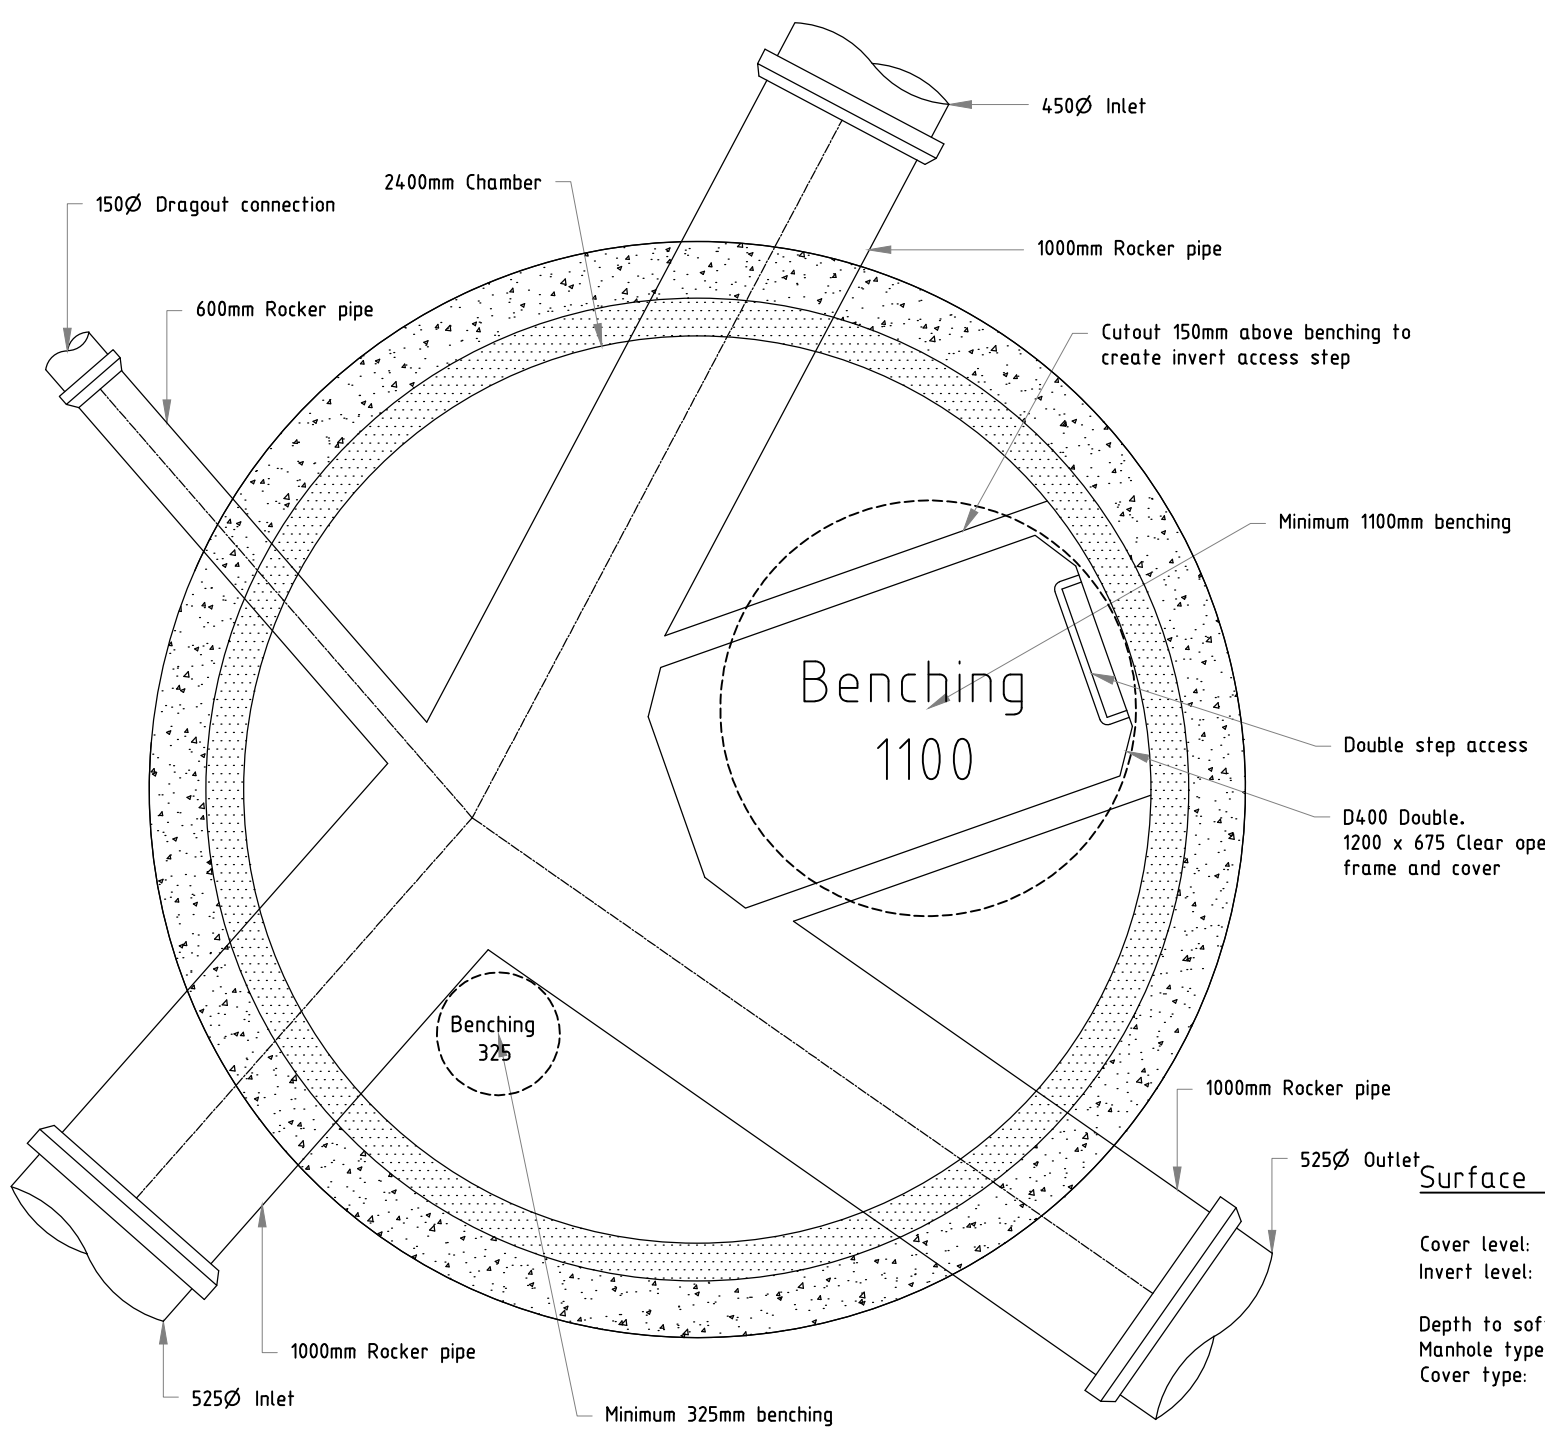


Surface water manhole SW7

Cover level: 81.813
Invert level: 525Ø: 79.194
450Ø: 79.269
Depth to soffit: 1.324
Manhole type: UU Detail 4 Shallow SW MH
Cover type: Double 1200 x 675 Clear Opening

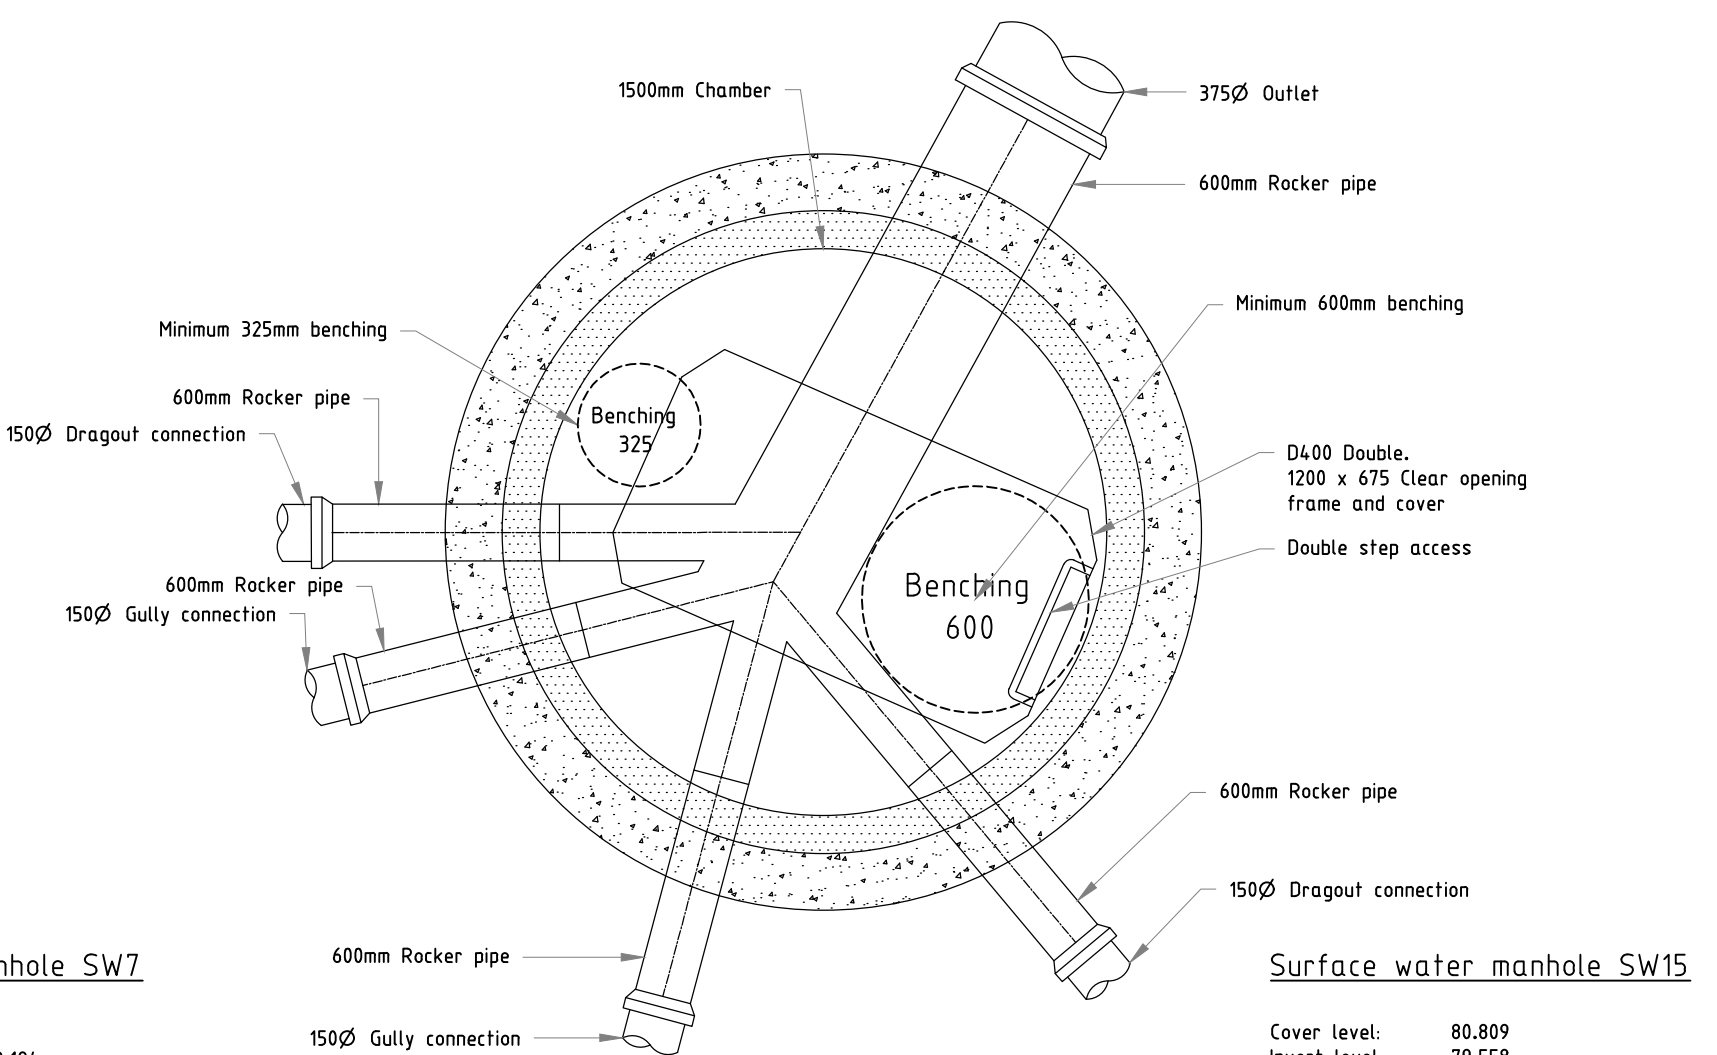

Surface water manhole SW15

Cover level: 80.809
Invert level: 375Ø: 79.558
Depth to soffit: 0.876
Manhole type: UU Detail 4 Shallow SW MH
Cover type: Double 1200 x 675 Clear Opening

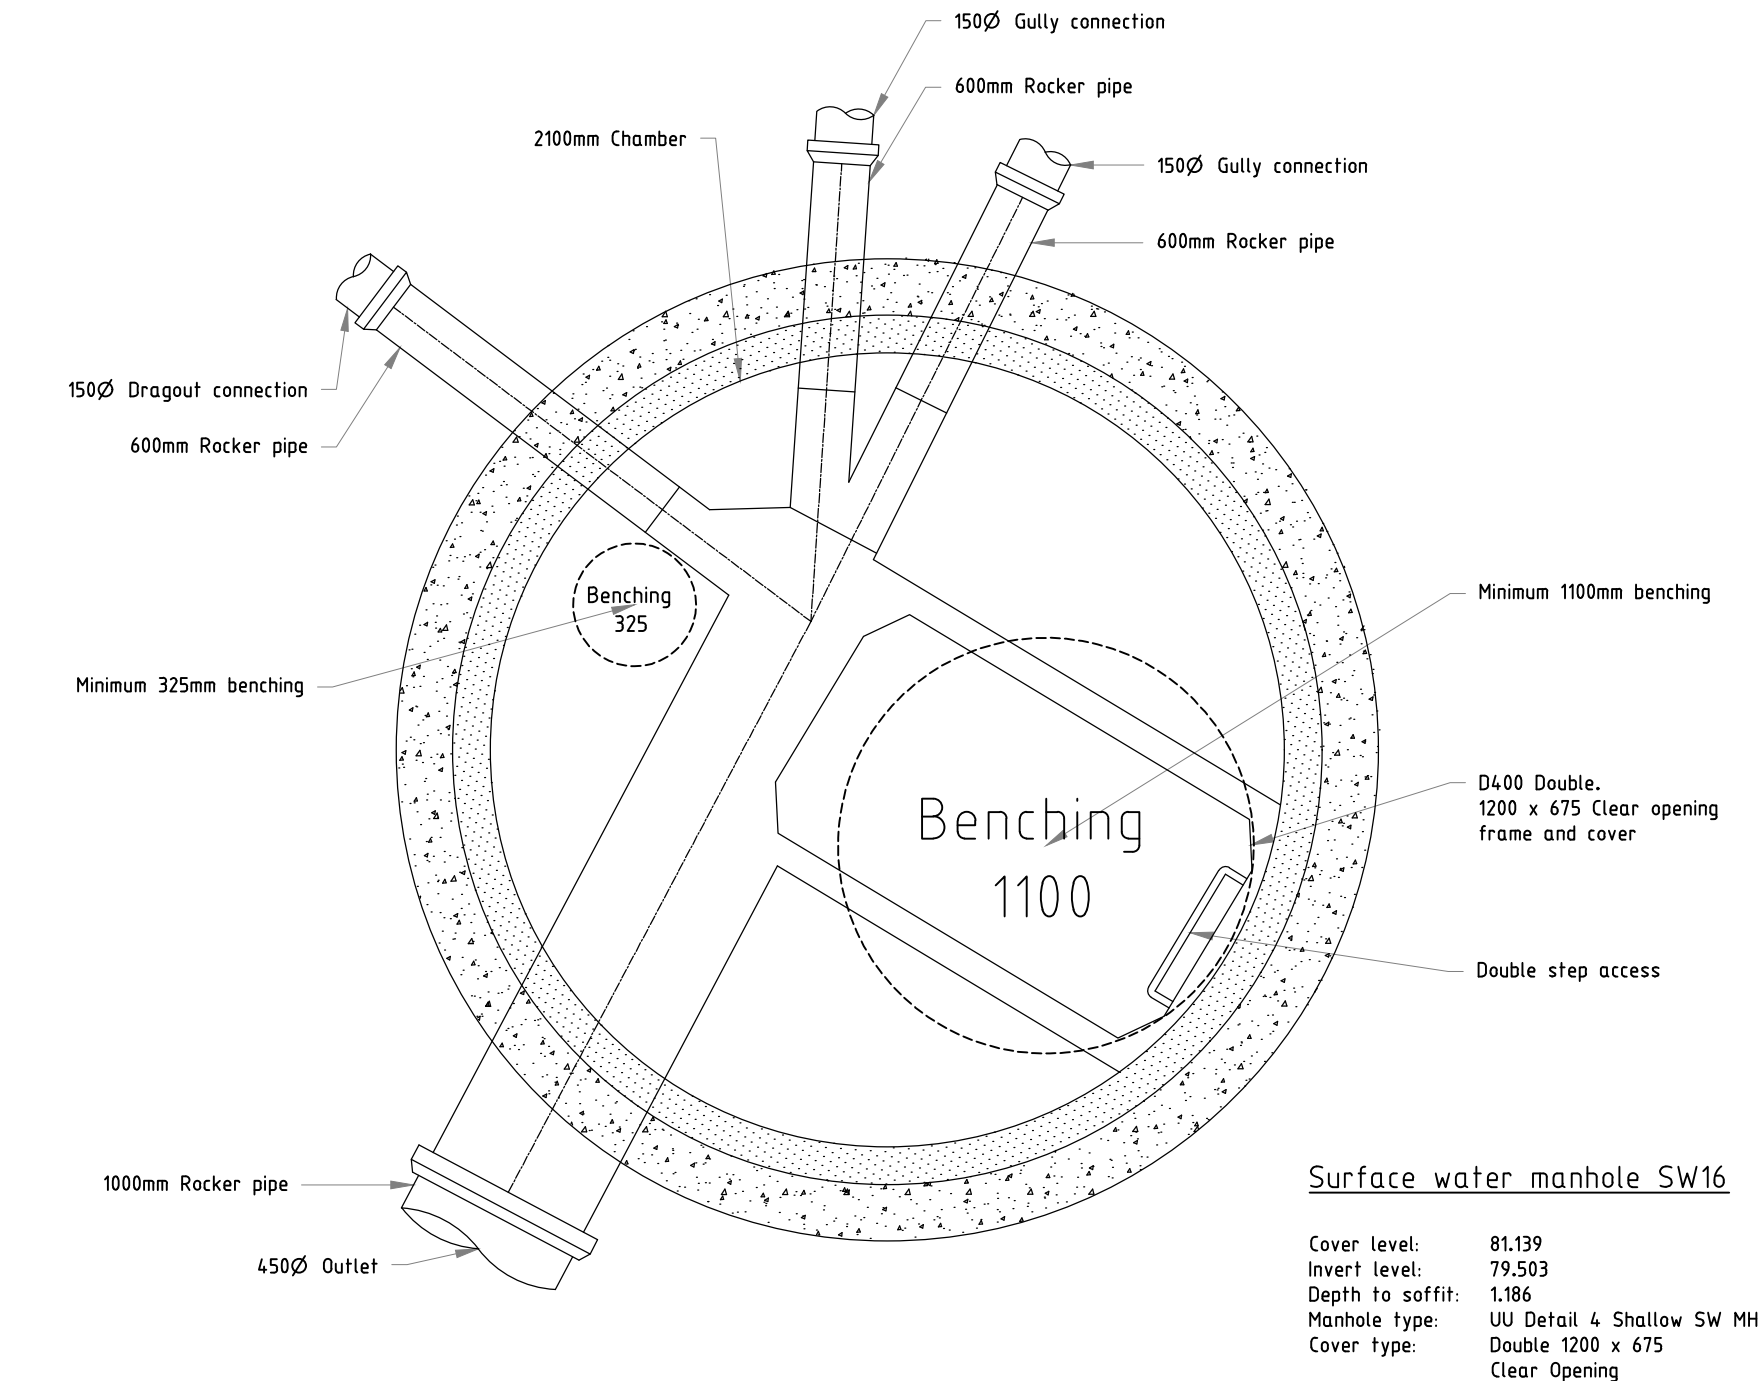

Surface water manhole SW16

Cover level: 81.139
Invert level: 79.503
Depth to soffit: 1.186
Manhole type: UU Detail 4 Shallow SW MH
Cover type: Double 1200 x 675 Clear Opening

PO4 29.10.20	Updated to match drainage layout	J.C	R.A
PO3 17.04.20	PRELIMINARY - Updated to suit S.104 comments	D.A	R.A
PO2 23.03.20	PRELIMINARY - Updated to suit S.104 comments	D.A	R.A
PO1 20.02.20	PRELIMINARY - Issued for information	J.C	M.A
Rev	Date	Description	By

EDGE CONSULTING ENGINEERS www.edgece.com	Manchester . UK 3rd Floor, Cornavon Court, 12 Blackfriars Street, Manchester, M3 9BQ, United Kingdom T: +44 (0) 161 834 1938 E: manchester@edgece.com
--	--

The concepts + information contained in this document are the copyright of EDGE Consulting Engineers.
Use or copying of this document in whole or in part without the written permission of EDGE Consulting Engineers
constitutes an infringement of copyright.
DO NOT SCALE DRAWINGS. IF IN DOUBT, ASK!

Project Name	HAWTHORNE FARM CLITHEROE		
Client	PERSIMMON HOMES		
Designed	Drawn	Checked	Scale @ A1
D.A	D.A	M.A	1:20
Drawing Title	1 TO 20 SURFACE MANHOLE DETAILS SHEET 1		
Project No.	19310		
Drawing No.	19310-EDGE-XX-XX-DR-C-C2111		
Revision	PRELIMINARY NOT FOR CONSTRUCTION		
	P04		