


FOR S10 DETAILS PLEASE REFER TO DRAWING
19310-EDGE-XX-XX-DR-C-C2209_SW HYDROBRAKE
DETAILS

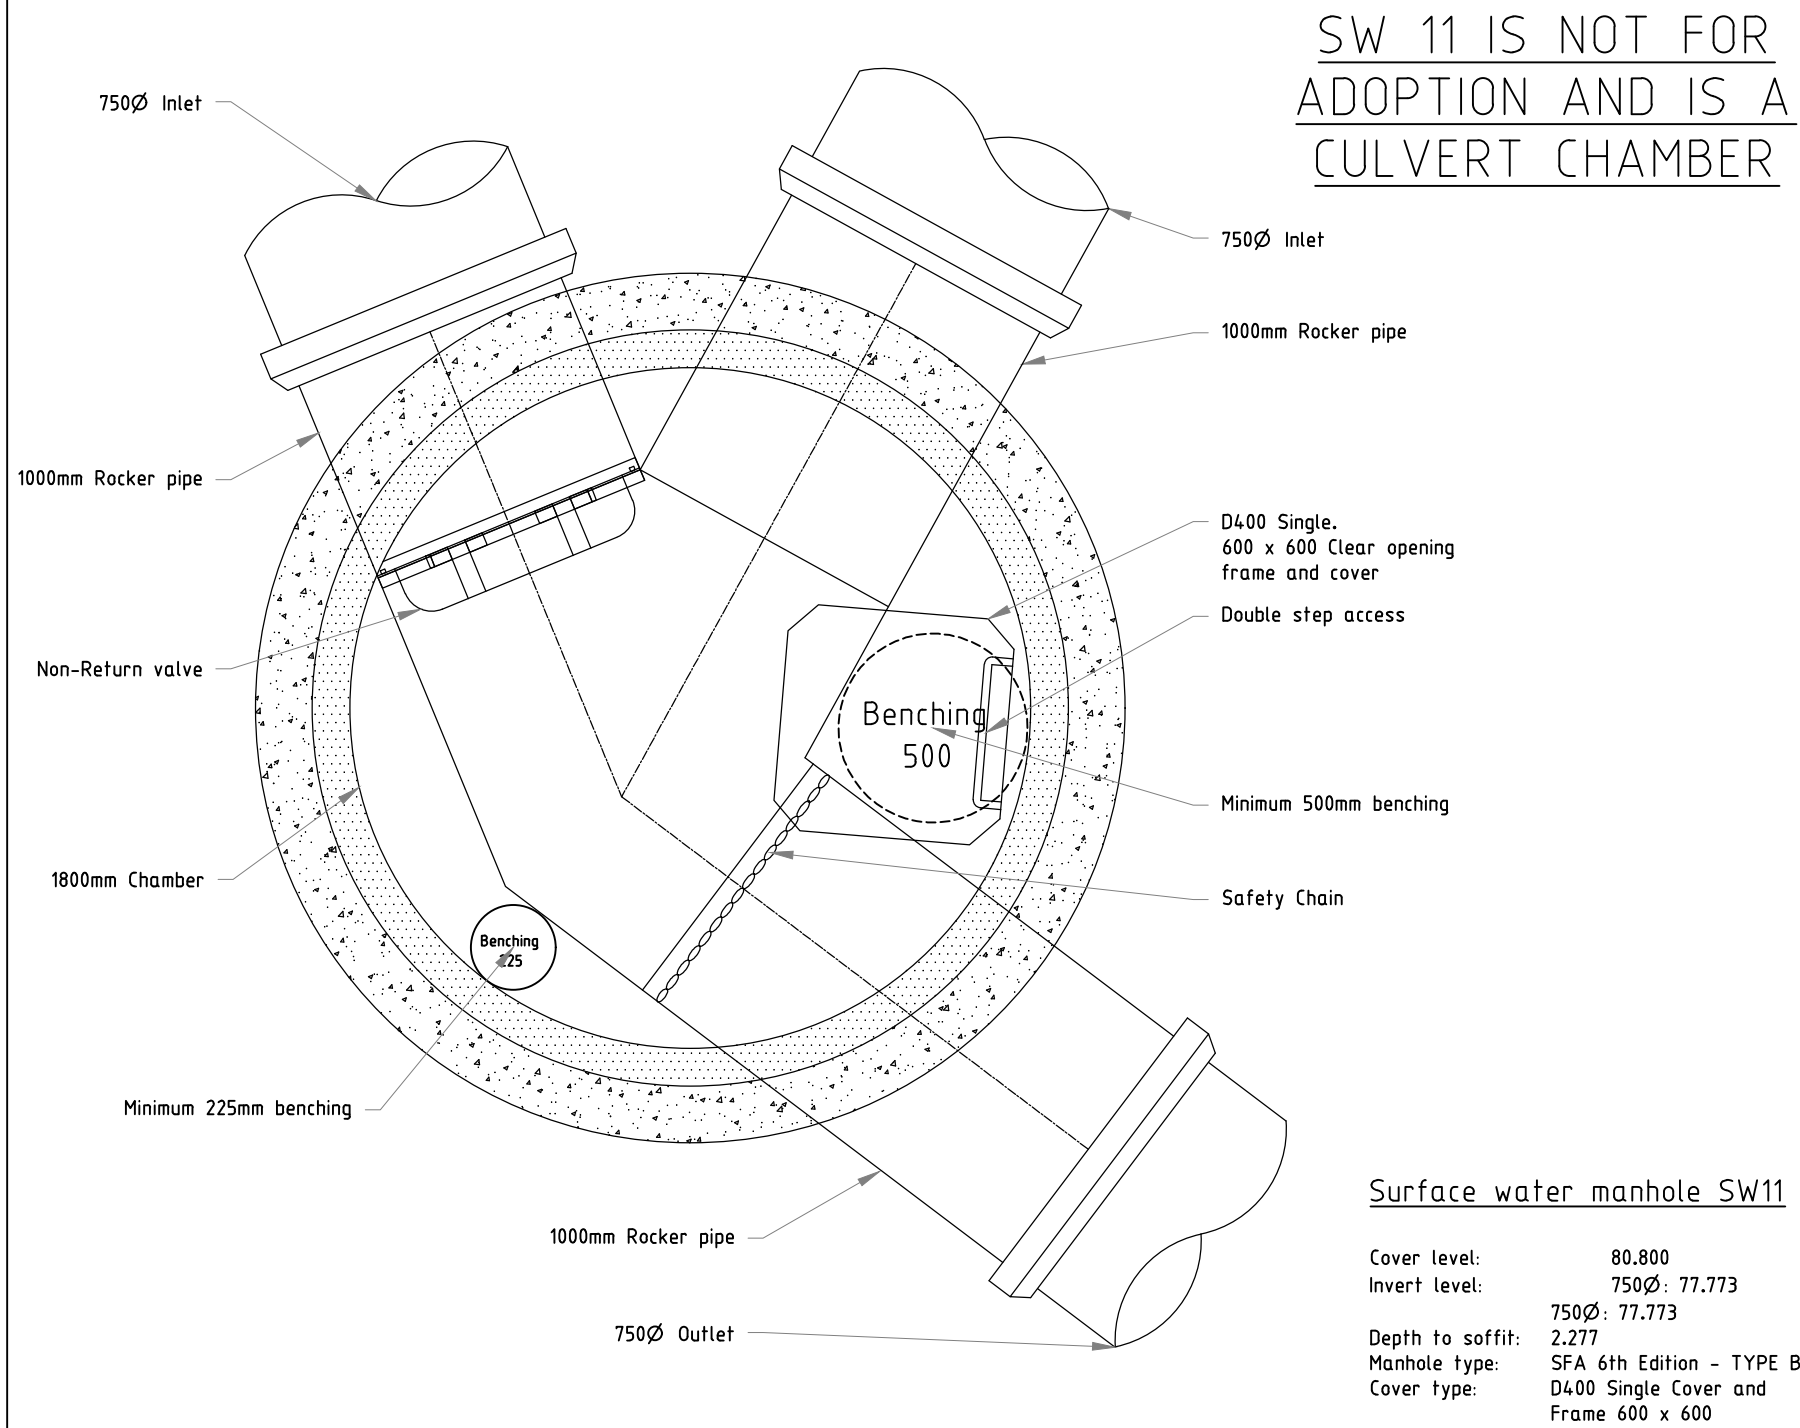

P08	09.12.21	Updated in line with SW14 IL change	H.S	R.A
P07	29.10.20	Updated to match drainage layout	J.C	R.A
P06	17.09.20	PRELIMINARY - Updated to suit S.104 comments	D.A	R.A
P05	30.06.20	PRELIMINARY - Updated to suit S.104 comments	D.A	R.A
P04	17.04.20	PRELIMINARY - Updated to suit S.104 comments	D.A	R.A
P03	23.03.20	PRELIMINARY - Updated to suit S.104 comments	D.A	R.A
P02	20.02.20	PRELIMINARY - Updated S10 note	J.C	R.A
P01	24.01.20	PRELIMINARY - Issued for information	D.A	R.A
Rev	Date	Description	By	Chk



Manchester . UK
3rd Floor, Cornavan Court,
12 Blackfriars Street,
Manchester, M3 5BQ,
United Kingdom

T: +44 (0) 161 834 1938
E: manchester@edgece.com

The concepts + information contained in this document are the copyright of EDGE Consulting Engineers.
Use or copying of this document in whole or in part without the written permission of EDGE Consulting Engineers
constitutes an infringement of copyright.
DO NOT SCALE DRAWINGS. IF IN DOUBT, ASK!

Project Name
**HAWTHORNE FARM
CLITHEROE**

Client
PERSIMMON HOMES

Designed	Drawn	Checked	Scale @/ A1
D.A	D.A	M.A	1:20

Drawing Title
**1 TO 20
SURFACE MANHOLE DETAILS
SHEET 2**

Project No.
19310

**PRELIMINARY
NOT FOR CONSTRUCTION**

Drawing No.
19310-EDGE-XX-XX-DR-C-C2112

Revision
P08

FILE NAME

PLOT DATE

0 mm 10 20 30 40 50