
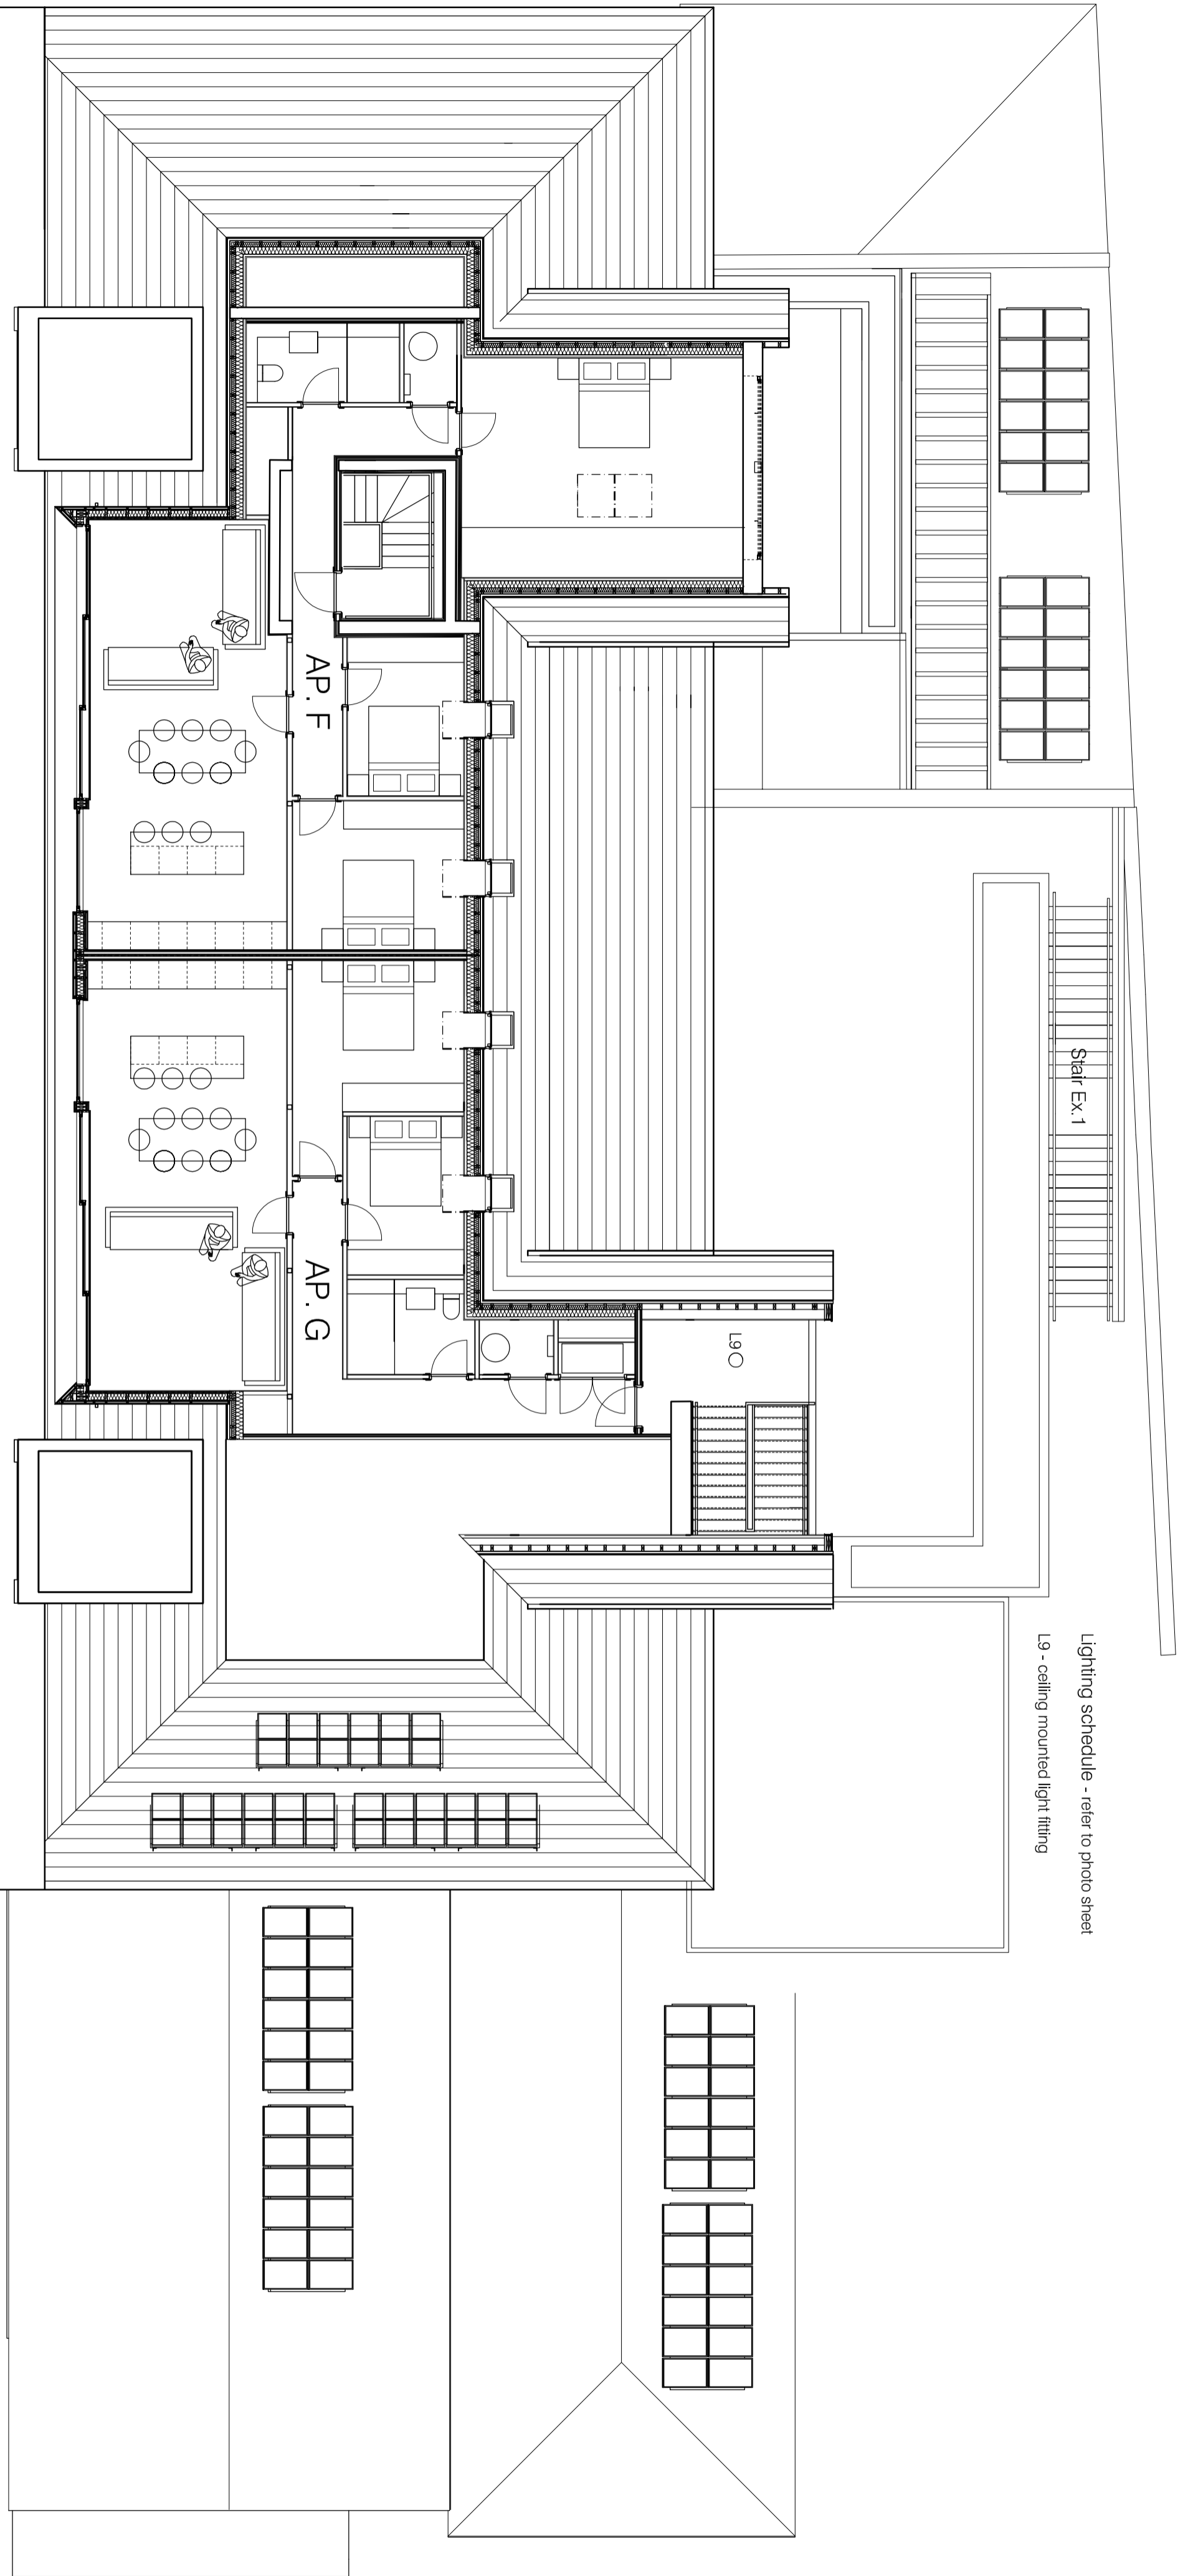


Do not scale. Contractors must check all dimensions on site before preparing production drawings or commencing any work. This drawing and its design is the copyright of LMC Architecture Limited and may not be reproduced in any form whatsoever without their prior express written consent.

Revision	Date	Revision note	Drawn by	Purpose of issue
AB	09.09.24	First Issue	LM	Information

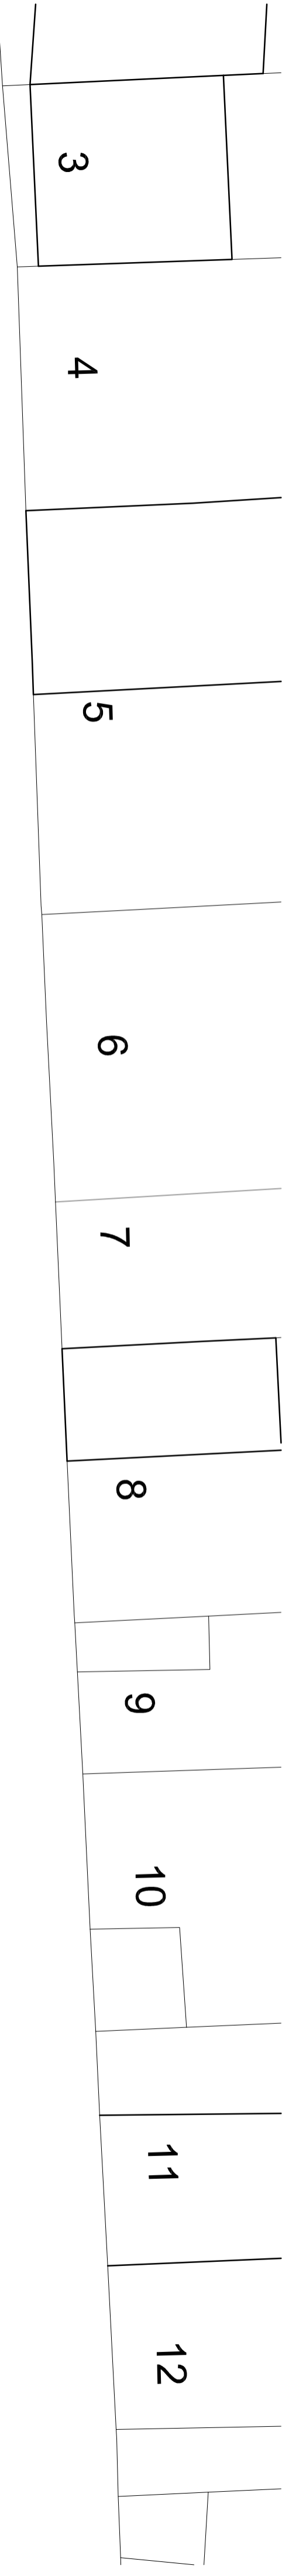

<p>Project Proposed apartments above 1 George Street Whalley</p> <p>Client Roman Corporation</p>	<p>Drawing title Lighting layout – third floor plan</p> <p>Drawing number 2232–803</p>	<p>Scale 1:100 @ A2</p> <p>Date 09.01.25</p>	<p><b>LMC Architecture Limited</b> Architectural design services</p> <p>4 Dove Dale Drive, Ightenhill, Burnley, Lancashire, BB12 8XD Web: www.lmcarchitecture.co.uk</p>	
--	--	--	---	--