
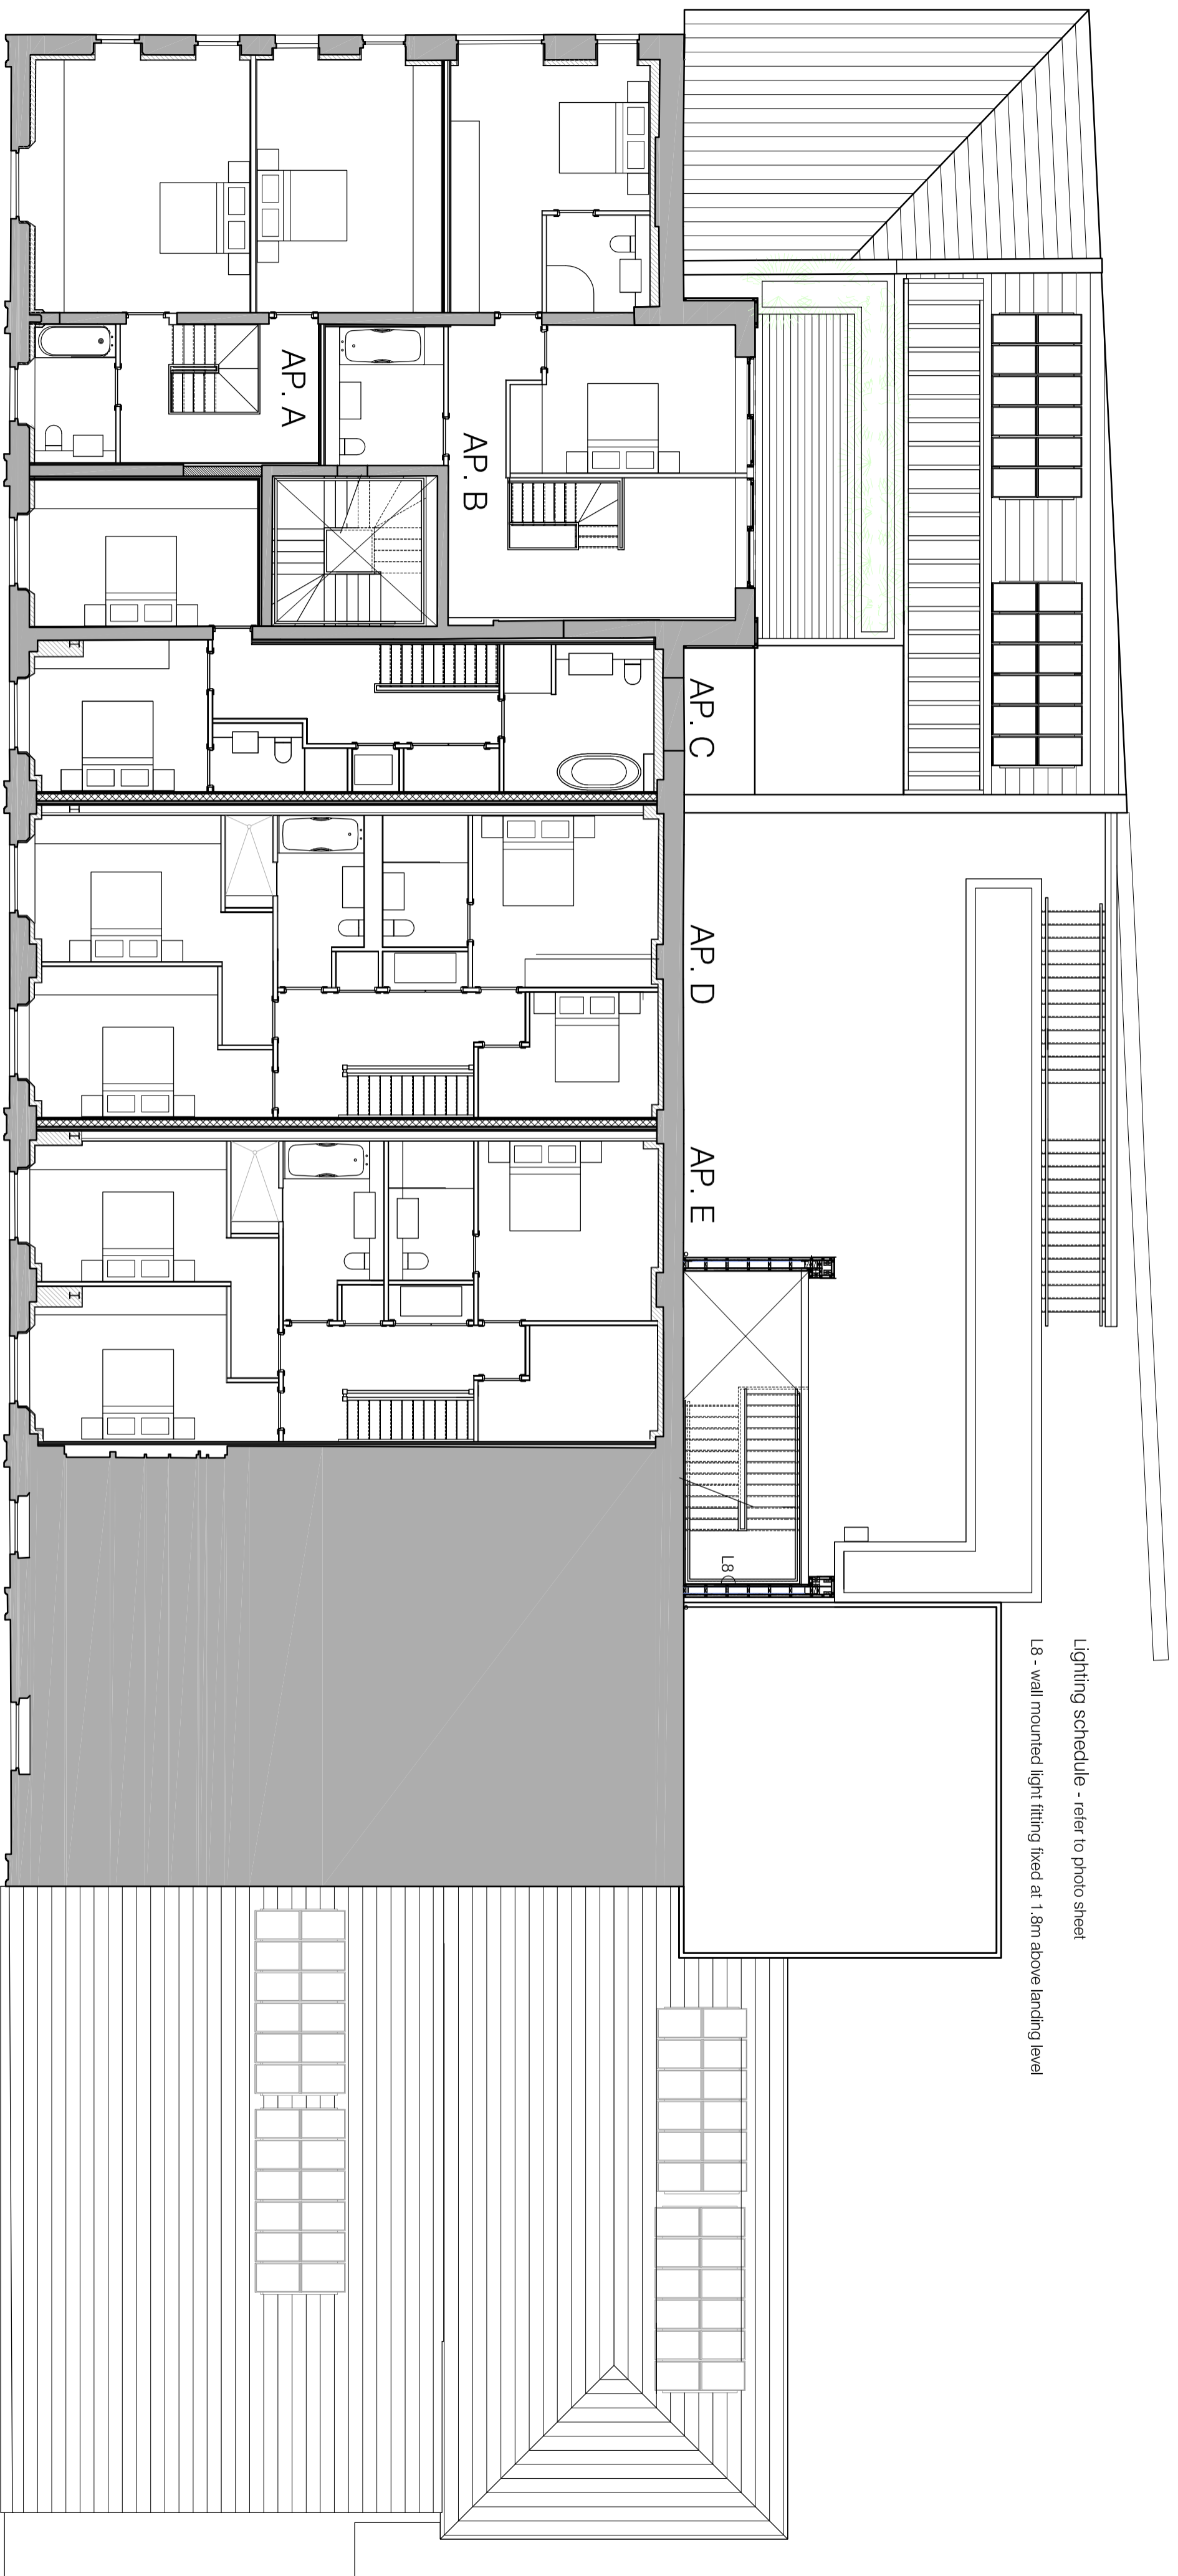


Do not scale. Contractors must check all dimensions on site before preparing production drawings or commencing any work. This drawing and its design is the copyright of LMC Architecture Limited and may not be reproduced in any form whatsoever without their prior express written consent.

Revision	Date	Revision note	Drawn by	Purpose of issue
-	09.01.25	First Issue	LM	Information

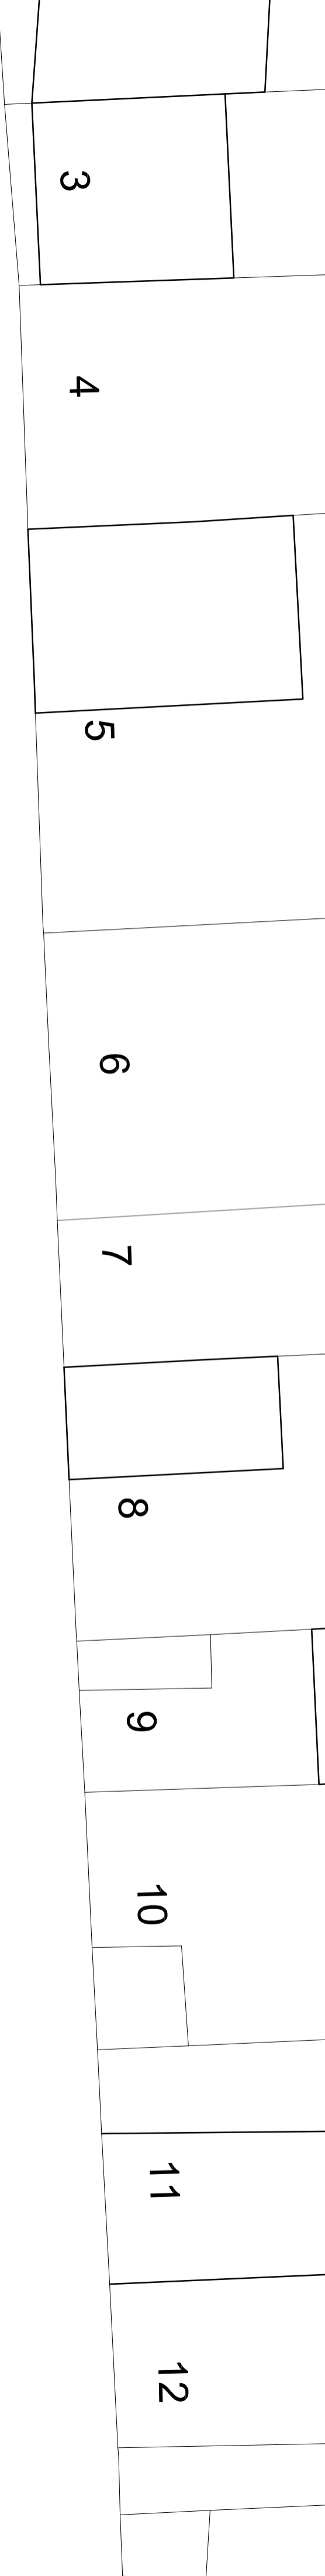

Lighting schedule - refer to photo sheet  
 L8 - wall mounted light fitting fixed at 1.8m above landing level

Project Proposed apartments above 1 George Street Whalley Client Roman Corporation	Drawing title Lighting layout - second floor plan	Scale 1:100 @ A2	LMC Architecture Limited Architectural design services 4 Dove Dale Drive, Ightenhill, Burnley, Lancashire, BB12 8XD Web: www.lmcarchitecture.co.uk	
Drawing number 2232-802	Date 09.01.25	LMC Architecture Limited Architectural design services 4 Dove Dale Drive, Ightenhill, Burnley, Lancashire, BB12 8XD Web: www.lmcarchitecture.co.uk		