
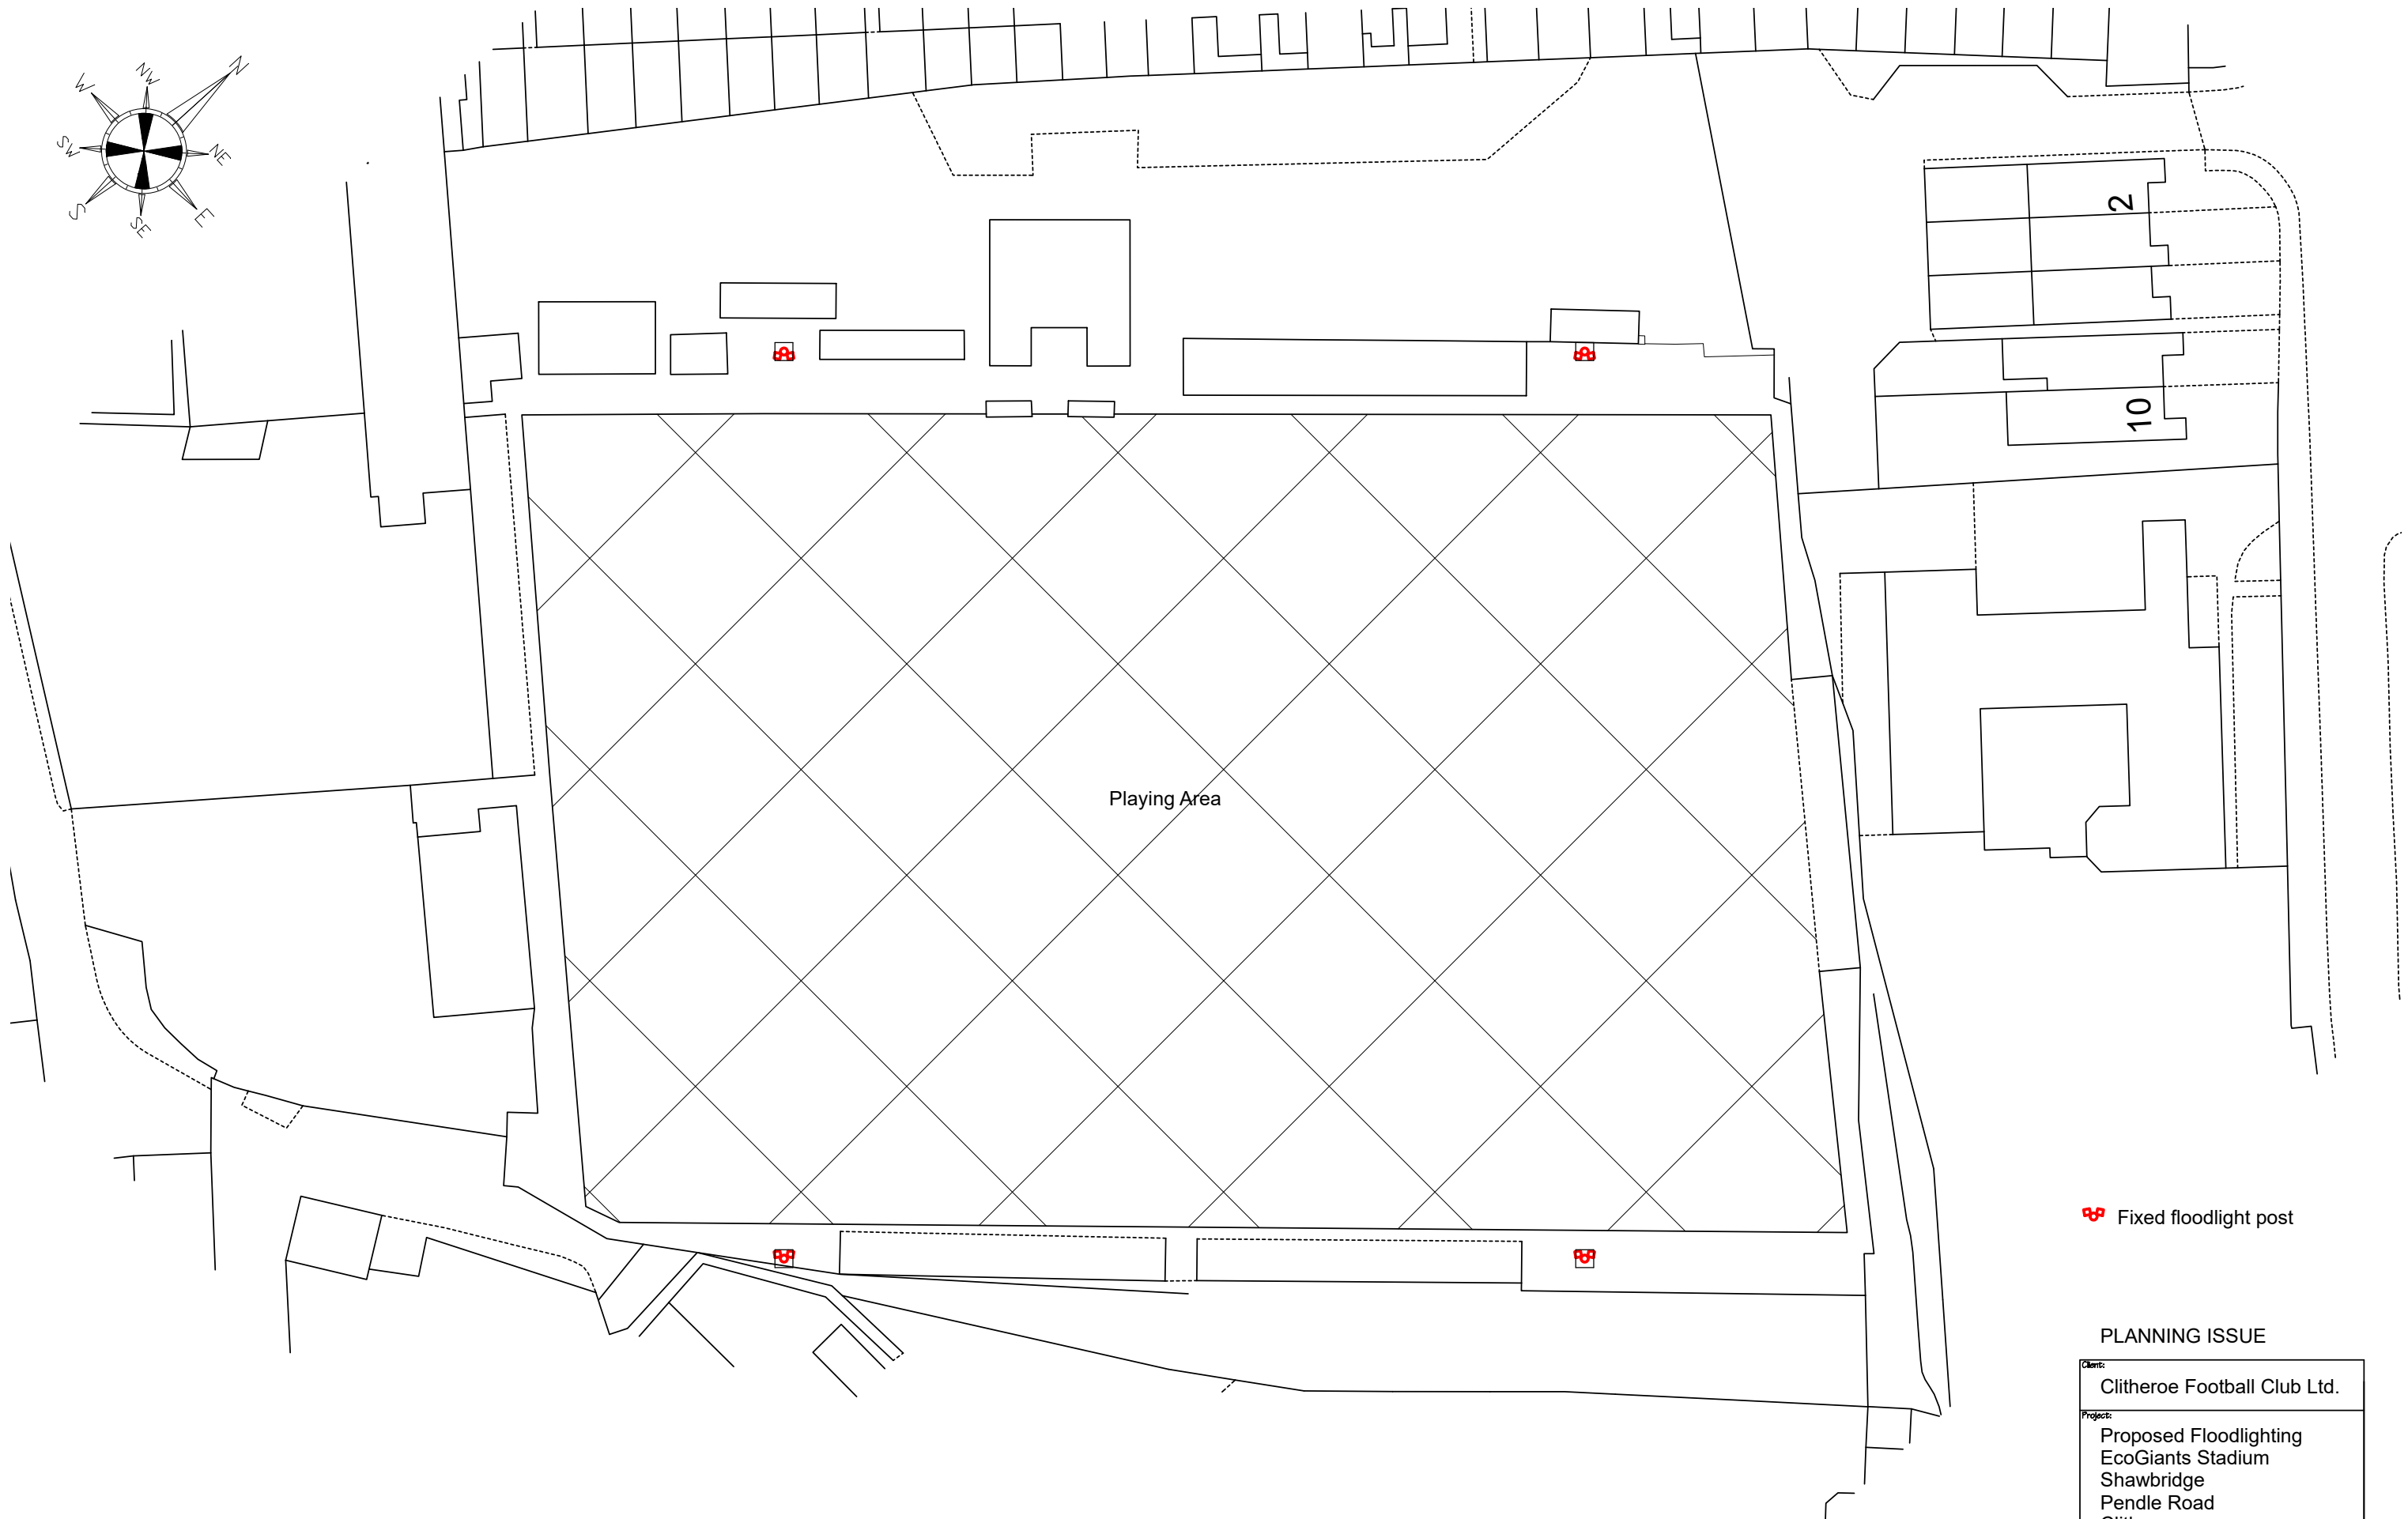


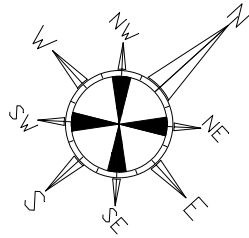

 Fixed floodlight post

PLANNING ISSUE

Client: Clitheroe Football Club Ltd.		
Project: Proposed Floodlighting EcoGiants Stadium Shawbridge Pendle Road Clitheroe		
Dwg title: Proposed Site Plan		
Scale @ A3: 1:500	Date: 09.02.25	Drawn by: PD
Drawing no. 1716 - 03	Rev. A	

PD Construction Consultants
7 Beech Street, Clitheroe, Lancs
BB7 2LL
tel: 07976 771297
email: pdcc@hotmail.co.uk

