


Manhole No.	Ex MH/S1	
Coordinates	373200.645E 441720.152N	
Cover Level	62.583	
Inverts	1	60.921
	2	60.873
Pipe Diameters	1	300
	2	Ex 600
Manhole Size	1800	
Cover	Class D400 150mm depth BS EN 124	
MH Type	Shallow MH	
MH Depth	1.710	
MH Depth C.L. / Soffit of Outlet Pipe	1.110	
<u>NOTES</u>		

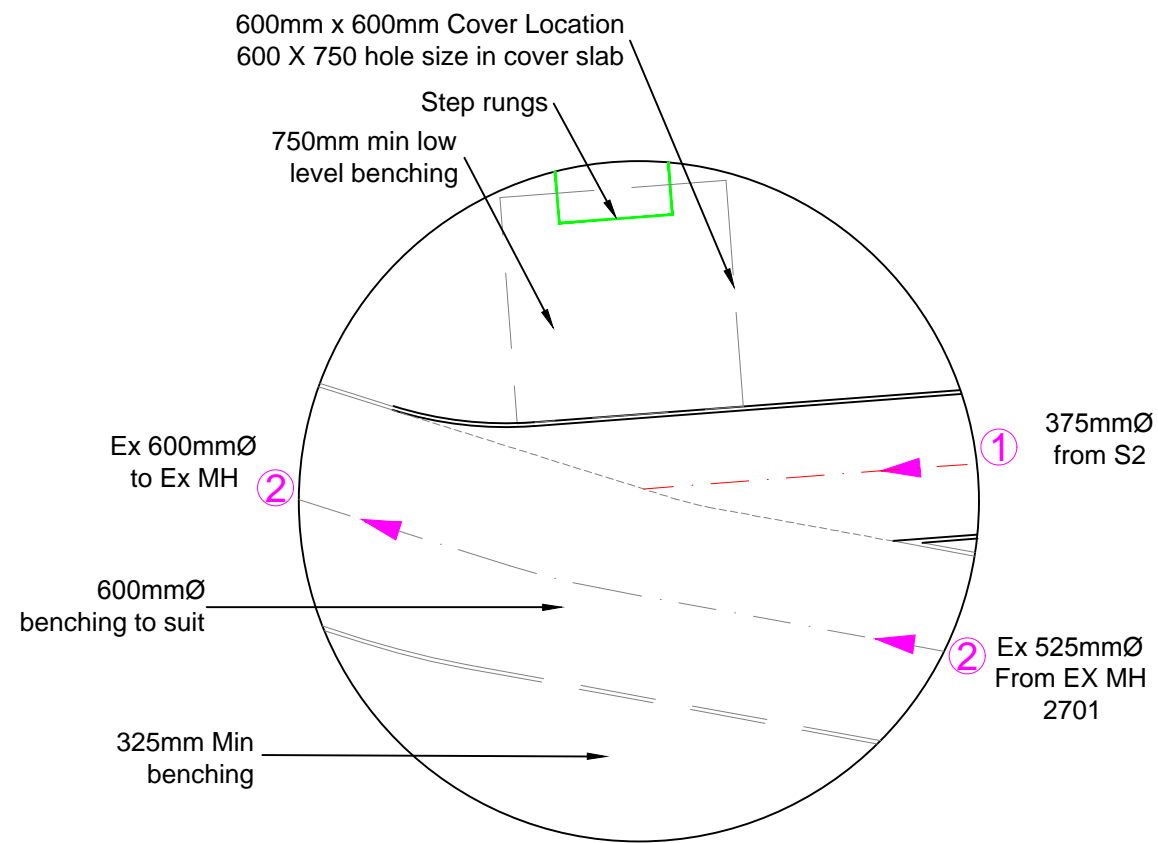

Rev	Date	Initials	Details
A	19.02.19	GM	Drawing updated following new drainage layout
Drawing Revisions			
North Point	Project		Union Street Clitheroe <small>Environmental Consultants</small>
 <small>Quality Ass.</small> UKAS 005 <small>Quality Assurance</small> ISO 9001:2008 SGS Certificate GB02/54539	Client Prospect (GB) Limited <small>Environmental Planners Civil Engineers Landscape Architects Graphic Design</small>		
Original Size	Title Connection to Existing Manhole	Drawn GM	Checked By SRG
A3	Copyright Acknowledgement Ordnance Survey © © Crown Copyright All rights reserved. Licence No. AL100017966	Date March 18	Scale 1:20
Drawing No. 30250/102		Revision A	