


GENERAL NOTES

1. THIS DRAWING IS TO BE READ IN CONJUNCTION WITH ALL RELEVANT SLEATER & WATSON LLP DRAWINGS AND SPECIFICATIONS ALONG WITH ALL ARCHITECTURAL AND MECHANICAL & ELECTRICAL ENGINEERING CONTRACT DOCUMENTS.

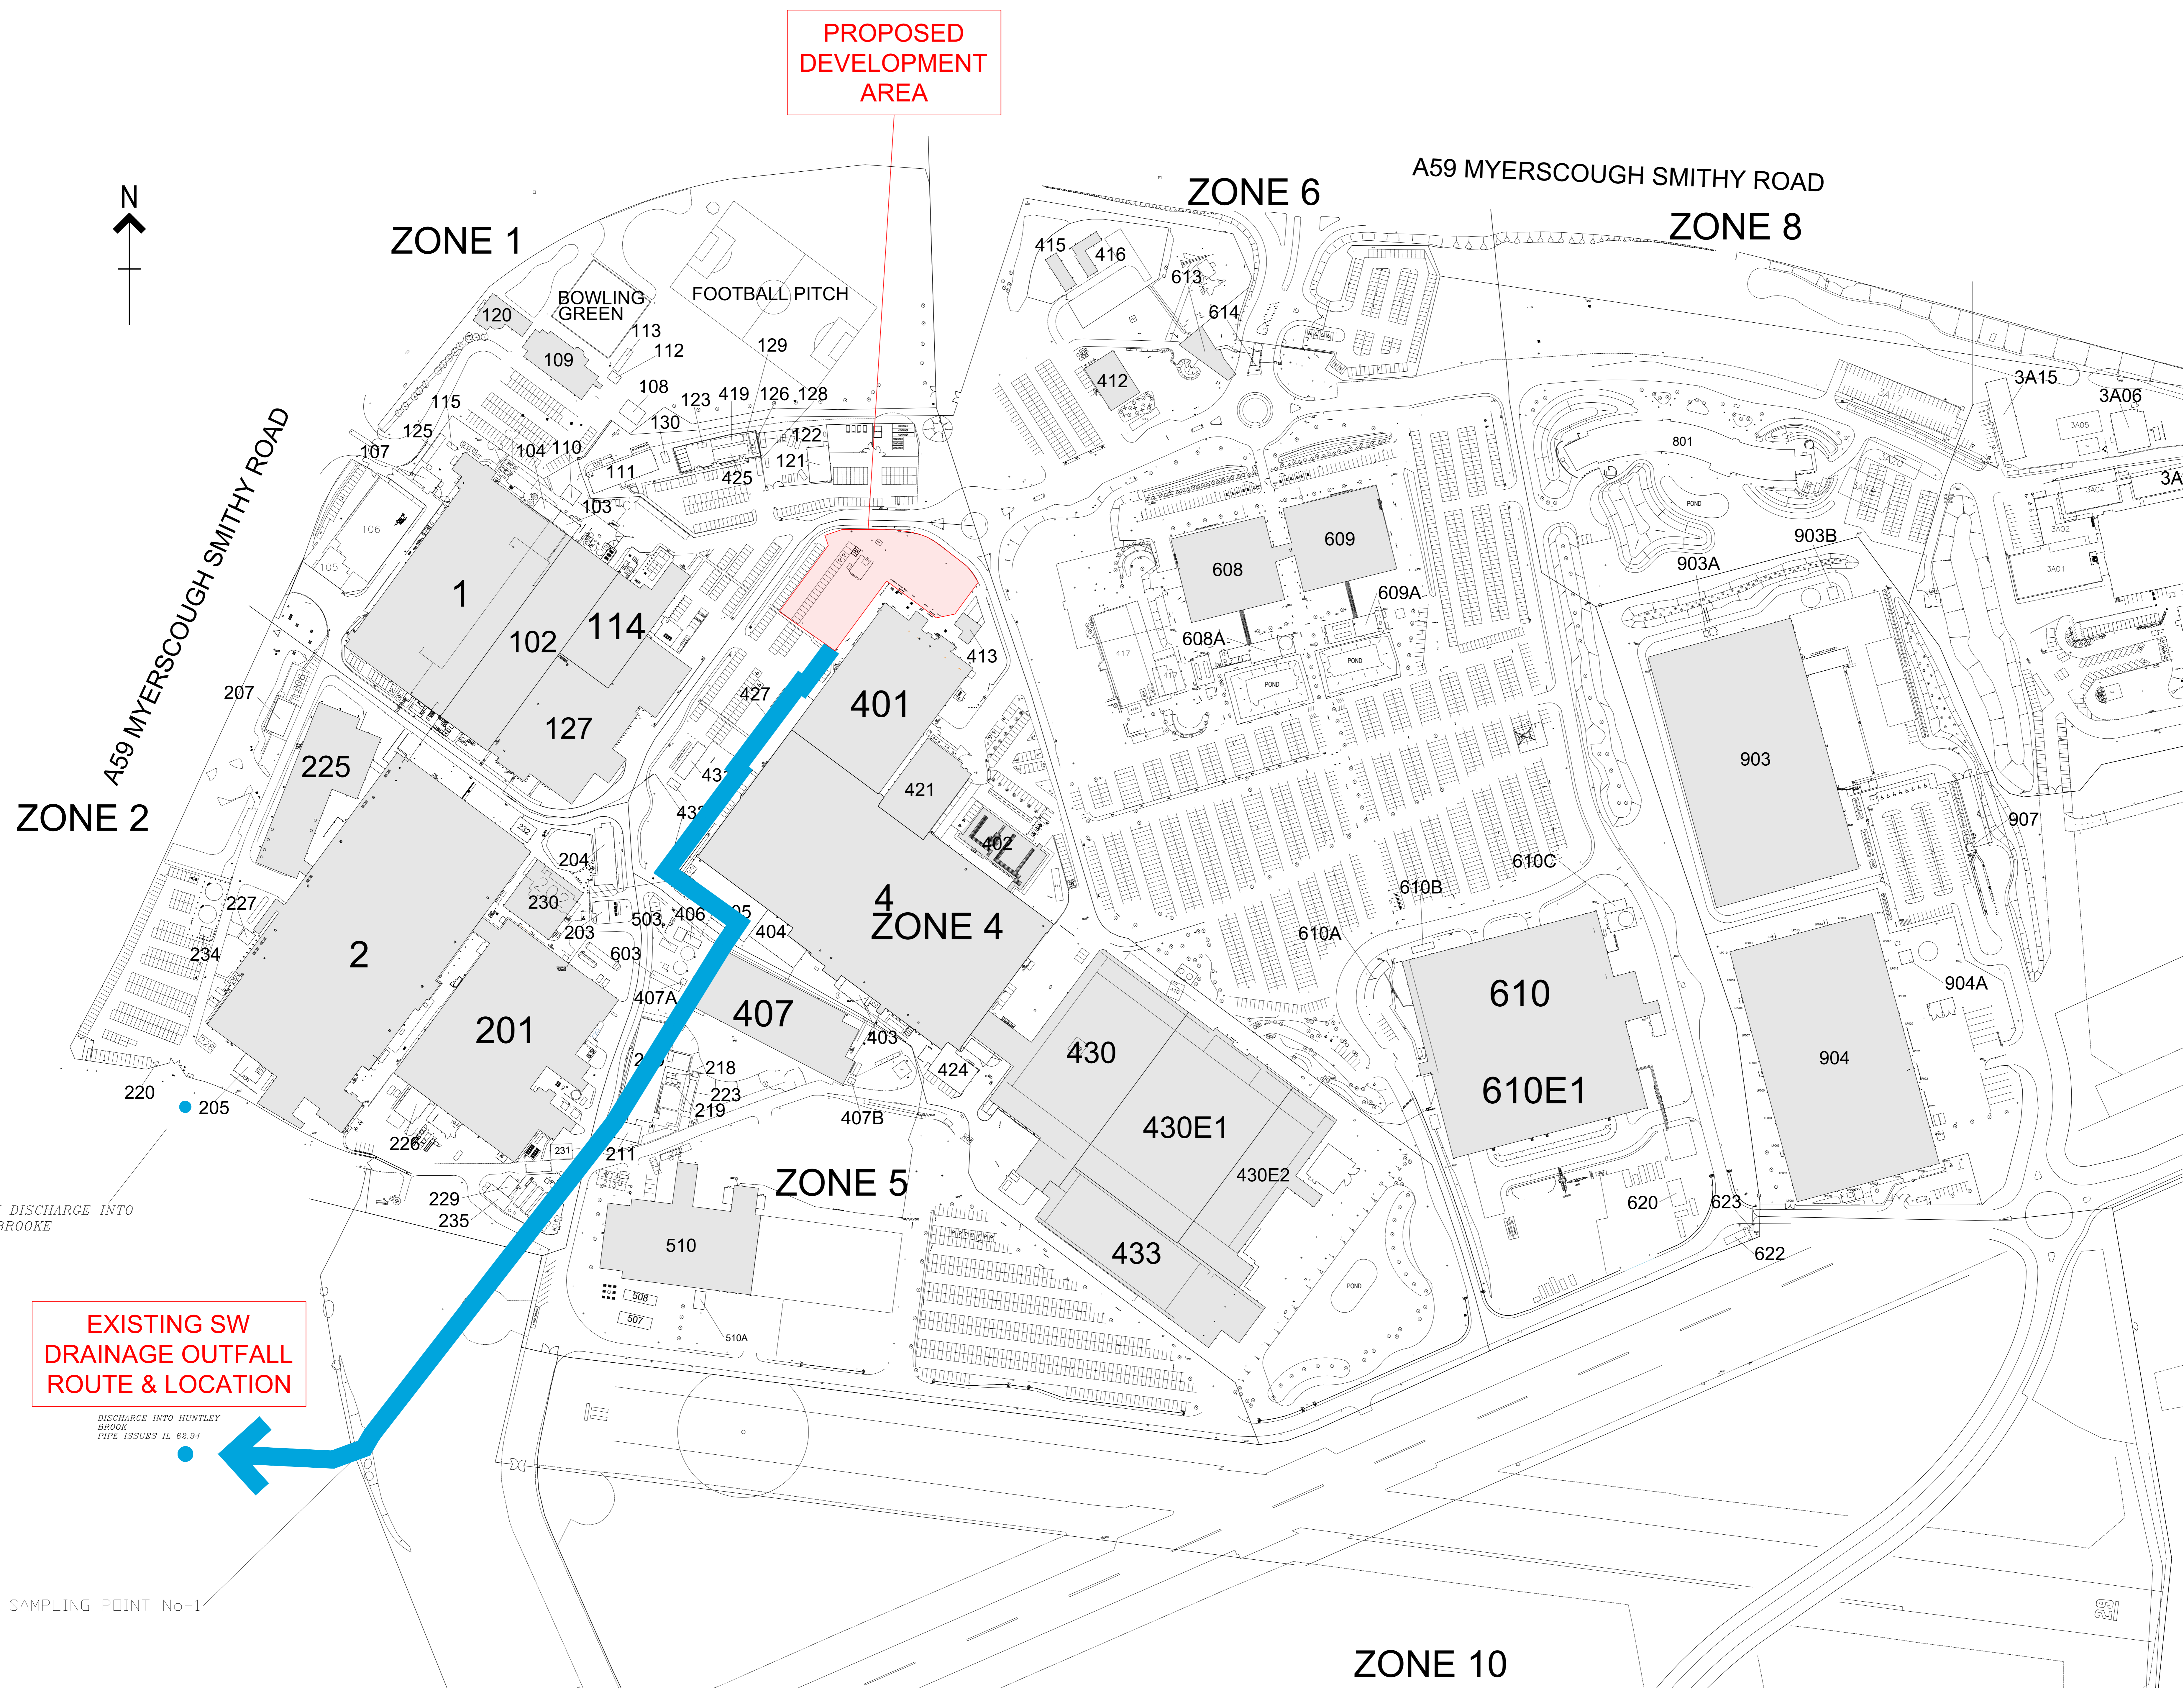

EXISTING SITE PLAN WITH SW DRAINAGE OUTFALL ROUTE & LOCATION

SCALE 1:1250

PROJECT	PRELIMINARY
CLIENT	BAE SYSTEMS
PROJECT	MODULAR BUILDING, (CEB REPLACEMENT), BAE SYSTEMS, SAMLESBURY.
TITLE	EXISTING SITE PLAN WITH SW DRAINAGE OUTFALL ROUTE & LOCATION.
DRAWN	GW
CHECKED	SAW
DATE	FEB. 2025
PROJECT NO.	215/011
SCALE	1:1250
DRG No.	CEB-SAW-XX-XX-52-D-C-5210-S0-P1