


GROUND FLOOR

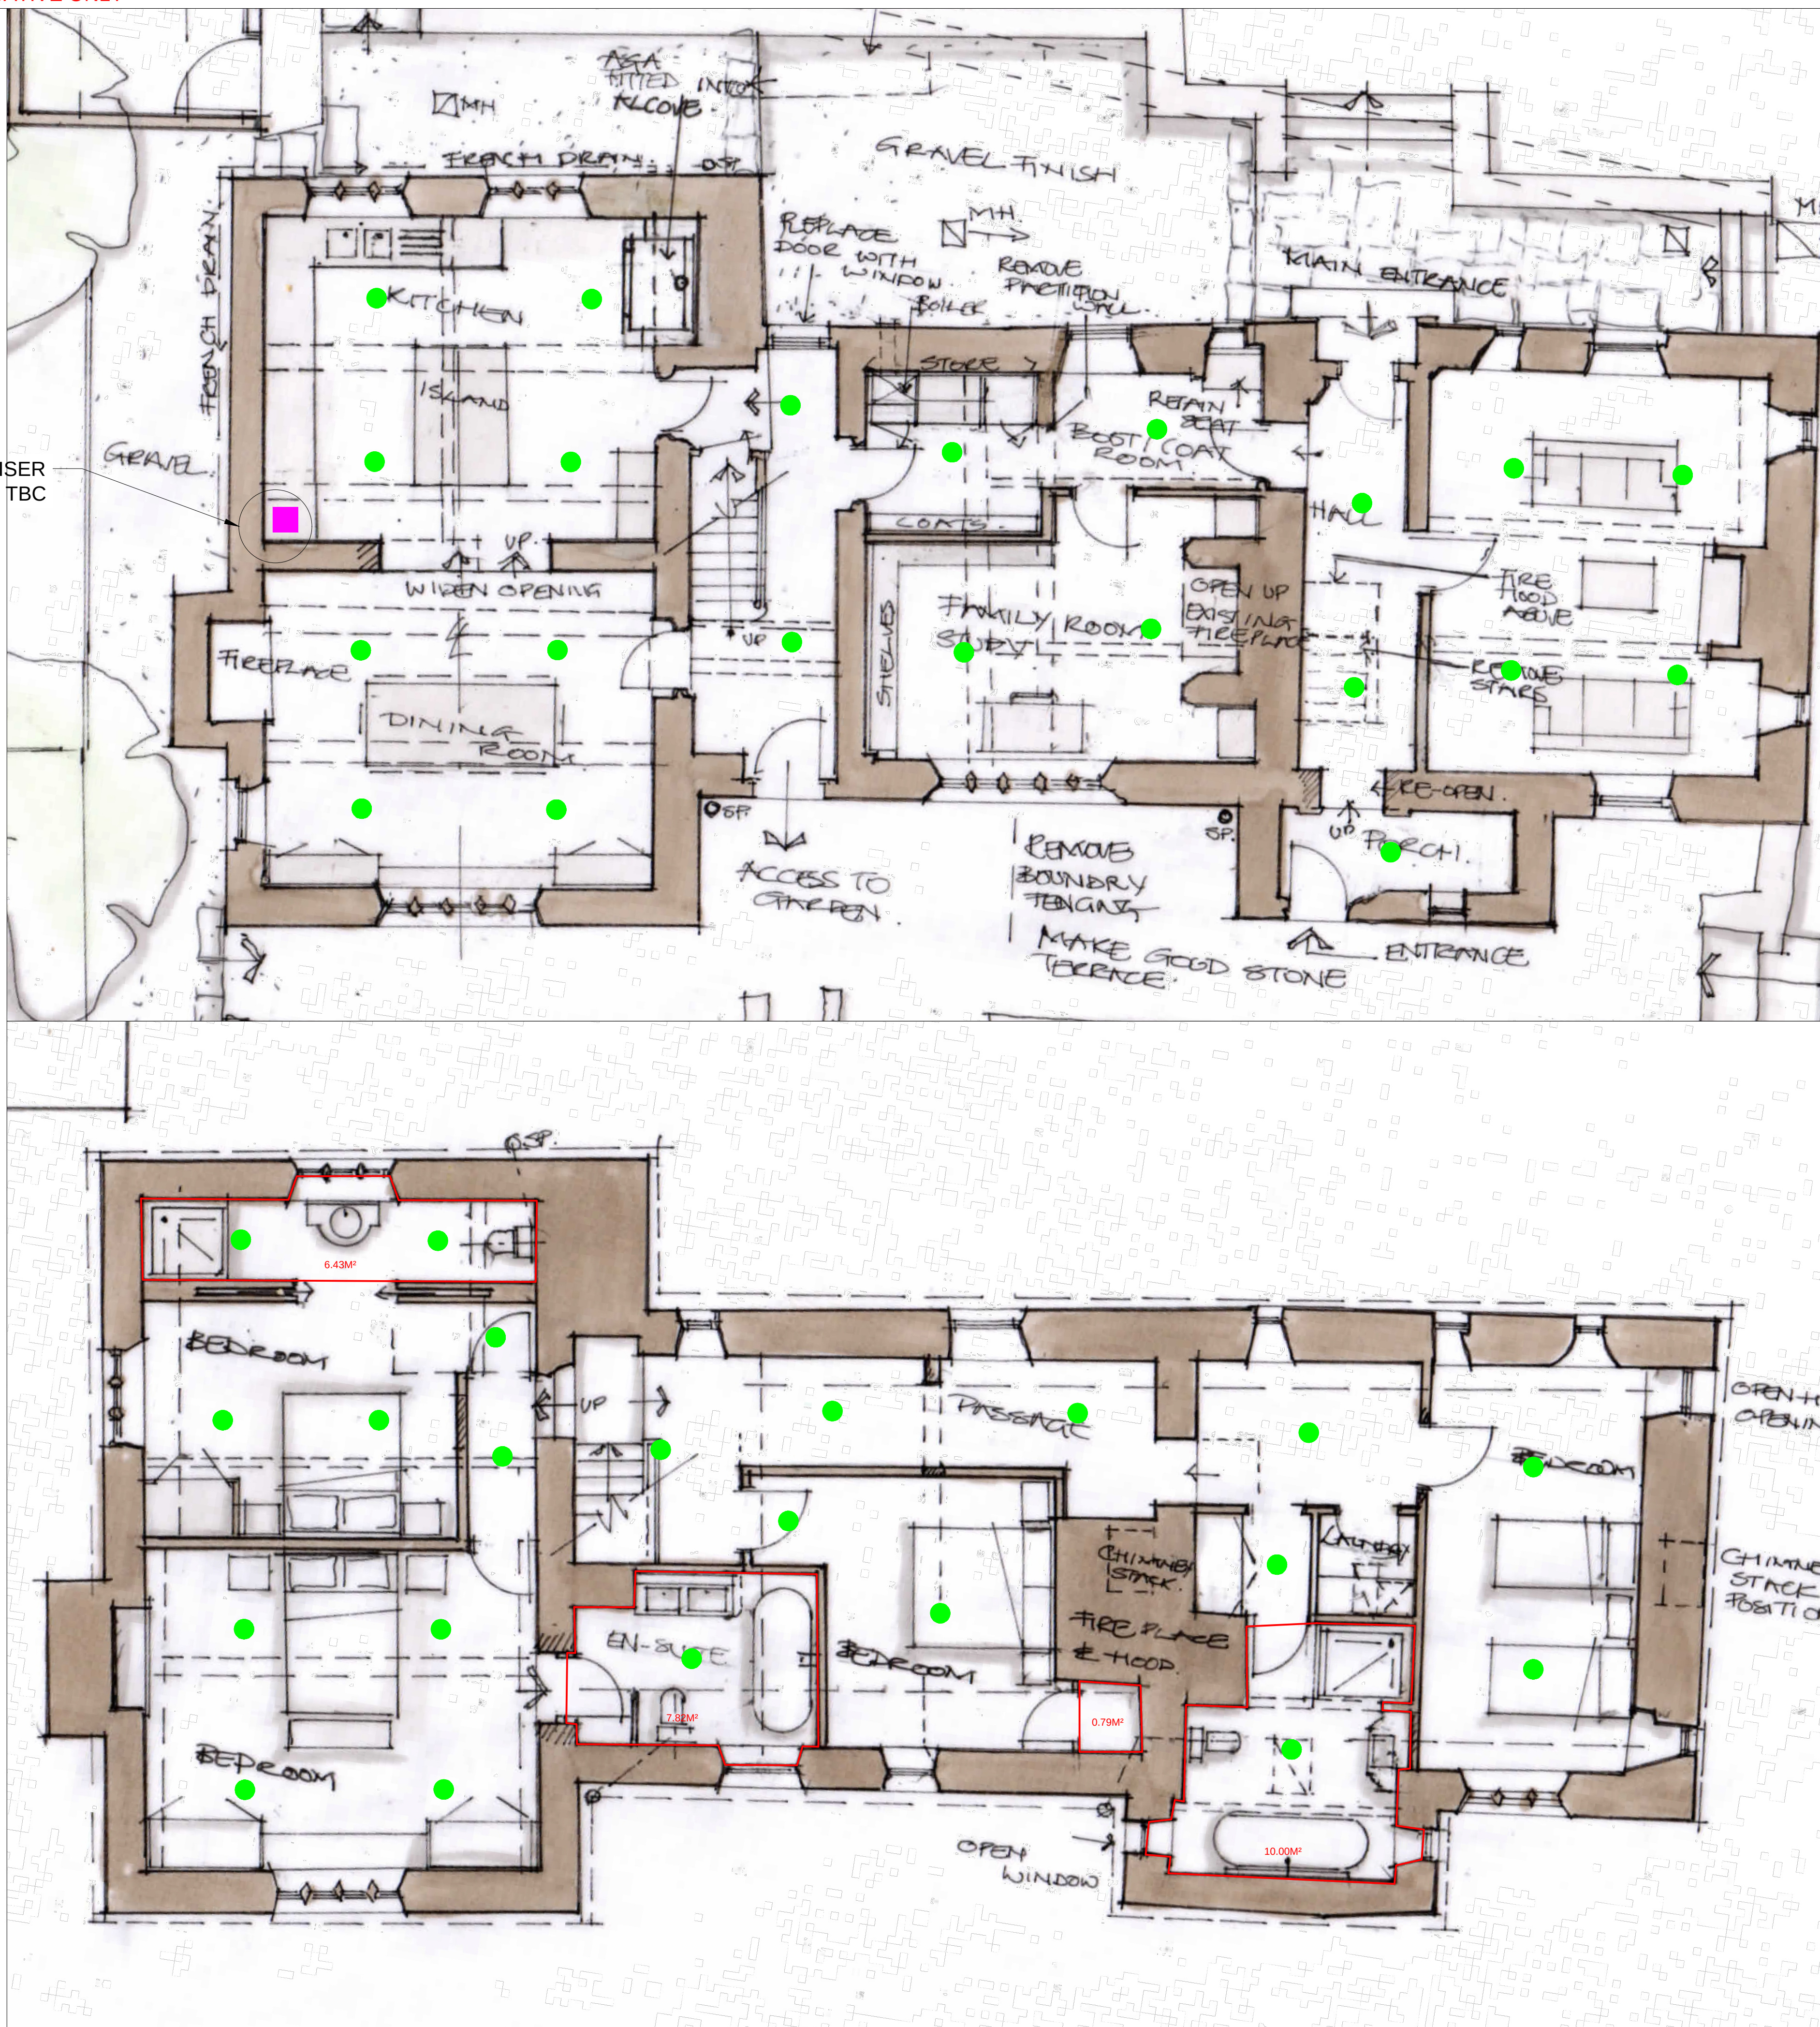

LVL	NOZZLE QTY
1F	21
GF	21
TOTAL	42

The diagram illustrates the RCD fire alarm system components and their connections. A 230V 1.3amp Supply provides fire-rated cable direct from the board non-RCD side to a fire-rated cable. This cable connects to the ICD Pump, which has dimensions of 413mm height and 342mm width. The ICD Pump is connected to a Water supply to property. A Control manifold is connected to the ICD Pump and the system. A Priority demand valve is connected to the system, which then leads to Water to other appliances in the property.

EXTERNAL REFERENCES	TYPE
07 Proposed Ground Floor Plan - 1	FLOORPLANS (PDF)
08 Proposed First Floor Plan - 1	FLOORPLANS (PDF)

REV	DESCRIPTION	DRAWN	DATE	APPROVED
A	QUOTE PROPOSAL LAYOUT	A.J	01/10/25	T.P
B	QUOTE MOVED TO UPTICK	A.J	13/06/25	T.P
C	LATEST FLOOR PLAN INCORPORATED	A.J	03/12/25	T.P

 **THE FIRE SUPPRESSION**
C O M P A N Y

277 BRYN ROAD,
ASHTON-IN-MAKERFIELD,
WIGAN, WN4 8BS

TEL: 01942 364479
info@thefiresuppressioncompany.co.uk
www.thefiresuppressioncompany.co.uk

CLIENT: DANIELLE ARKWRIGHT @ DC ARCHITECTURAL DE...		SITE ADDRESS: COCKSHUTTS FARM HOUSE SIMONSTONE, RIBBLE VALLEY LANCASHIRE, BB7 1PT	
PROJECT: COCKSHUTTS FARM HOUSE, SIMONSTONE		STATUS: PLANNING	
DRAWING TITLE: INDICATIVE MIST SYSTEM LAYOUT (FOR QUOTATION ONLY) ALL AREAS		SCALE: N.T.S. SIZE: A1	
DRAWN: A. JONES	APPROVED: T. PALMER	DRAWING NUMBER: QU-0027	REV: C
DATE: 03/12/25	DATE: 03/12/25		