

this drawing remains the property of fisch design limited and duplication of this drawing in whole or any part is strictly forbidden without prior written permission from fisch design ltd

all structural alterations are to be approved by a structural engineer


do not scale from this drawing, all dimensions to be checked on site



EXISTING REAR ELEVATION SCALE 1:50 @A1



PROPOSED REAR ELEVATION SCALE 1:50 @A1

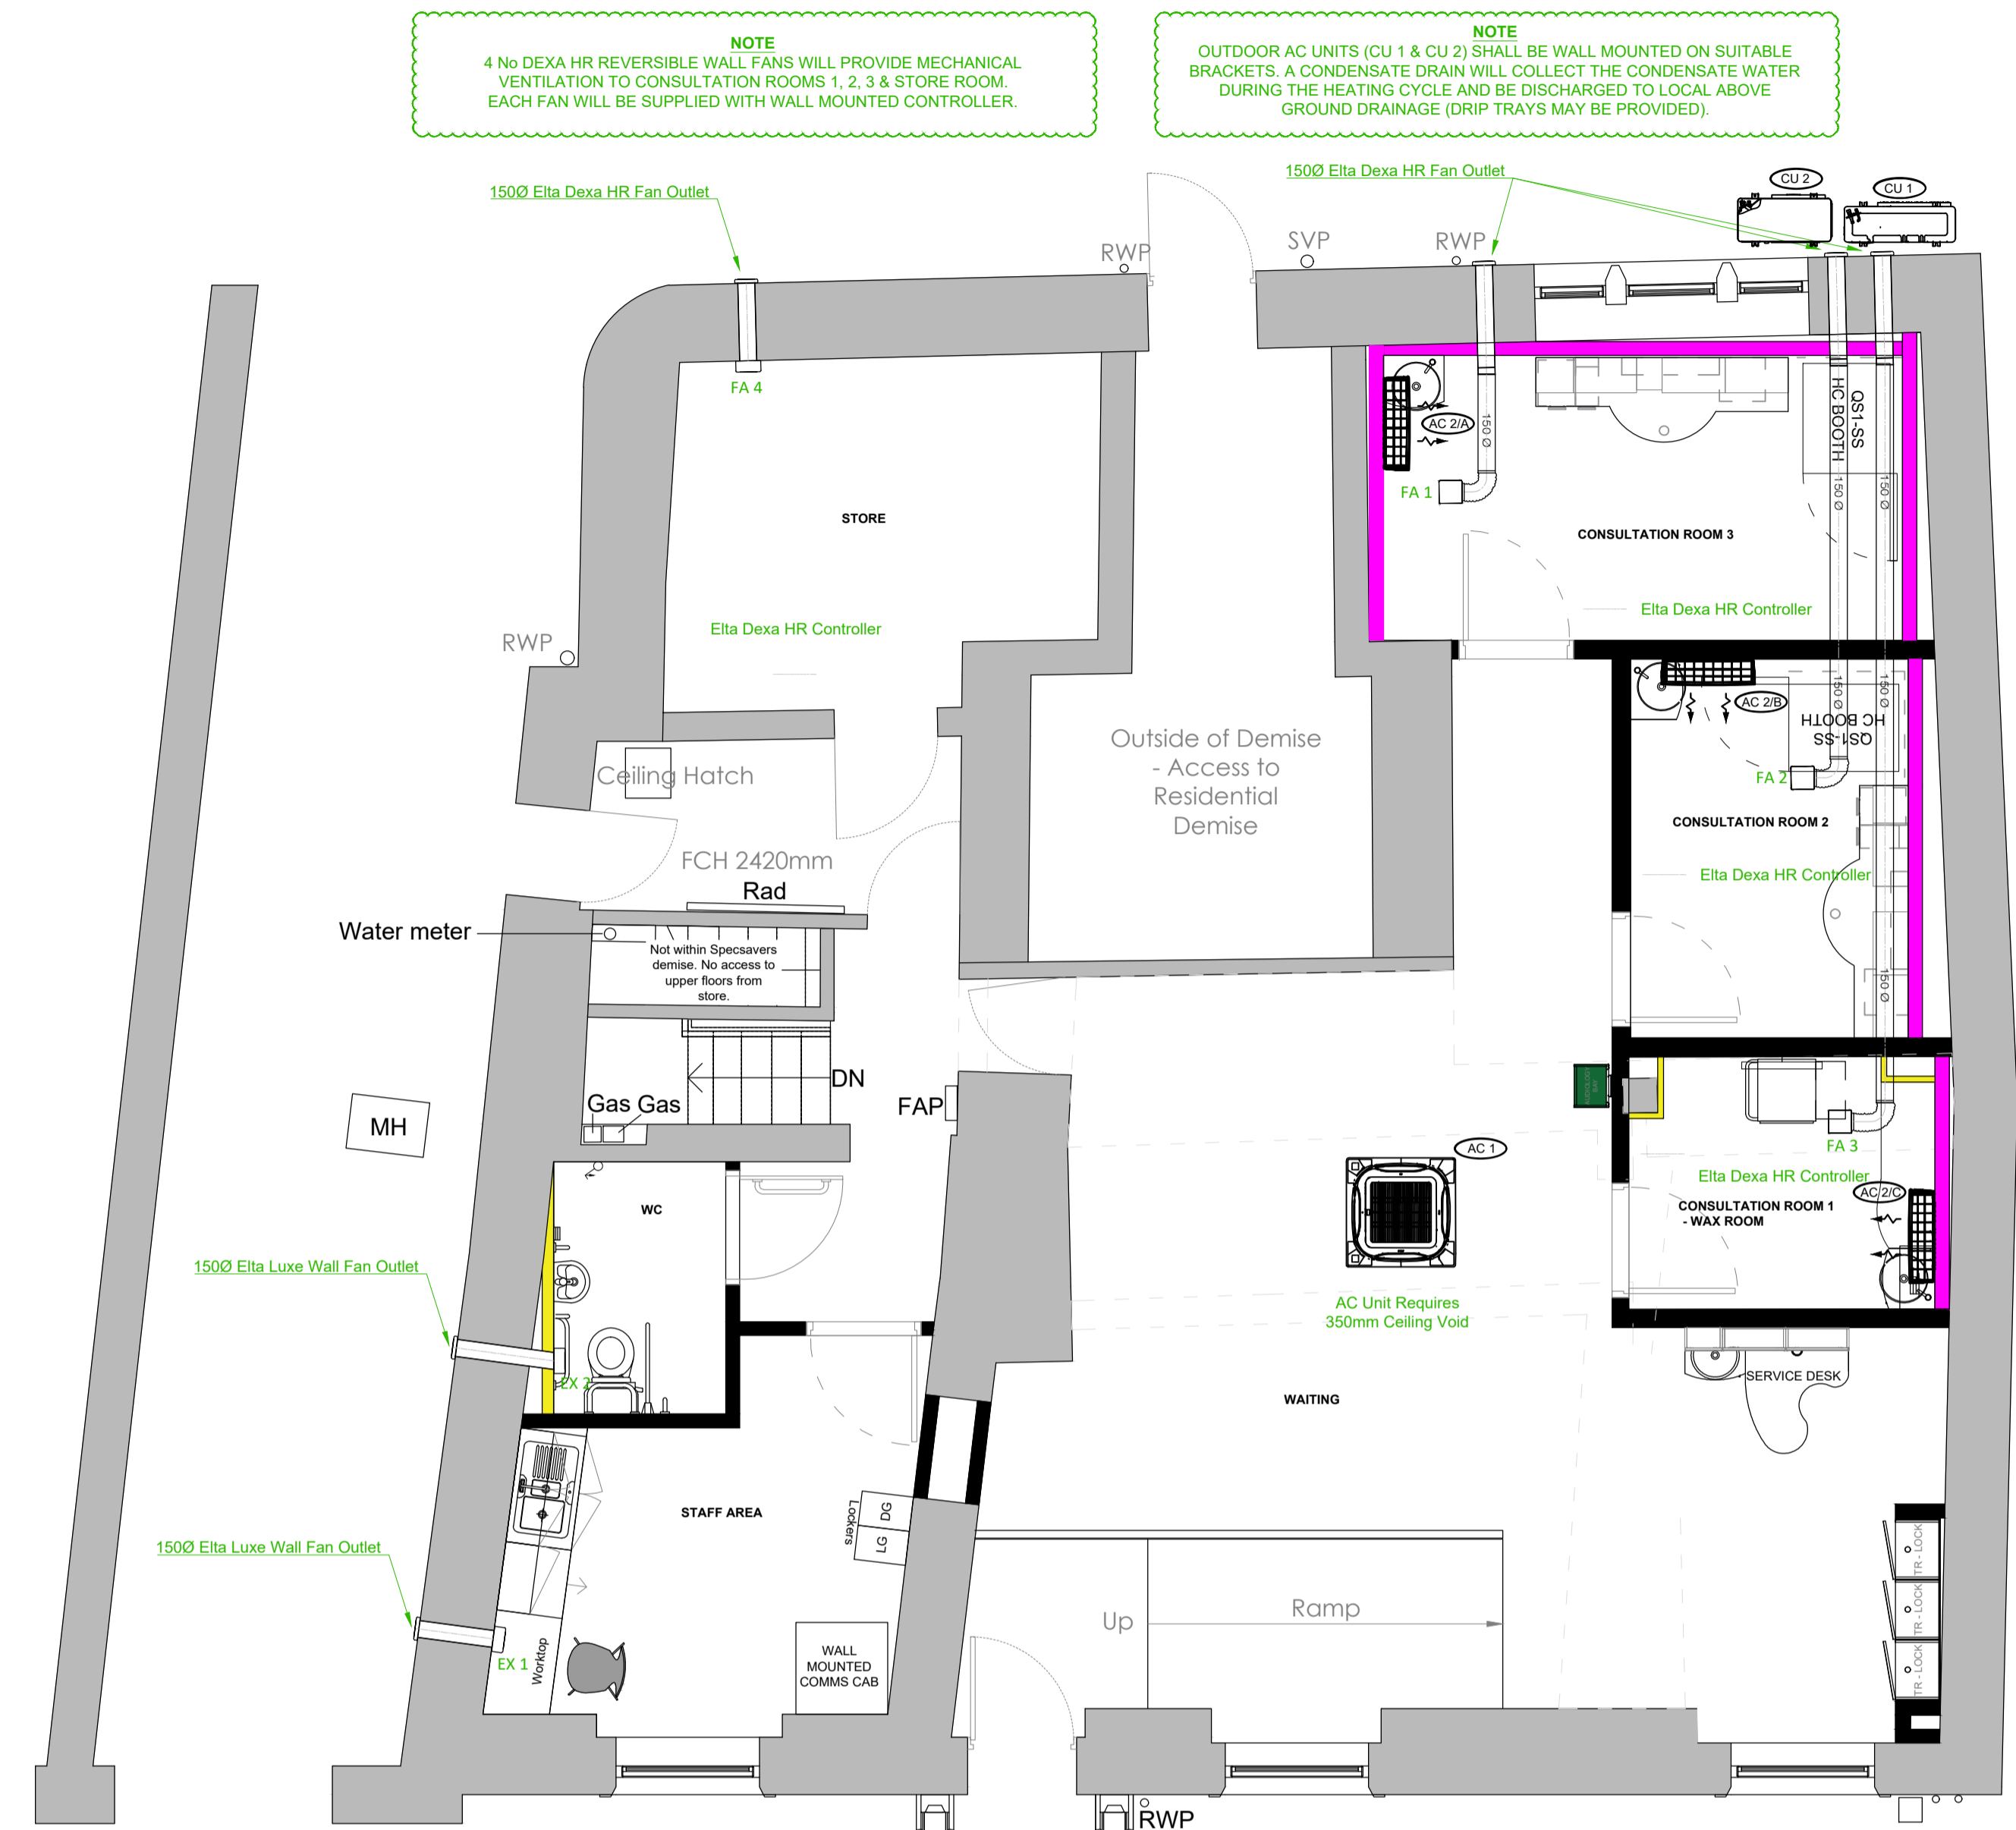


PROPOSED LAYOUT SCALE 1:50 @A1

AIR CONDITIONING EQUIPMENT SCHEDULE

INDOOR UNIT REFERENCE	MODEL REFERENCE	INDOOR UNIT	LOCATION	CONDENSATE DRAIN	REMOTE CONTROLLER TYPE	NOMINAL COOLING CAPACITY	NOMINAL HEATING CAPACITY	OUTDOOR UNIT REFERENCE	MODEL REFERENCE	OUTDOOR UNIT DIMS & WEIGHT
AC 1	DAIKIN FCAG100B	RETAIL		GRAVITY	HARD WIRED BRC1H52W	9.5kw	10.8kw	CU 1	DAIKIN AZAS100MV	990mm (h) x 940mm(w) x 320mm(d) 70kg
AC 2/A	DAIKIN FTXP20N	CONSULTATION ROOM 3		GRAVITY	WIRELESS	2.0kw	2.5kw	CU 2	DAIKIN 4MXM80A9	734mm (h) x 974mm(w) x 408mm(d) 67kg
AC 2/B	DAIKIN FTXP20N	CONSULTATION ROOM 2		GRAVITY	WIRELESS	2.0kw	2.5kw			
AC 2/C	DAIKIN FTXP20N	CONSULTATION ROOM 1		GRAVITY	WIRELESS	2.0kw	2.5kw			

 Scale - 1:50 @ A1



DWG NO: 2582 - 01 REVISION: -

CLIENT: Specsavers

PROJECT: 7 Church Street Clitheroe Lancashire BB7 2DD

TITLE: Ventilation Drawings

ORIGIN: GT CHECKED: -

SCALE: 1:50 DATE: 22/12/25

**fisch**  
STRUCTURED CREATIVITY

FISCH DESIGN LTD  
1 HERITAGE BUSINESS CENTRE  
DERBY ROAD, BELPER  
DERBYSHIRE, DE56 1SW

+44 (0)1773 828222 / WWW.FISCHDESIGN.CO.UK / MAIL@FISCHDESIGN.CO.UK