

INDICATIVE DRAINAGE LAYOUT


KEY:

- PROPOSED RWG
- RE RODDING EYE
- PROPOSED SURFACE WATER
- EXISTING INSPECTION CHAMBERS

NB:
THIS DRAWING HAS BEEN PRODUCED AS A
REFERENCE PLAN FOR DISCUSSION ONLY.

NEW TARMAc-ED AREAS TO BE OF THE
PERMEABLE VARIETY - COSTS PERMITTING

ALL COBBLED AREA TO BE DRAINED BY
DRAINAGE CHANELS TO THE EDGES OF THE
SURFACE, DRAINED TO INDEPENDENT
SOAKAWAYS - REFER TO RG PARKINS FOR
DETAIL DESIGN

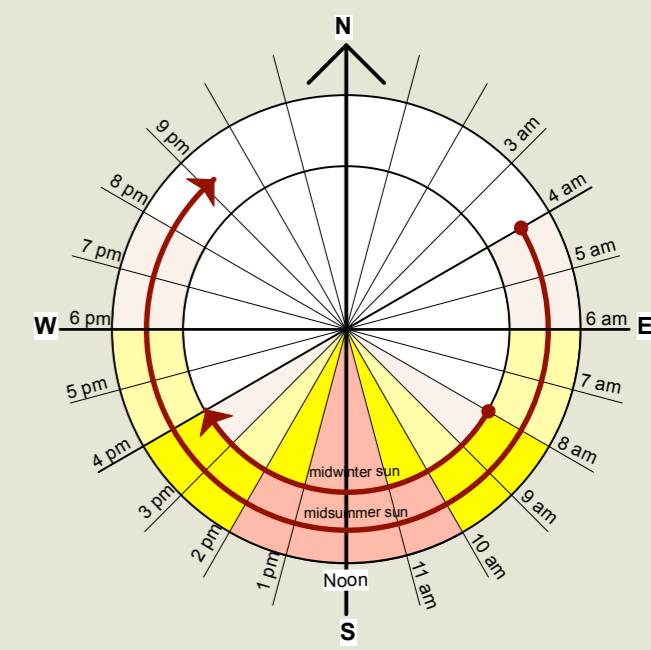

Foul drainage run with inspection chamber to connect to existing foul drainage system using existing connections

REFER TO SEPARATE PLANNING APPLICATION

Rev.	Initial	Date	Note

PLANNING

project: **Wharf Farm**

Proposed
drawing title: **Drainage Strategy**

dwg no. 6567 /cb/105 date Mar 26 rev -

scale 1:200 @ A1P drawn by AR checked by LD

MASON GILLIBRAND
ARCHITECTS

16 WILLOW MILL | FELL VIEW | CATON | LANCASTER | LA2 9RA
T: (01524) 771 377 | admin@masongillibrand.co.uk | www.masongillibrand.com

Drawings are based on survey data and may not accurately represent what is physically present. Do not scale from this drawing. All dimensions are to be verified on site before proceeding with work. All dimensions are in millimetres unless stated otherwise. Mason Gillibrand Architects are to be notified in writing of any discrepancies immediately.

