



DEVELOPMENT

- DO NOT SCALE OFF THIS DRAWING
- GENERAL NOTES
1. THIS DRAWING TO READ IN CONJUNCTION WITH ALL RELEVANT STRUCTURAL AND ARCHITECTURAL DRAWINGS AND SPECIFICATIONS.
 2. ALL DIMENSIONS TO BE CHECKED ON SITE BY THE CONTRACTOR/FABRICATOR PRIOR TO COMMENCEMENT OF WORKS.
 3. ALL DIMENSIONS ARE IN MILLIMETRES UNLESS STATED OTHERWISE.
 4. ALL WORKS TO BE CARRIED OUT IN STRICT ACCORDANCE WITH THE ENGINEER'S SPECIFICATIONS, RELEVANT BRITISH STANDARDS AND WHERE APPLICABLE LOCAL AUTHORITIES REQUIREMENTS.

- KEY**
- PROPOSED FOUL SEWER
 - PROPOSED SW SEWER
 - PROPOSED FOUL RISING MAIN
 - - - PROPOSED SW RISING MAIN
 - EXG. FOUL SEWER
 - EXG. SW SEWER
 - EXG. PRIVATE SW SEWER
 - EXG. PRIVATE FOUL SEWER
 - SEWER EASEMENTS

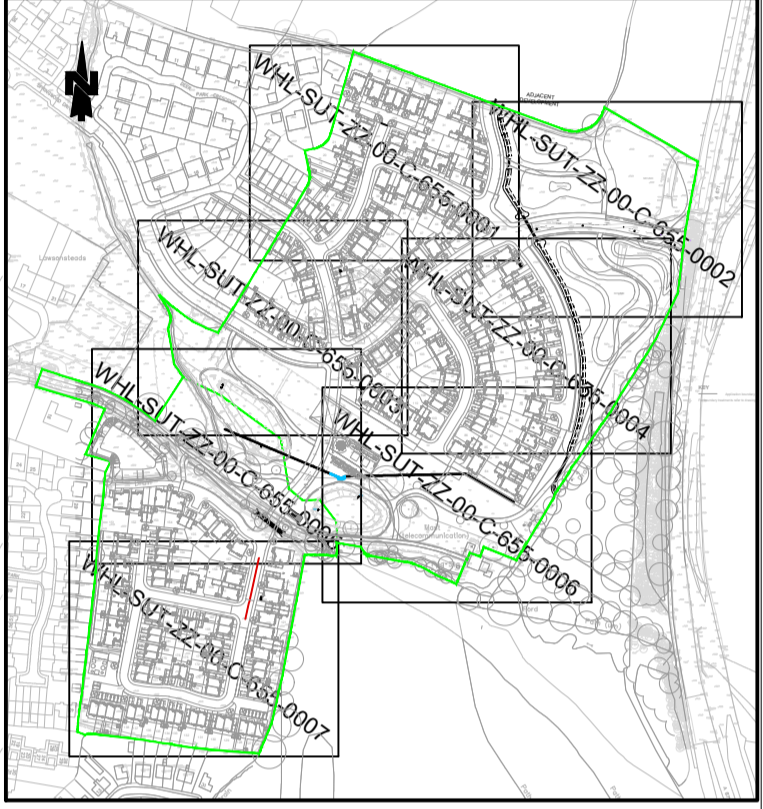

LOCATION PLAN
1:5000

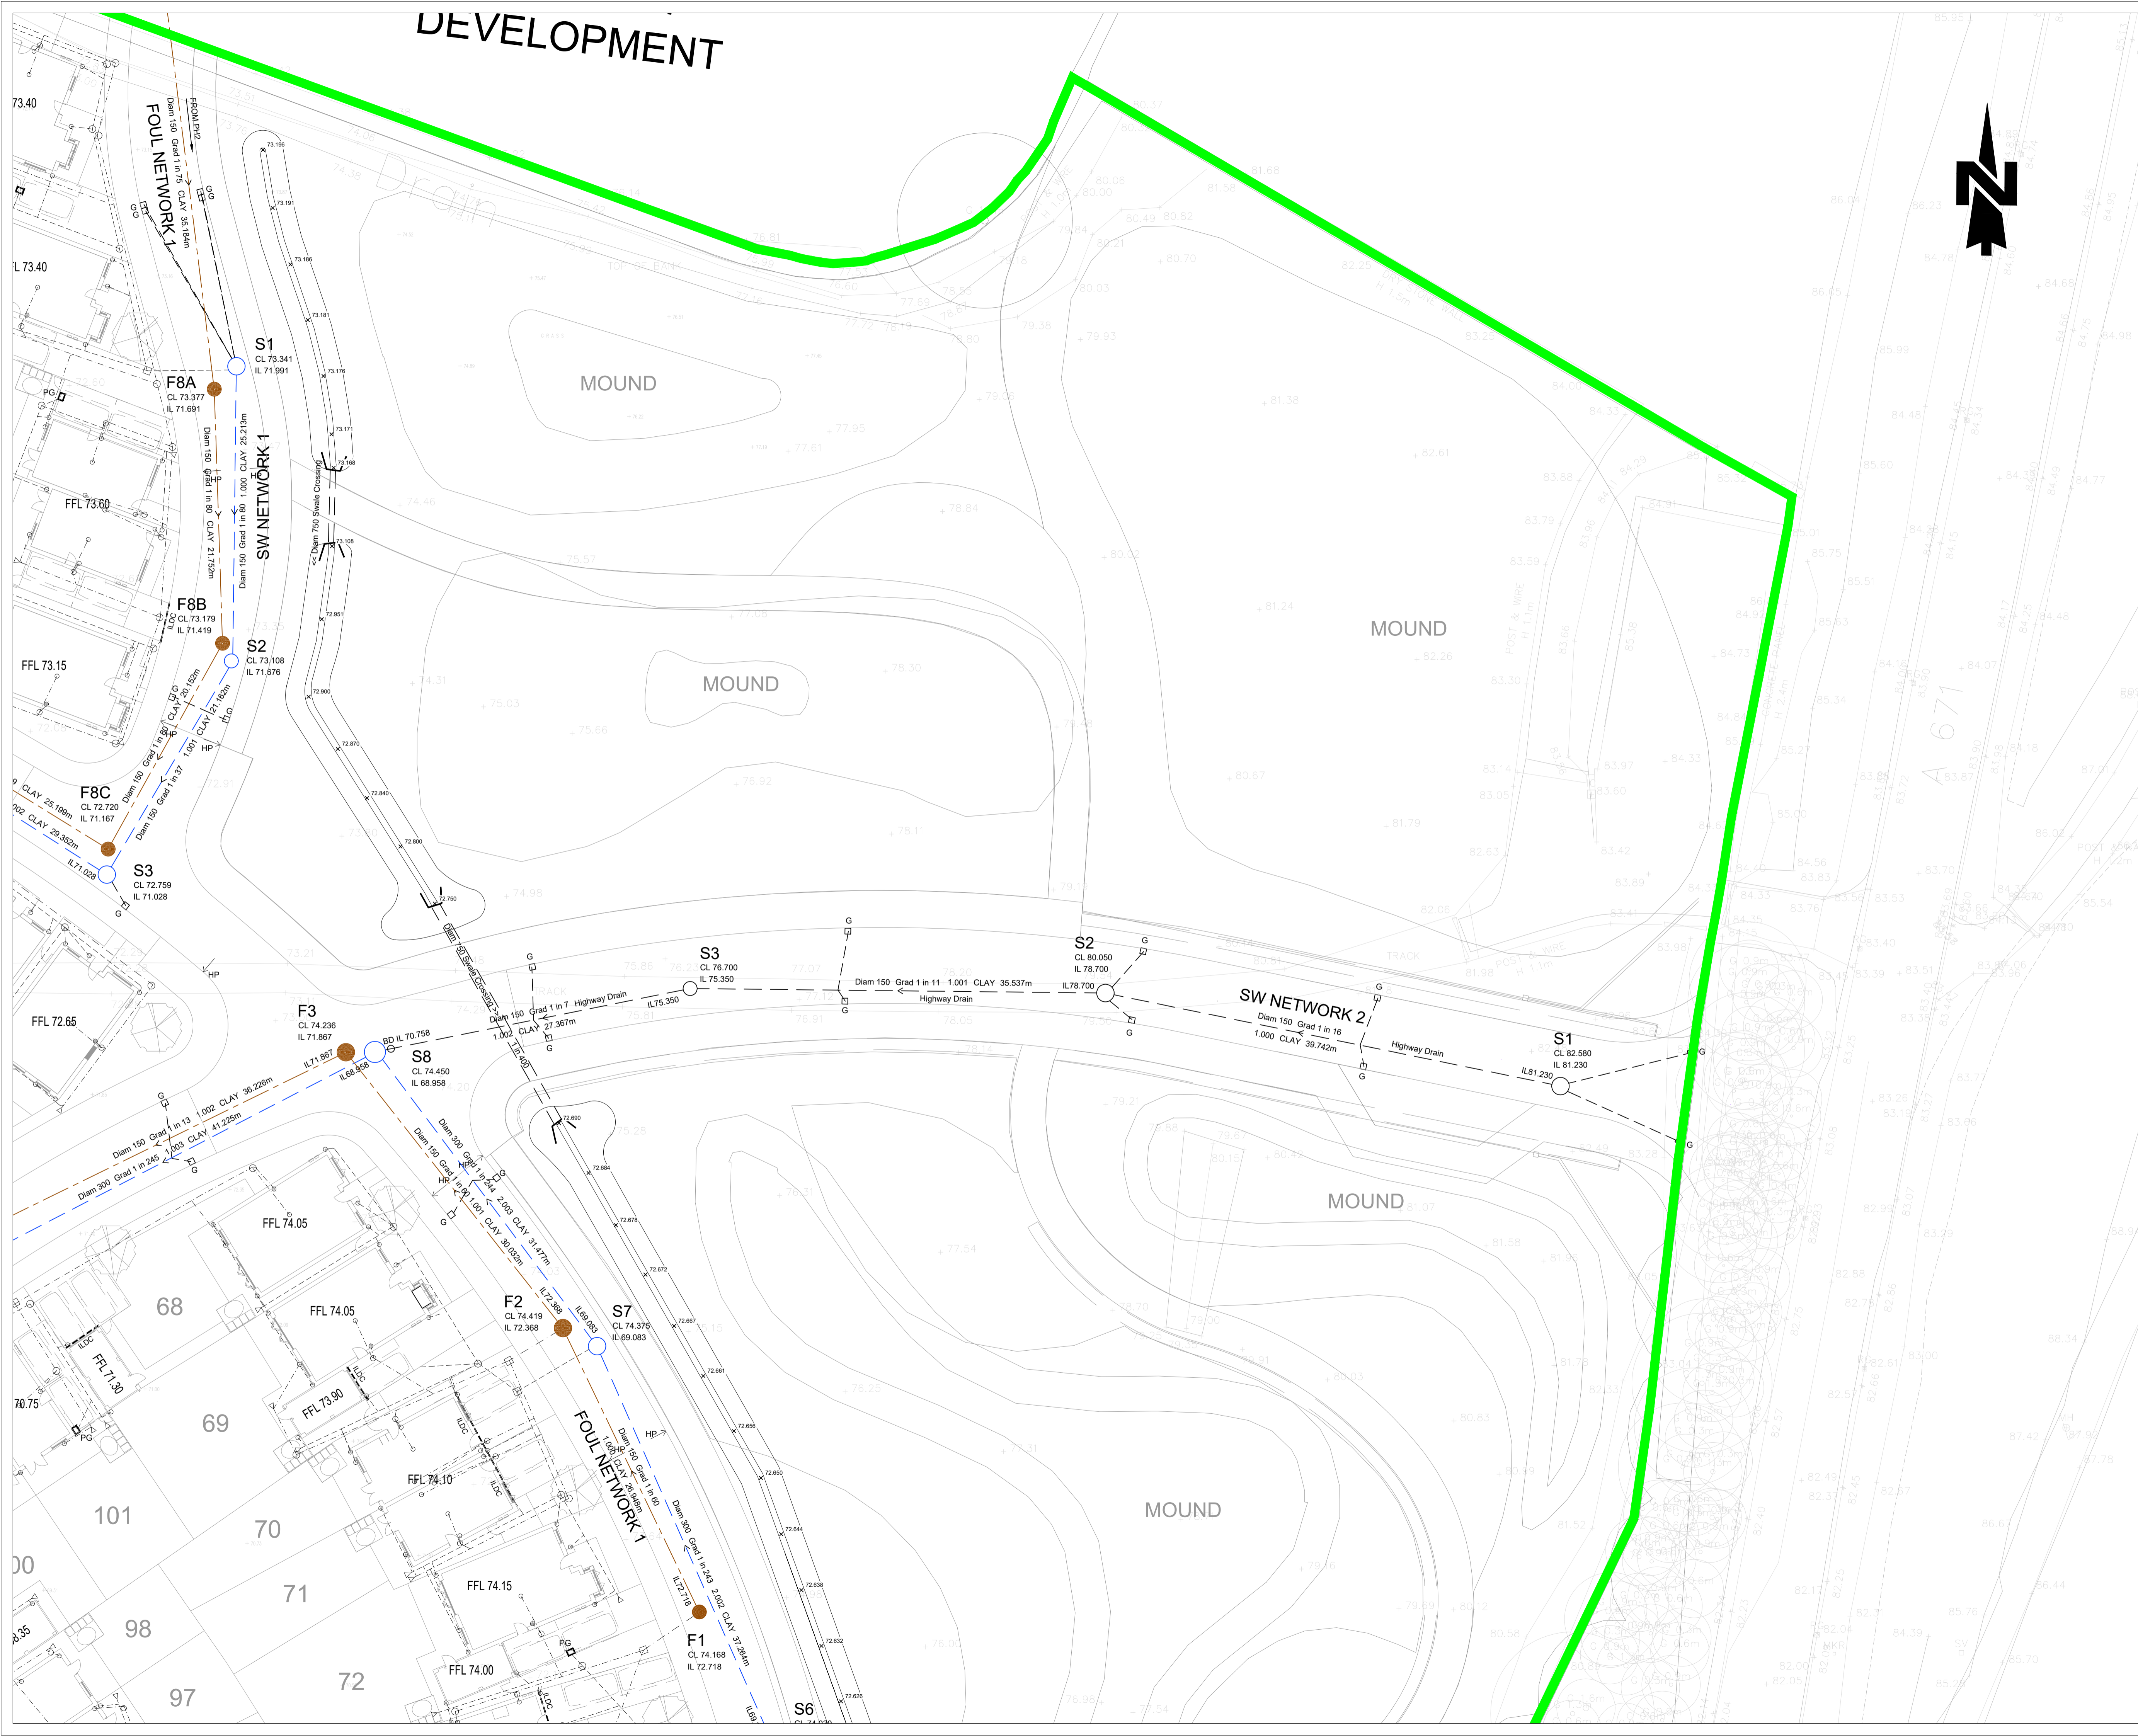

Rev	Description	Date	By	Chkd
W4	SWALE INVERT LEVELS ADDED	02.05.23	MG	SB
W3	EXG MH ADJACENT PLOT 30 AMENDED	25.04.23	MG	SB
W2	PH2 ACCESS ROAD ADDED (ROAD 4)	05.04.22	MG	SB
W1	CONSTRUCTION ISSUE	21.04.21	MG	SB
P4	UPDATED TO LATEST DESIGN	26.11.20	MG	SB
P3	PRIVATE DRAINAGE ADDED	31.07.20	MG	SB
P2	COVER LEVELS AMENDED	26.02.20	MG	SB
P1	PRELIMINARY DRAWING	28.01.20	MG	SB

Drawing Status: **WORKING DRAWING**

Client: **LOVELL**

Project: **WHALLEY ROAD LANCASHIRE**

Drawing Title: **PROPOSED DRAINAGE LAYOUT SHEET 2 OF 7**

Date: JAN 2020	Drawn By: MG	Checked By: SB
Scale at A1: 1:250	Project Number: 30626	Revision: W4
Sheet Number: WHL-SUT-ZZ-00-C-655-0002		