


 
This drawing is to be read in conjunction with all relevant Architect, consultants' and specialist drawings and specifications. The Architect is to be notified of any discrepancies before proceeding. Do not scale from this drawing. All dimensions and levels are to be checked on site. This drawing is subject to copyright. All work carried out before Planning and Building Permission has been granted is at the contractor's risk.

 
Note: proposed drawing based on OS diag information. All illustrated dimensions are approximate and all site dimensions are to be checked on site and subject to site survey.

 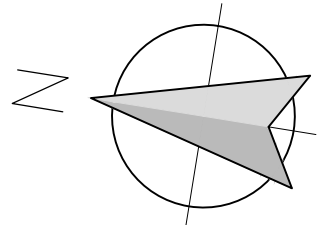


KEY


 HATCHED AREA INDICATES EXISTING PITCH TO BE FLOOD LIGHTED.

 TYPE 1 FLOODLIGHTING POSITIONED AT 30°
QUANTITY - 12


 TYPE 2 FLOODLIGHTING POSITIONED AT 60°
QUANTITY - 8

 M1-M4 ILLUSTRATE THE POSITION OF 4NO
16M HIGH MASTS EACH FITTED WITH 3NO TYPE
1 FLOODLIGHTING AND 2NO TYPE 2 FLOODLIGHTING


 SPECTATORS STAND

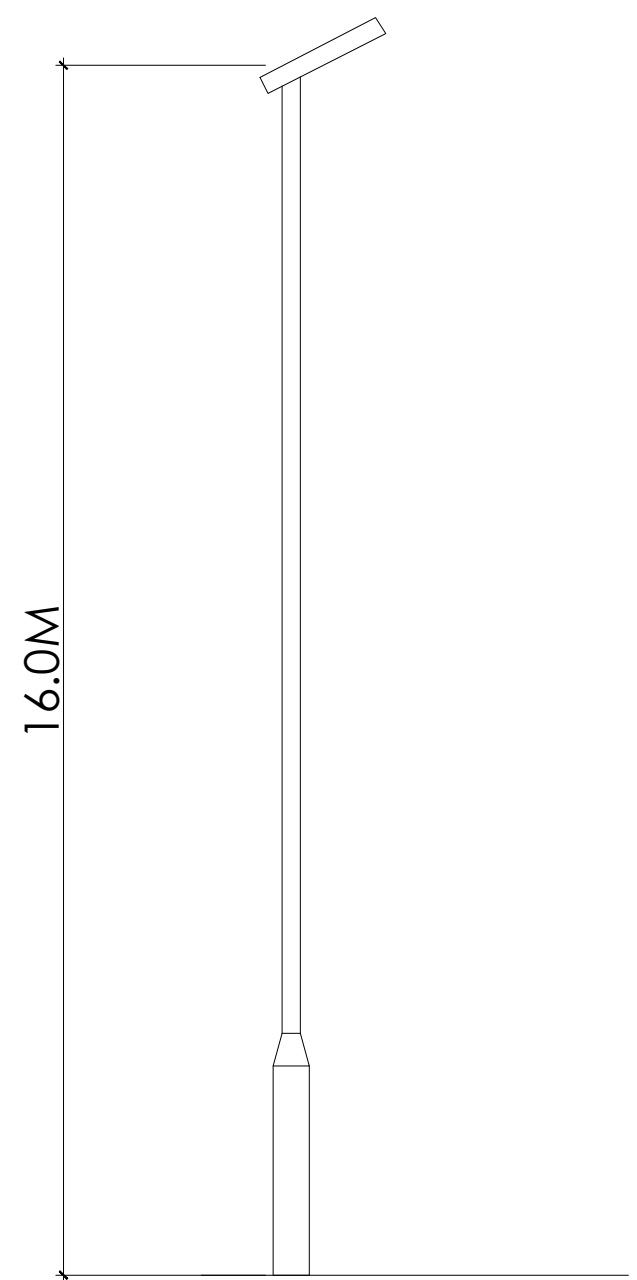


PROPOSED FLOODLIGHT ELEVATION- REFER TO
MANUFACTURERS INFORMATION SCALE 1:100

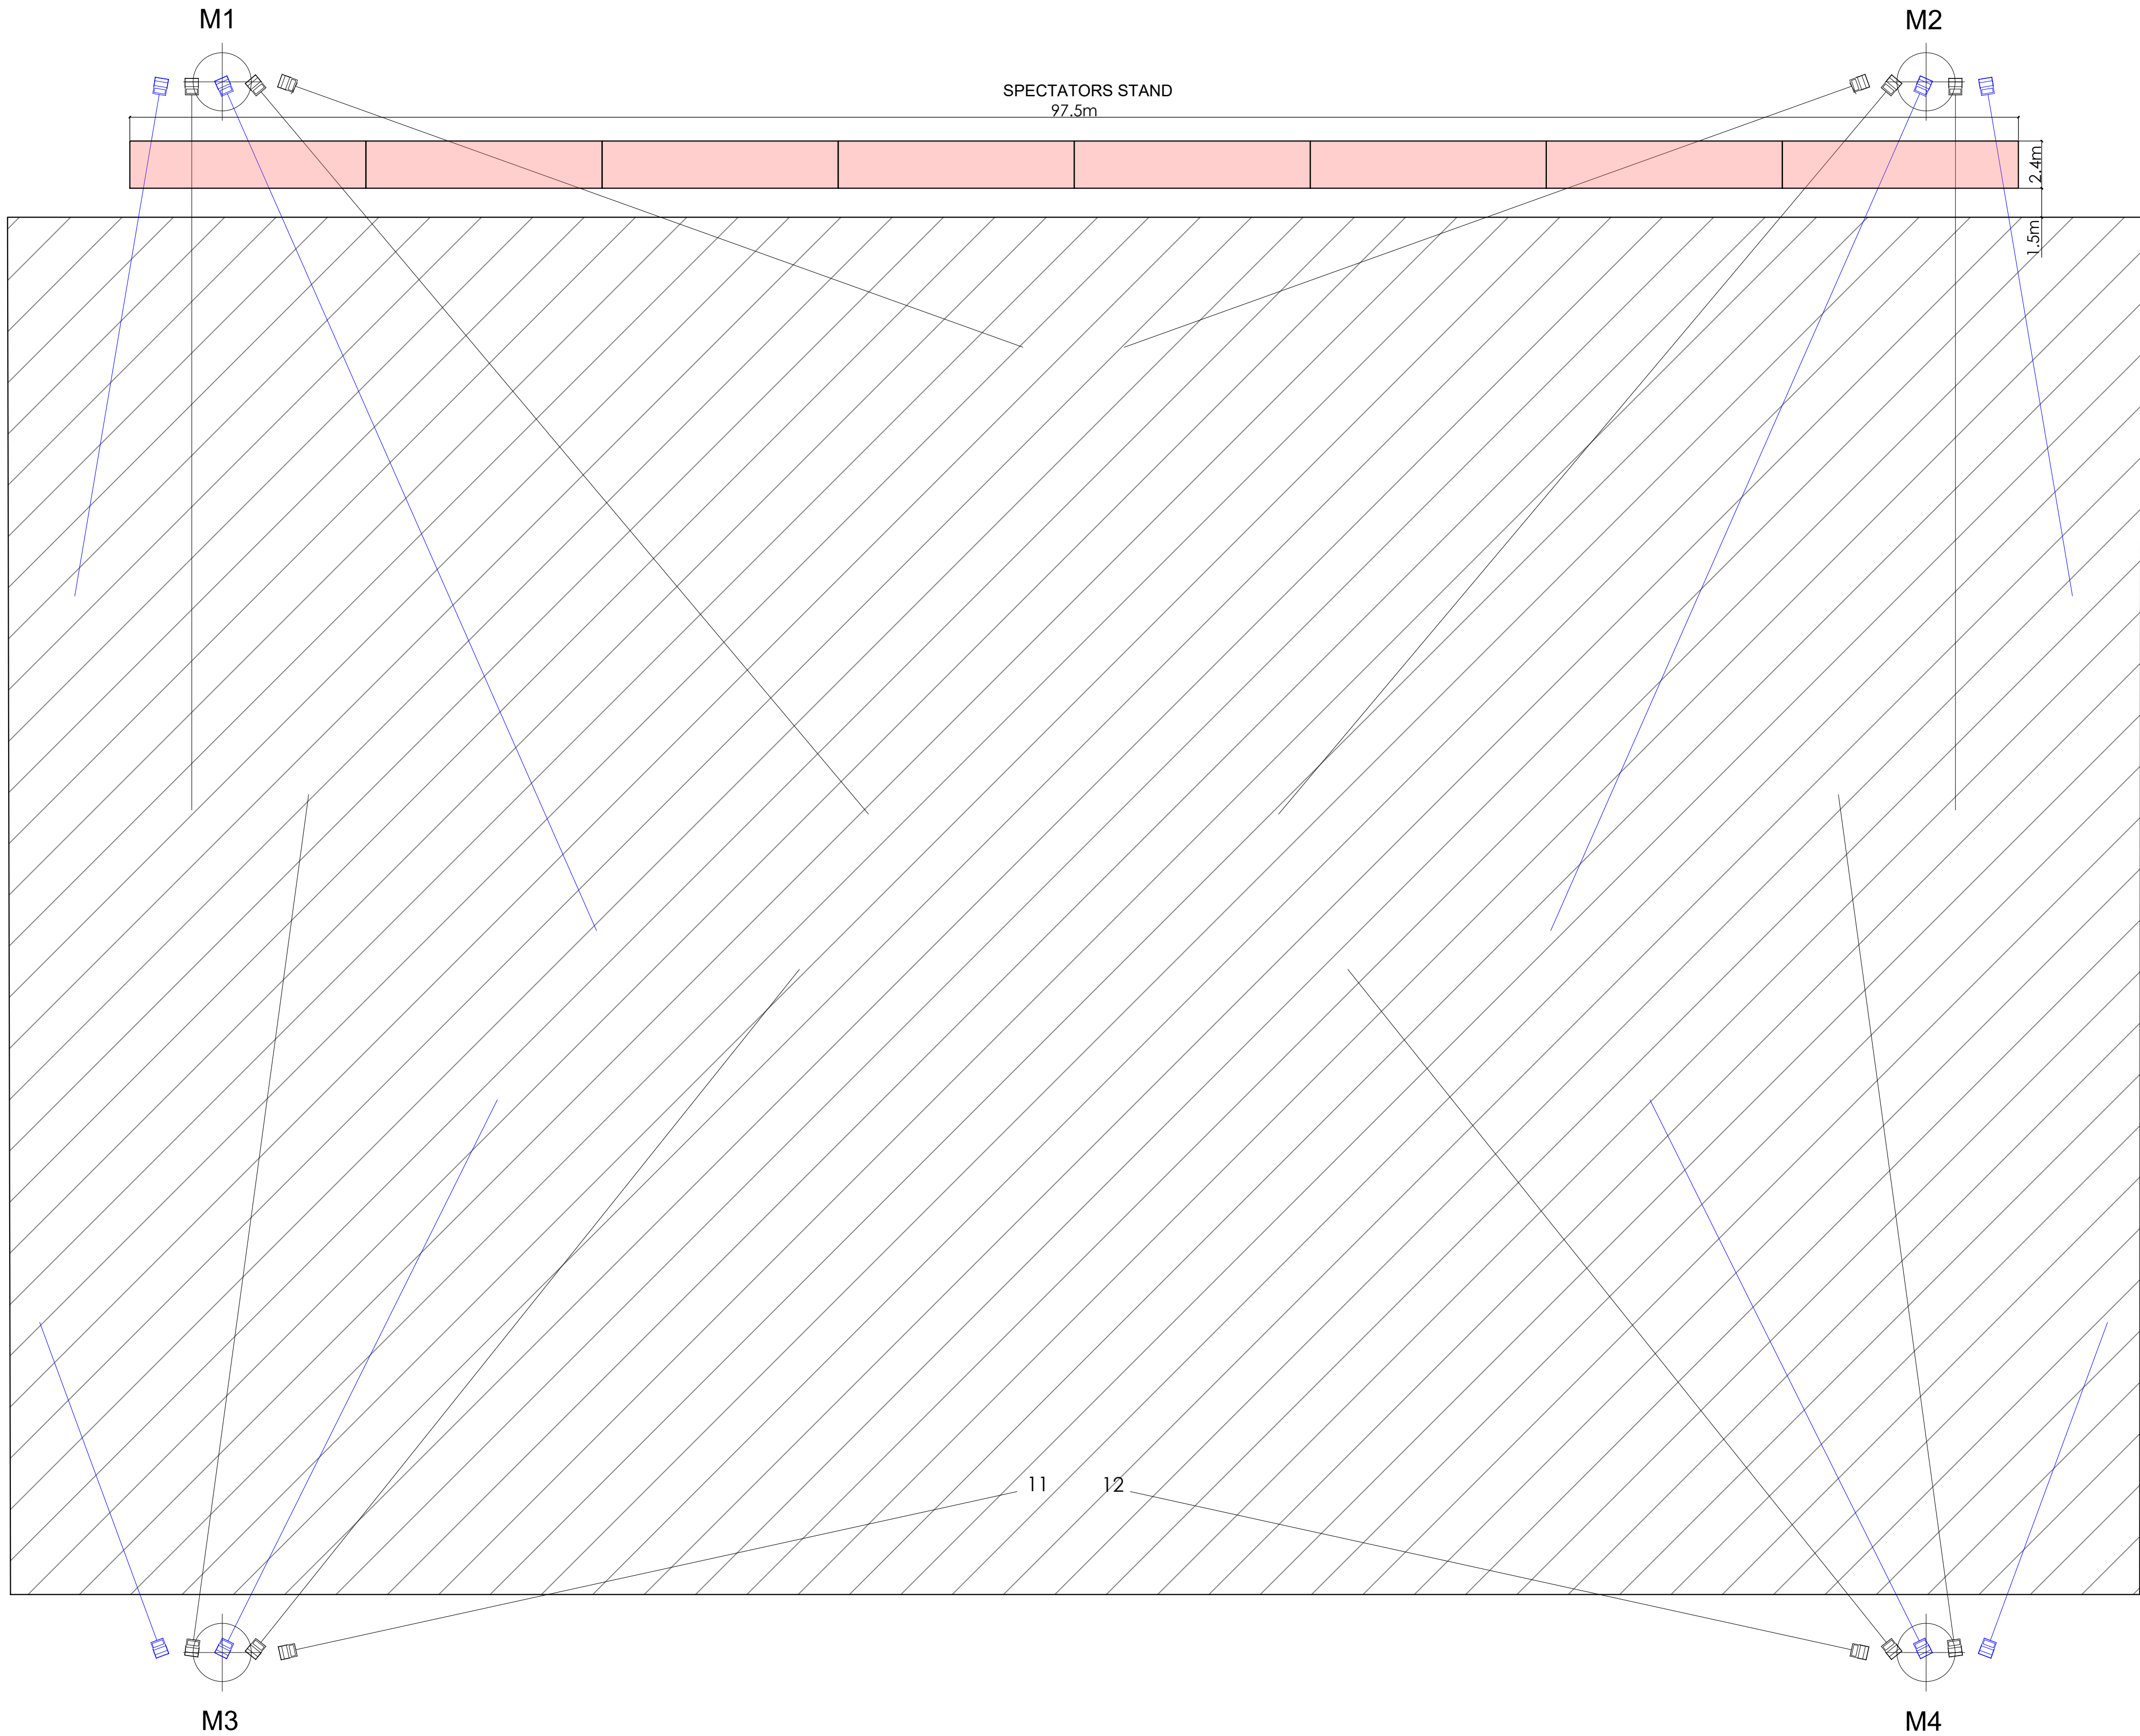


PROPOSED LAYOUT SCALE 1:200

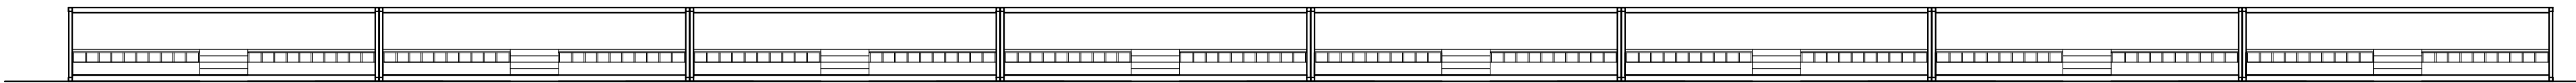

PROPOSED SPECTATOR STAND - FRONT ELEVATION SCALE 1:200

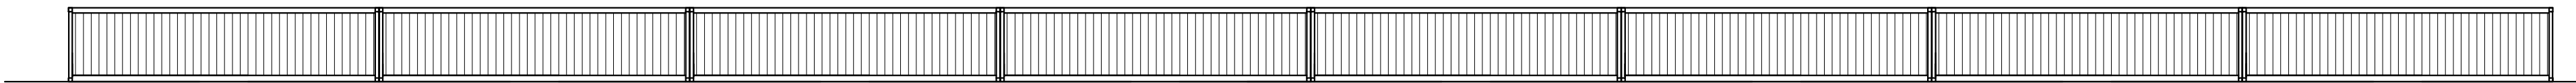

PROPOSED SPECTATOR STAND - REAR ELEVATION SCALE 1:200

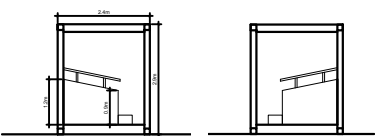

PROPOSED SPECTATOR STAND - SIDE ELEVATIONS SCALE 1:200

Client		
Blackburn Rovers FC		
Job title		
Proposed Floodlighting and new Spectator Stand at Blackburn Rovers Training Facilities Brockhall Village, Old Langho Blackburn BB6 8FA		
Drawing title		
Proposed Floodlighting Layout and Spectators Structure		
PLANNING STAGE		
Scale	Date	Drawn
1:200 @ A1	JUNE 26	RBM


SUNDERLAND PEACOCK & ASSOCIATES LTD.
HAZELMER, PIMLICO ROAD, CLITHEROE
LANCASHIRE, BB7 2AG
T 01200 423178 F 01200 427328
E info@sunderlandpeacock.com
www.sunderlandpeacock.com



7445 -P02	REV
	-