
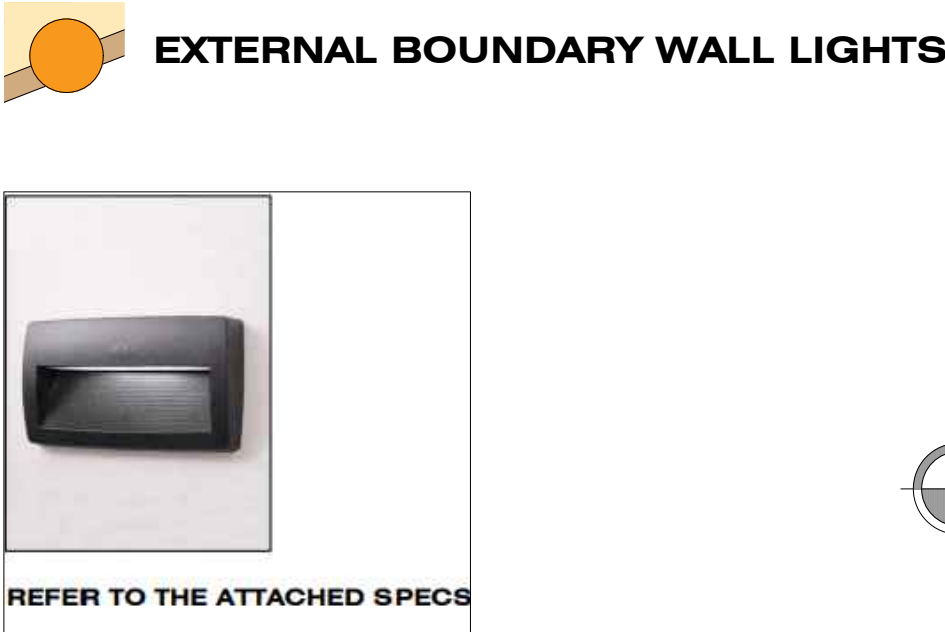


PROPOSED EXTETRNAL LIGHTING PLAN

THE OLD BARN, MALT KILN BROW, CHIPPING, PR3 2GP

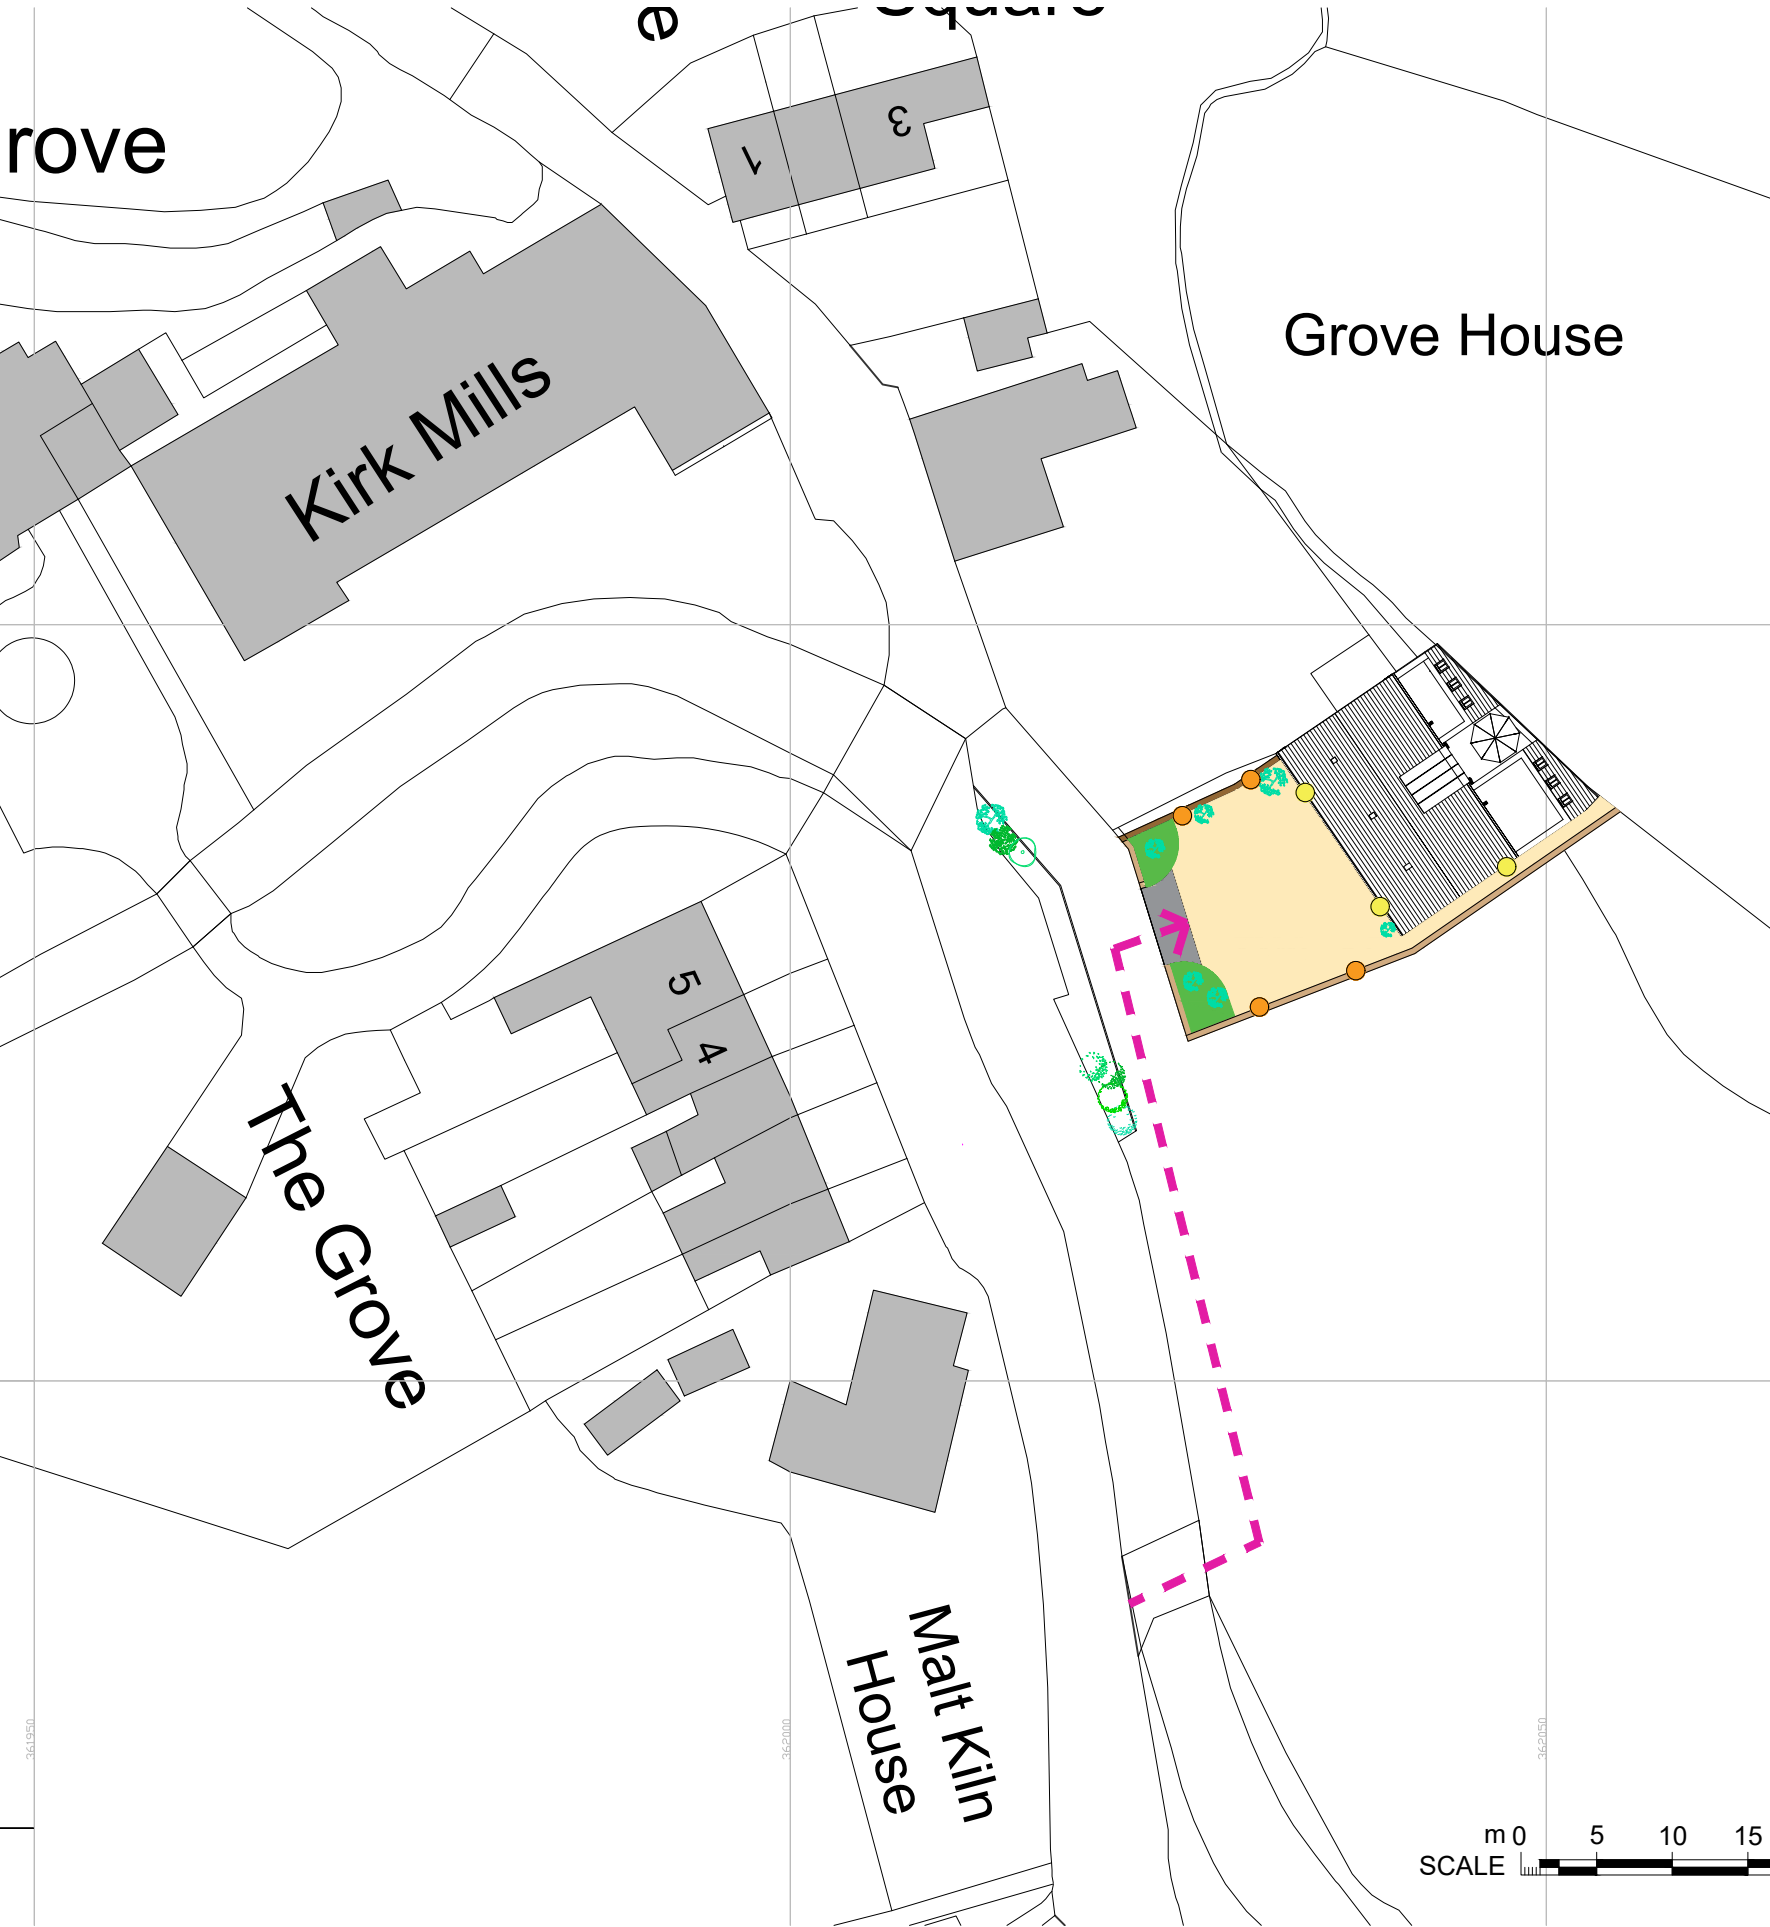

2 CROSTON VILLA
HIGH STREET
GARSTANG
PRESTON
PR3 1EA

CLIENT: MR & MRS PLATT
DWG STATUS: SKETCH SCHEME

DRAWING TITLE / PROJECT: THE OLD BARN, MALT KILN BROW, CHIPPING
SITE LAYOUT PLAN AS PROPOSED

DRAWING No. GA3543-EVCP-01
SCALE(S): 1:200 AT A3
DATE: AUG 26'

ALL DIMENSIONS TO BE CHECKED ON SITE AND ANY DISCREPANCIES TO BE REPORTED TO GRAHAM ANTHONY ASSOCIATES PRIOR TO PROCEEDING WITH ANY WORKS.